


F.A. RITE	SECTION	COUNTY	TOTAL SHEETS	SHEET NO.
	03-00026-00-PK	MADISON	53	44
	06-00026-01-MS			

FEDERAL AID PROJECT

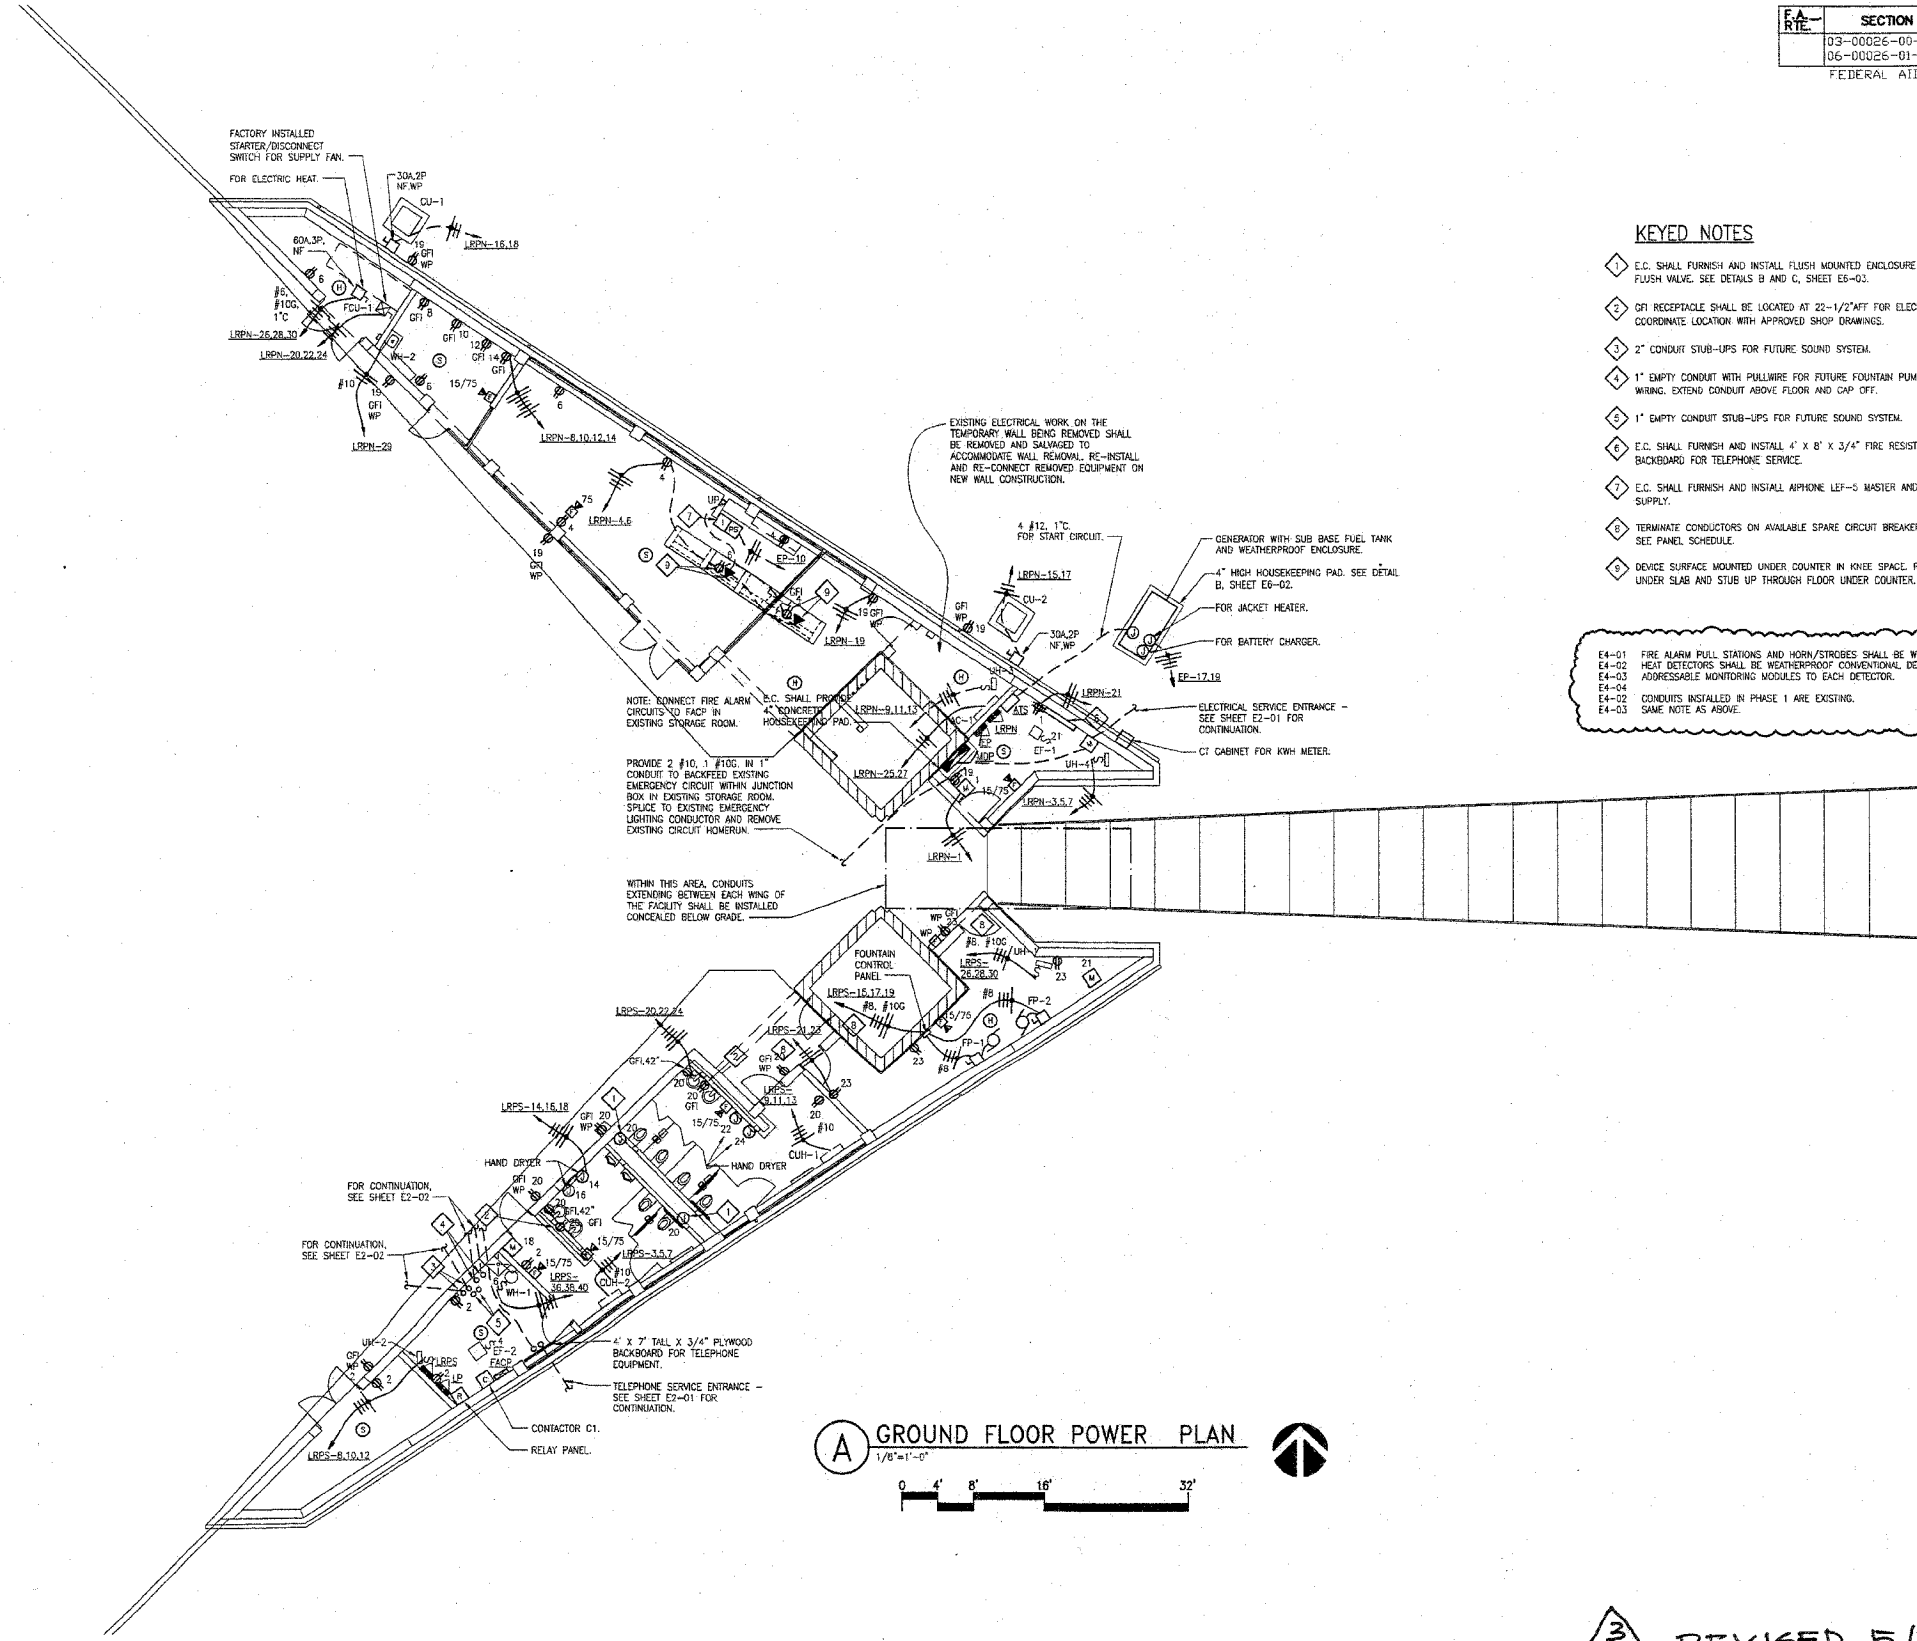

- KEYED NOTES**
- 1 E.C. SHALL FURNISH AND INSTALL FLUSH MOUNTED ENCLOSURE FOR ELECTRONIC FLUSH VALVE. SEE DETAILS B AND C, SHEET E6-02.
 - 2 GFI RECEPTACLE SHALL BE LOCATED AT 22-1/2" AFF FOR ELECTRONIC FAUCETS. COORDINATE LOCATION WITH APPROVED SHOP DRAWINGS.
 - 3 2" CONDUIT STUB-UPS FOR FUTURE SOUND SYSTEM.
 - 4 1" EMPTY CONDUIT WITH PULLWIRE FOR FUTURE FOUNTAIN PUMP POWER SUPPLY WIRING. EXTEND CONDUIT ABOVE FLOOR AND CAP OFF.
 - 5 1" EMPTY CONDUIT STUB-UPS FOR FUTURE SOUND SYSTEM.
 - 6 E.C. SHALL FURNISH AND INSTALL 4' X 8' X 3/4" FIRE RESISTANT PLYWOOD BACKBOARD FOR TELEPHONE SERVICE.
 - 7 E.C. SHALL FURNISH AND INSTALL AIRPHONE LET-5 MASTER AND ASSOCIATED POWER SUPPLY.
 - 8 TERMINATE CONDUCTORS ON AVAILABLE SPARE CIRCUIT BREAKER IN PANEL LRPS. SEE PANEL SCHEDULE.
 - 9 DEVICE SURFACE MOUNTED UNDER COUNTER IN KNOE SPACE. ROUTE CONDUITS UNDER SLAB AND STUB UP THROUGH FLOOR UNDER COUNTER.

REVIS 3-3-08

E4-01 FIRE ALARM PULL STATIONS AND HORN/STROBES SHALL BE WEATHERPROOF.
 E4-02 HEAT DETECTORS SHALL BE WEATHERPROOF CONVENTIONAL DETECTORS WITH ADDRESSABLE MONITORING MODULES TO EACH DETECTOR.
 E4-04 ADDRESSABLE MONITORING MODULES TO EACH DETECTOR.
 E4-02 CONDUITS INSTALLED IN PHASE 1 ARE EXISTING.
 E4-03 SAME NOTE AS ABOVE.

311 N. Broadway
 Suite 200
 St. Louis, MO 63102
 (314) 341-0100
 FAX: (314) 341-0255

KAI

**LEWIS AND CLARK MEMORIAL TOWER
 VILLAGE OF HARTFORD, ILLINOIS
 HARTFORD, ILLINOIS 62049**

SHEET TITLE:
**GROUND FLOOR
 POWER PLAN**

DATE	REVISIONS
3-3-08	
5-30-08	

KENNEDY PROJECT NO
KAI# 10-02048

ISSUE DATE
APRIL 11, 2008

SHEET NO
E4-01

© 2008 KENNEDY ASSOCIATES INCORPORATED

3 REVISED 5/30/08