


FA- RTE	SECTION	COUNTY	TOTAL SHEETS	SHEET NO.
	03-00026-00-PK 06-00026-01-MS	MADISON	53	36

PERMITS AND NOTES

- 1 PROVIDE INSTANTANEOUS WATER FOR SK-1.
- 2 1 1/2" WATER TO MAIN SERVICE IN JANITOR'S ROOM OFF OF 2 1/2".
- 3 1HW HY-1 AND 1 CW HY-1, PROVIDE SHUT OFF VALVES ACCESSIBLE BY ACCESS PANEL TO SHUT OFF HY-1'S.
- 4 PROVIDE SHUT OFF VALVE ACCESSIBLE BY ACCESS PANEL TO SHUT OFF DE-1.

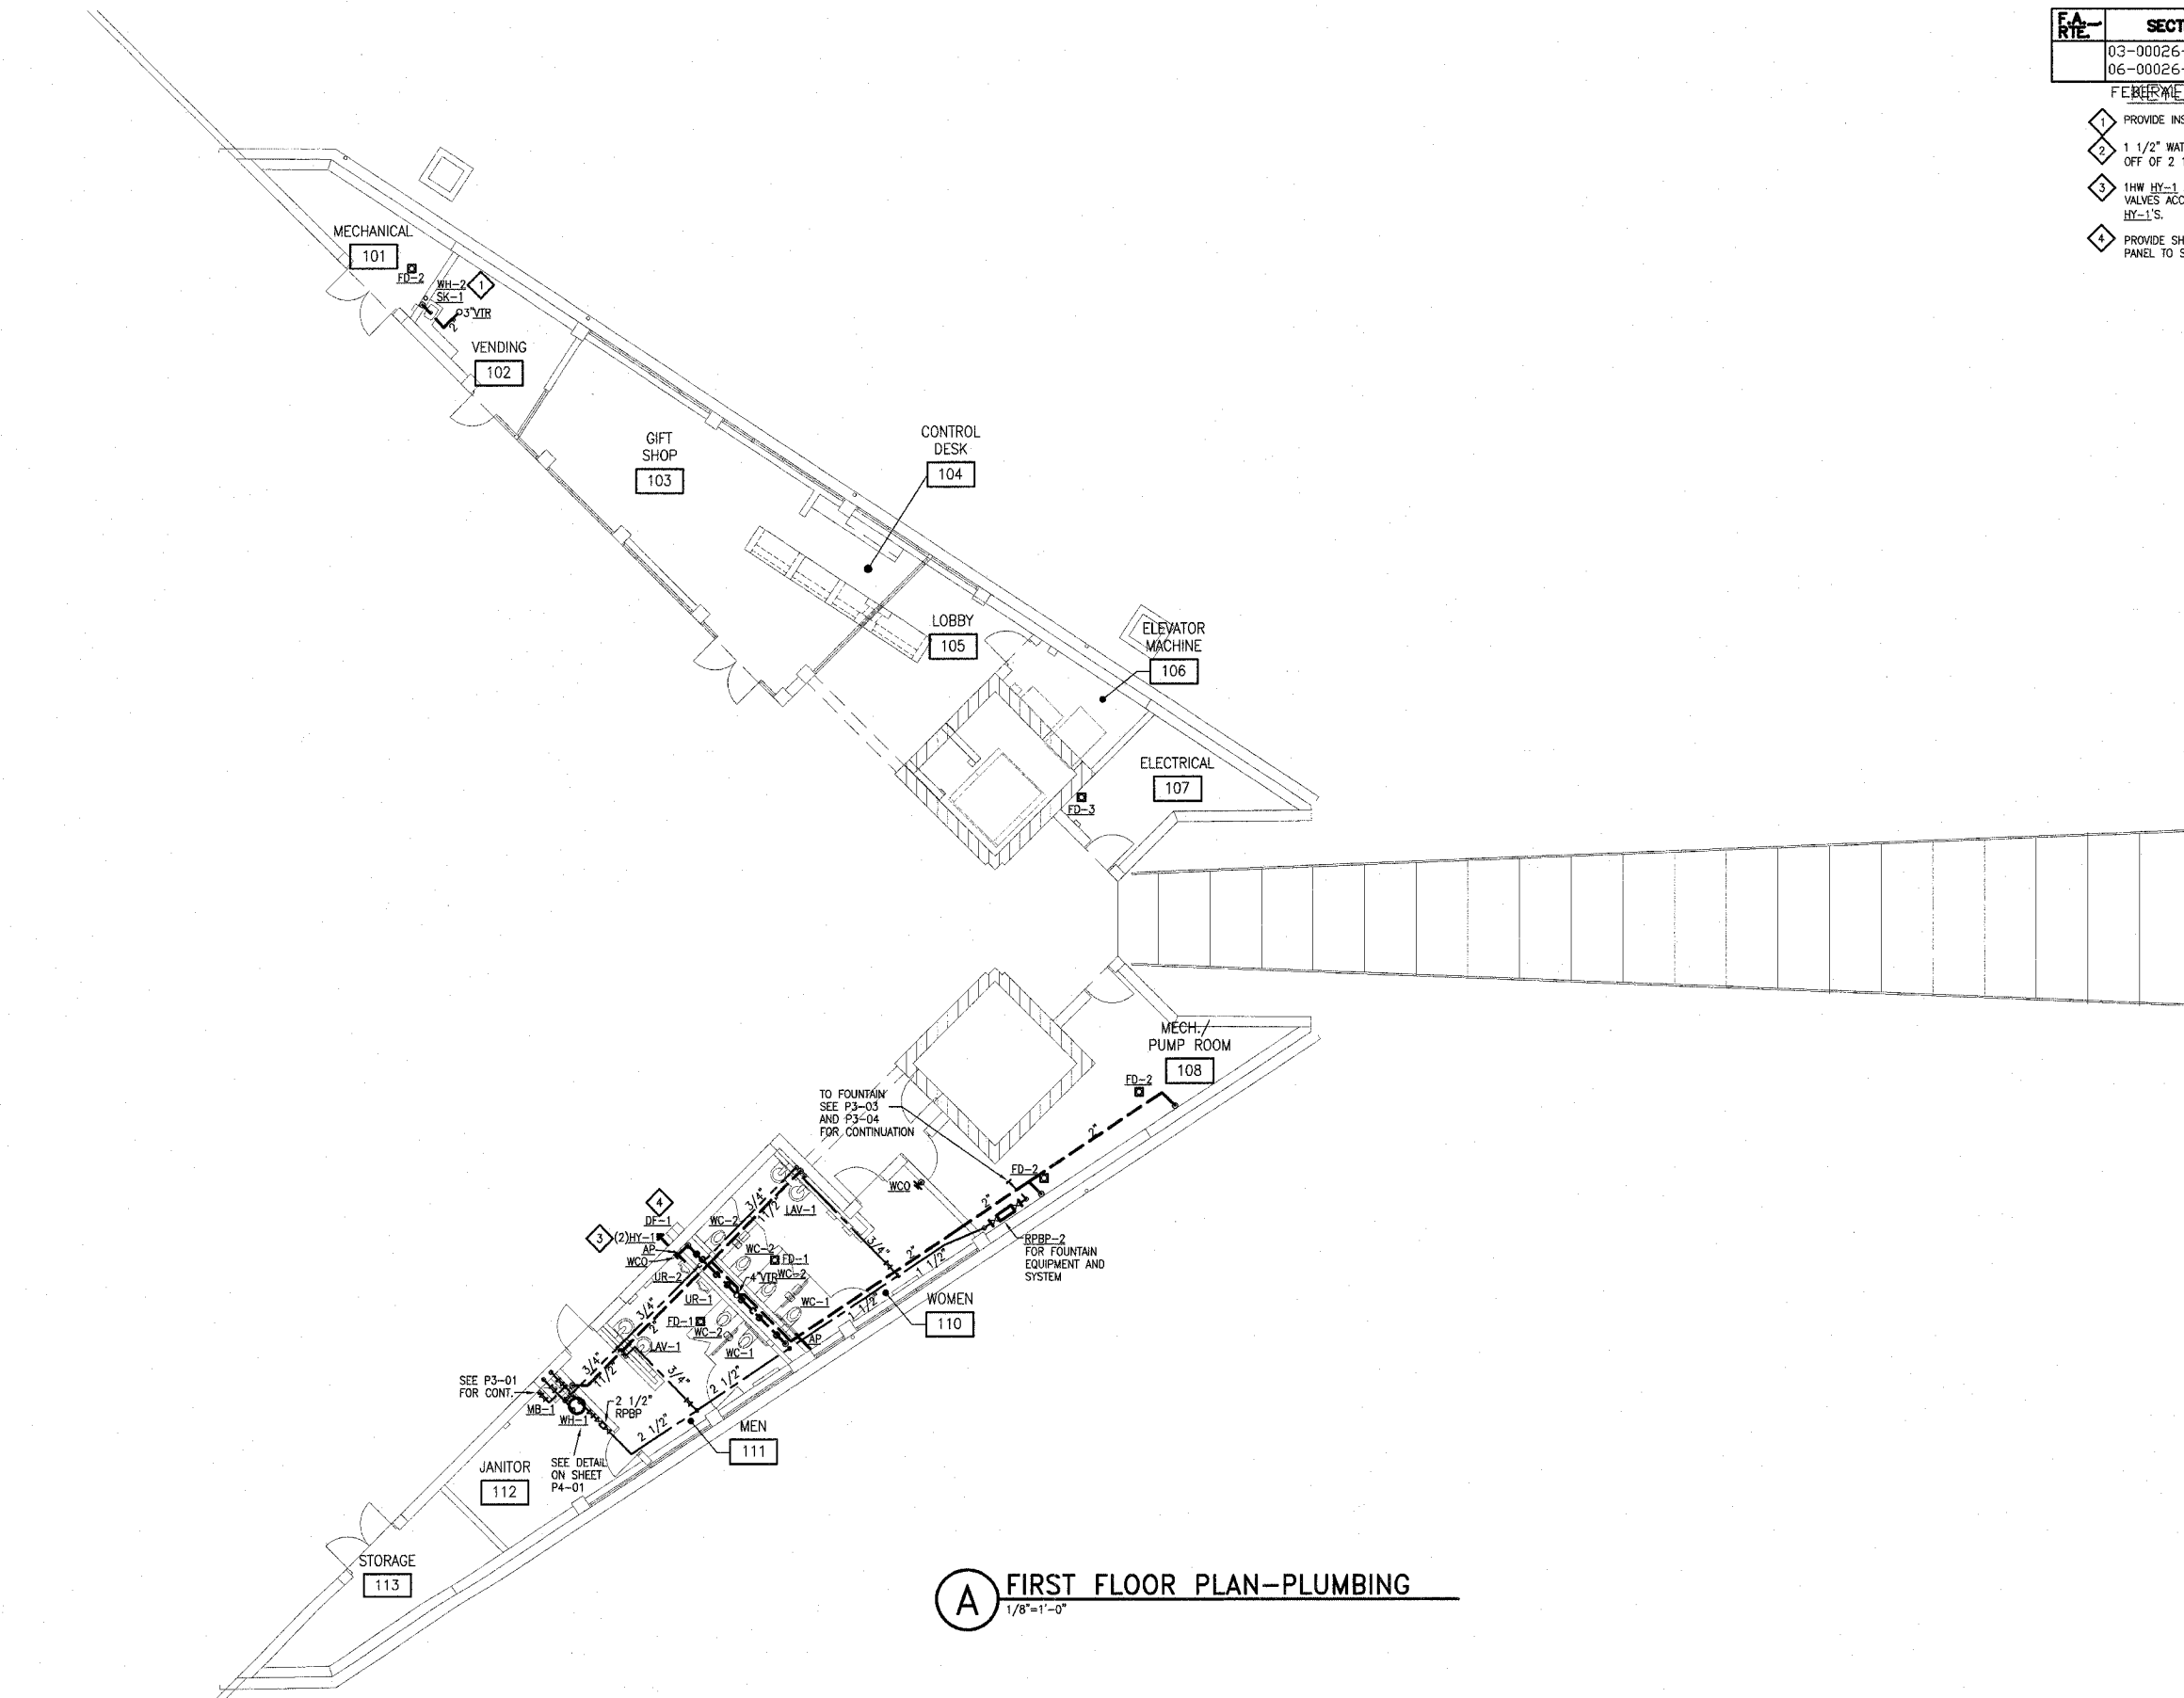

A FIRST FLOOR PLAN-PLUMBING
1/8"=1'-0"

U:\10-02048\CAD\PHASE-2\208\PHASE2\PA3-02.DWG | 7/11/2005 1:16:34 PM | Xref's: BS-PLAN-2A TB24360DL | Imaged: none

211 N. Broadway
Suite 1900
St. Louis, MO
63102
(314) 241-8188
FAX (314) 241-0125



LEWIS AND CLARK MEMORIAL TOWER
VILLAGE OF HARTFORD, ILLINOIS
HARTFORD, ILLINOIS 62049

SHEET TITLE:
**FIRST FLOOR PLAN-
PLUMBING**

REV. NO.	REMARKS	DATE

KENNEDY PROJECT NO
KAI# 10-02048

ISSUE DATE
APRIL 11, 2008

SHEET NO

P3-02