

F.A. RTE.	SECTION	COUNTY	TOTAL SHEETS	SHEET NO.
	03-00026-00-PK	MADISON	53	42
	06-00026-01-MS			

FEDERAL AID PROJECT

211 N. Broadway
Suite 1900
St. Louis, MO 63102
(314) 241-8188
FAX (314) 241-0725



LEWIS AND CLARK MEMORIAL TOWER
VILLAGE OF HARTFORD, ILLINOIS
HARTFORD, ILLINOIS 62049

SHEET TITLE:
PLAZA LIGHTING PLAN

DATE	REMARKS	REV. NO.

PROJECT NO
KAI# 10-02048

ISS
APRIL 11, 2008


SHEET NO

E2-02

© 2008 KENNEDY ASSOCIATES INCORPORATED

KEYED NOTES

- 1 QUARTZITE TYPE BOX INSTALLED IN PAVED AREA. SEE DETAIL A, SHEET E6-01.
- 2 (2) 1" EMPTY CONDUITS WITH PULLWIRE FOR POWER SUPPLY WIRING TO FUTURE FOUNTAIN PUMP AND FUTURE WATER WALL PUMP.
- 3 JUNCTION BOXES FOR CONNECTION OF EMERGENCY POWER SUPPLY. SEE DETAILS D AND E ON SHEET E6-03.
- 4 EXTEND AND CONNECT TO PANEL VIA RELAY PANEL OR CONTACTOR.

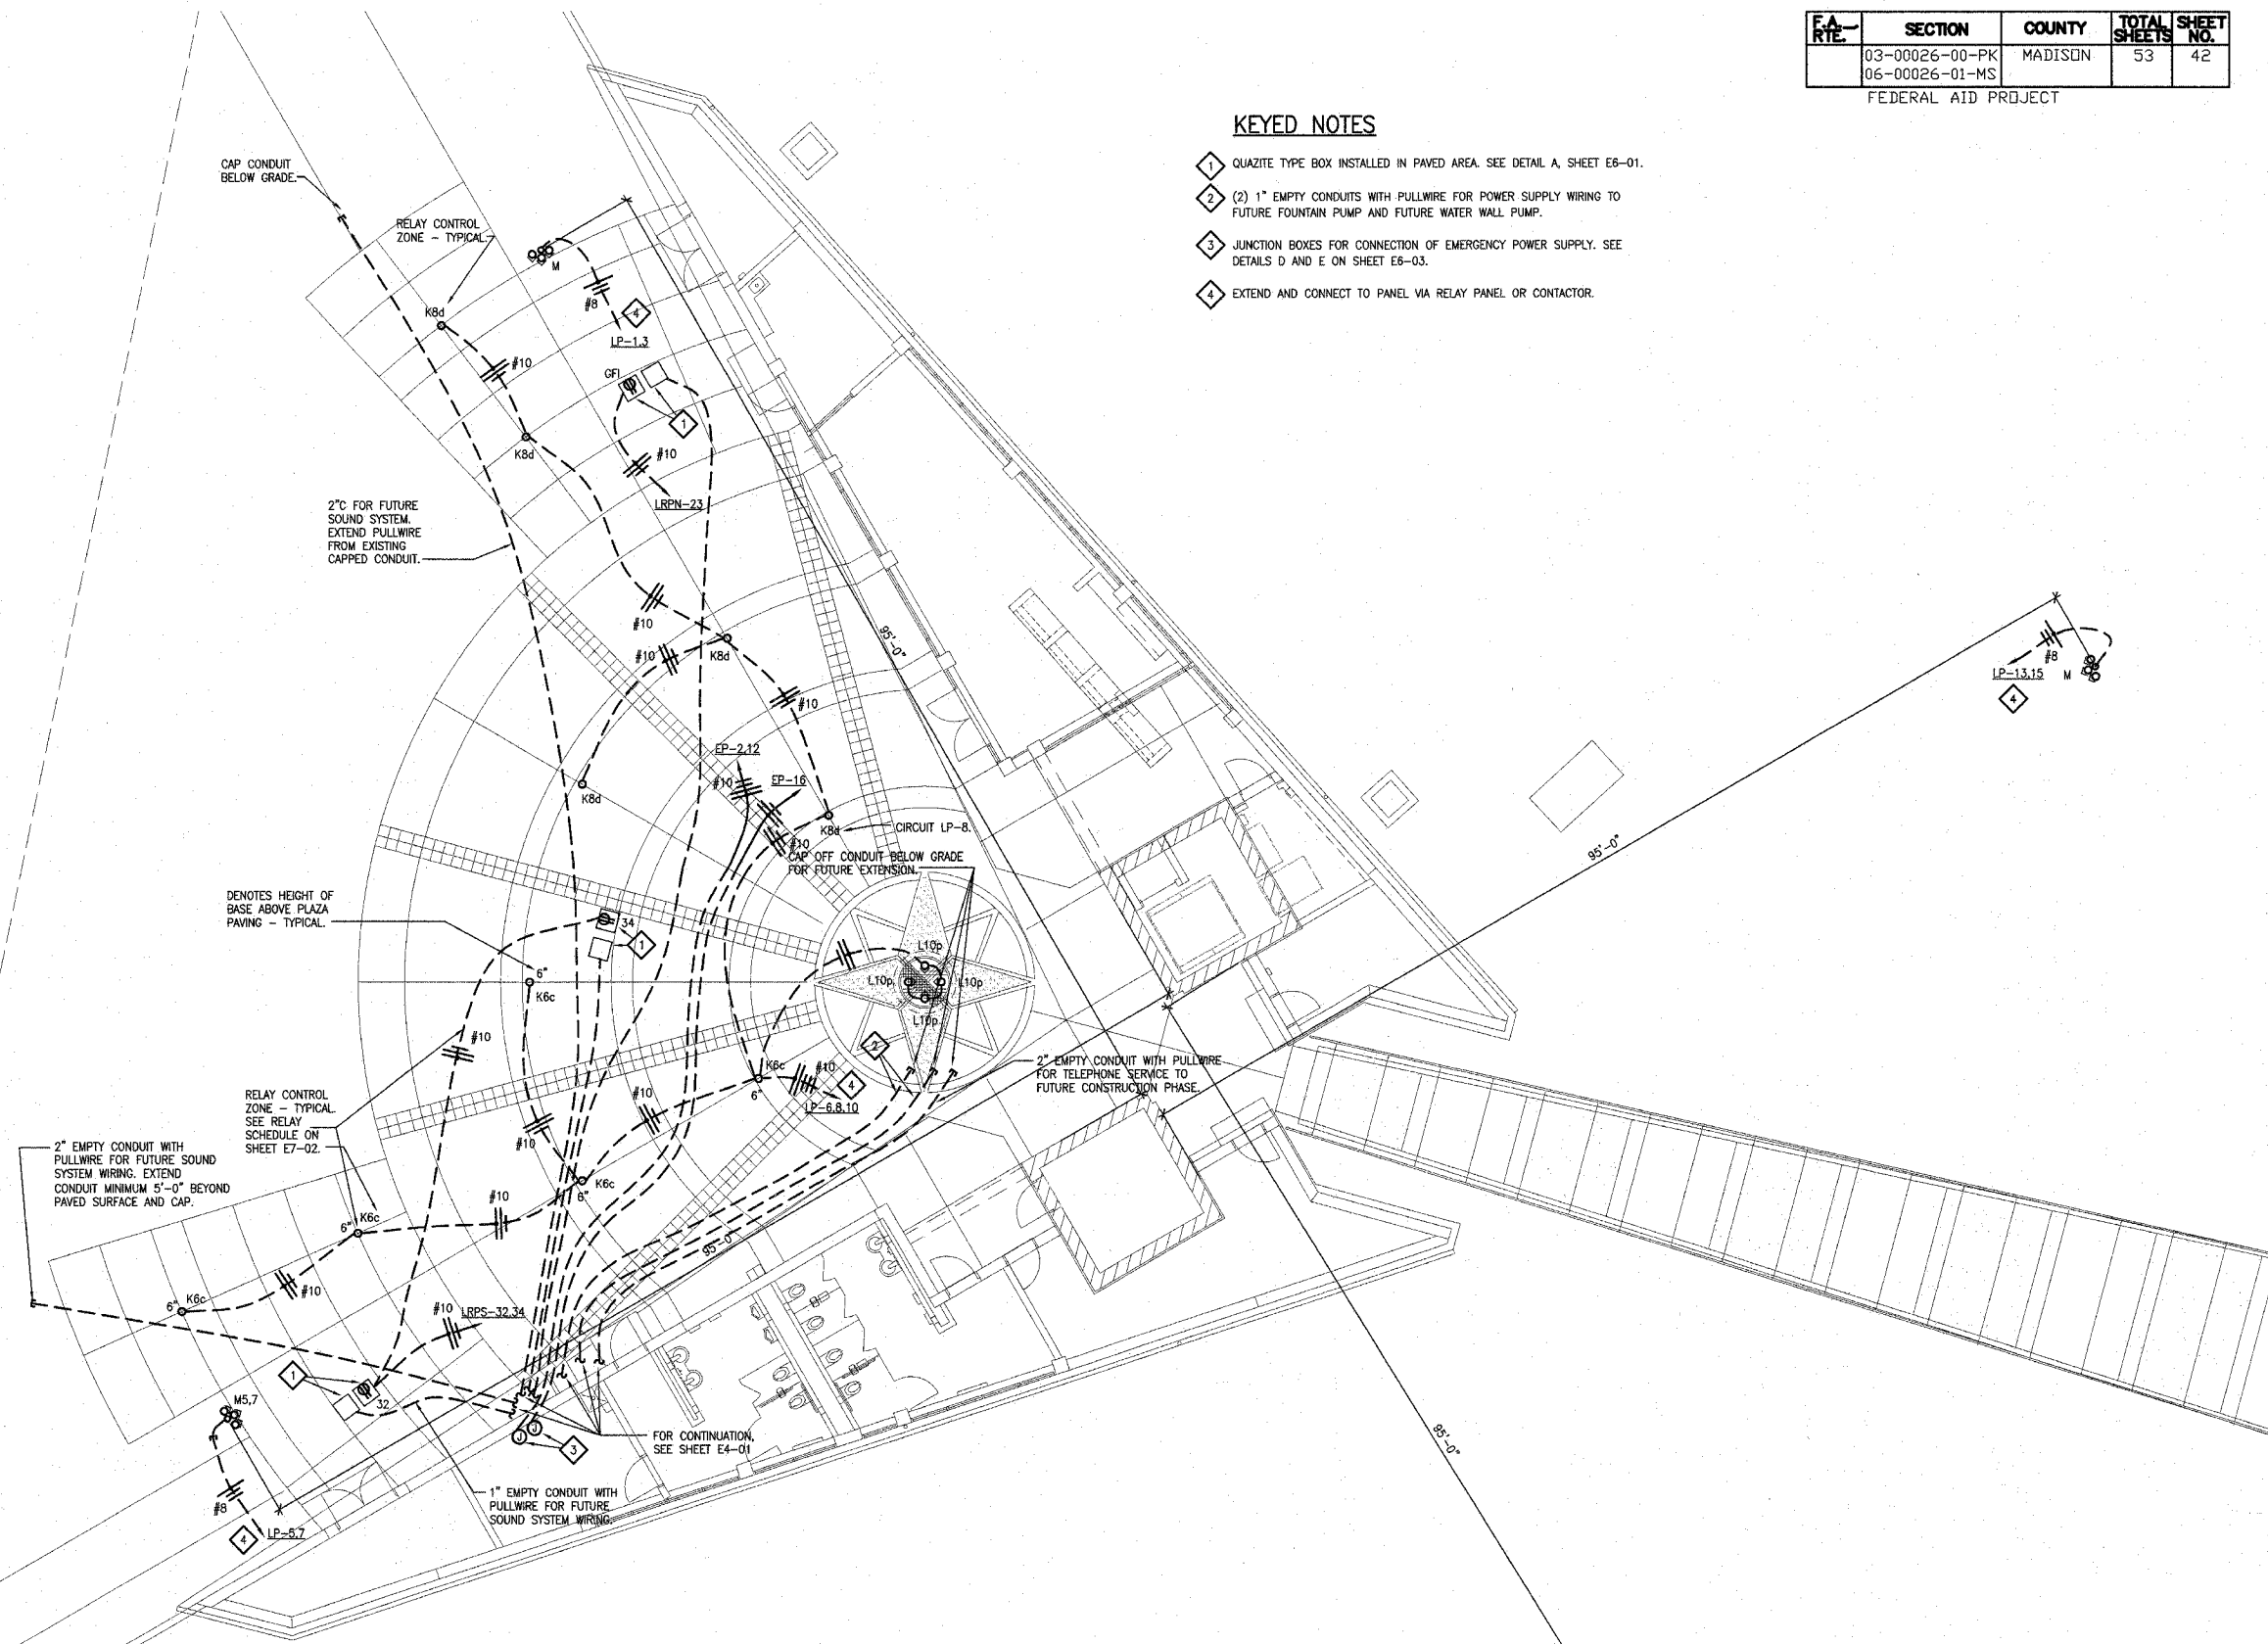

A PLAZA LIGHTING AND POWER PLAN
1/8"=1'-0"
0 4' 8' 16' 32'

