
 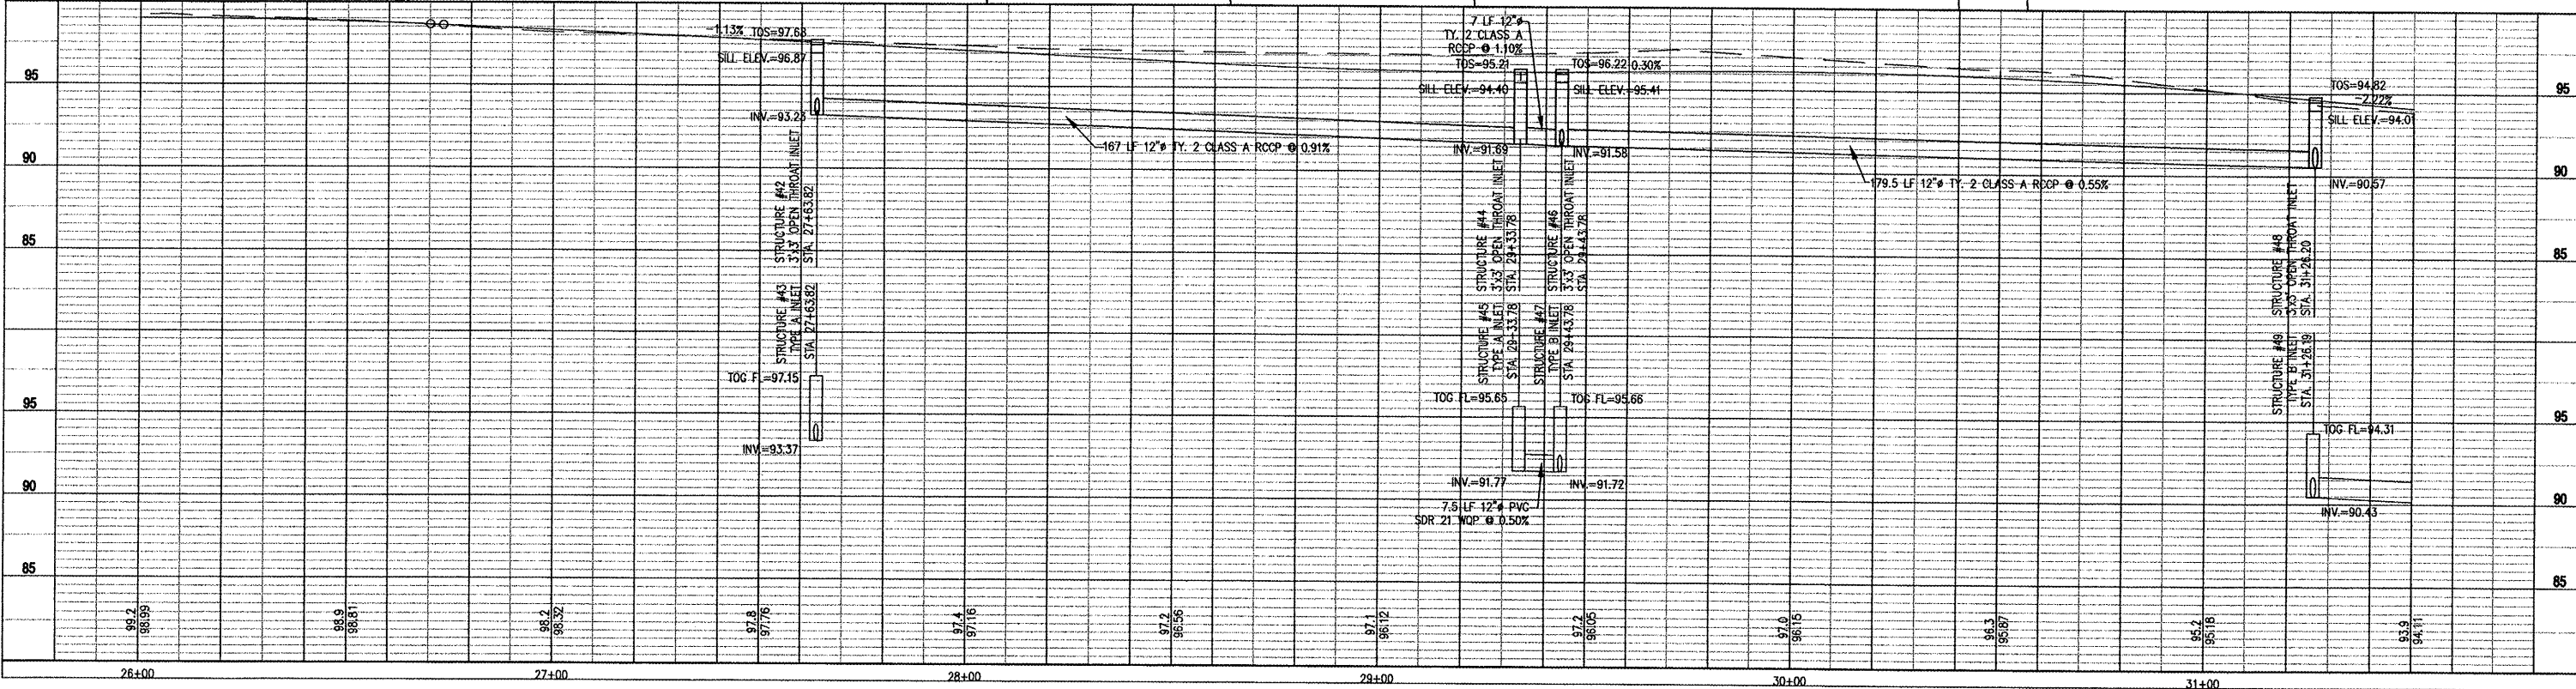



FBI ROUTE	SECTION	COUNTY	TOTAL SHEETS	SHEET NO.
9392	05-00024-00-PV	MADISON	81	27
STA. 26+00.00		TO STA. 31+50.00		
DRAINAGE PLAN AND PROFILE				

CONTRACT NO. 97347

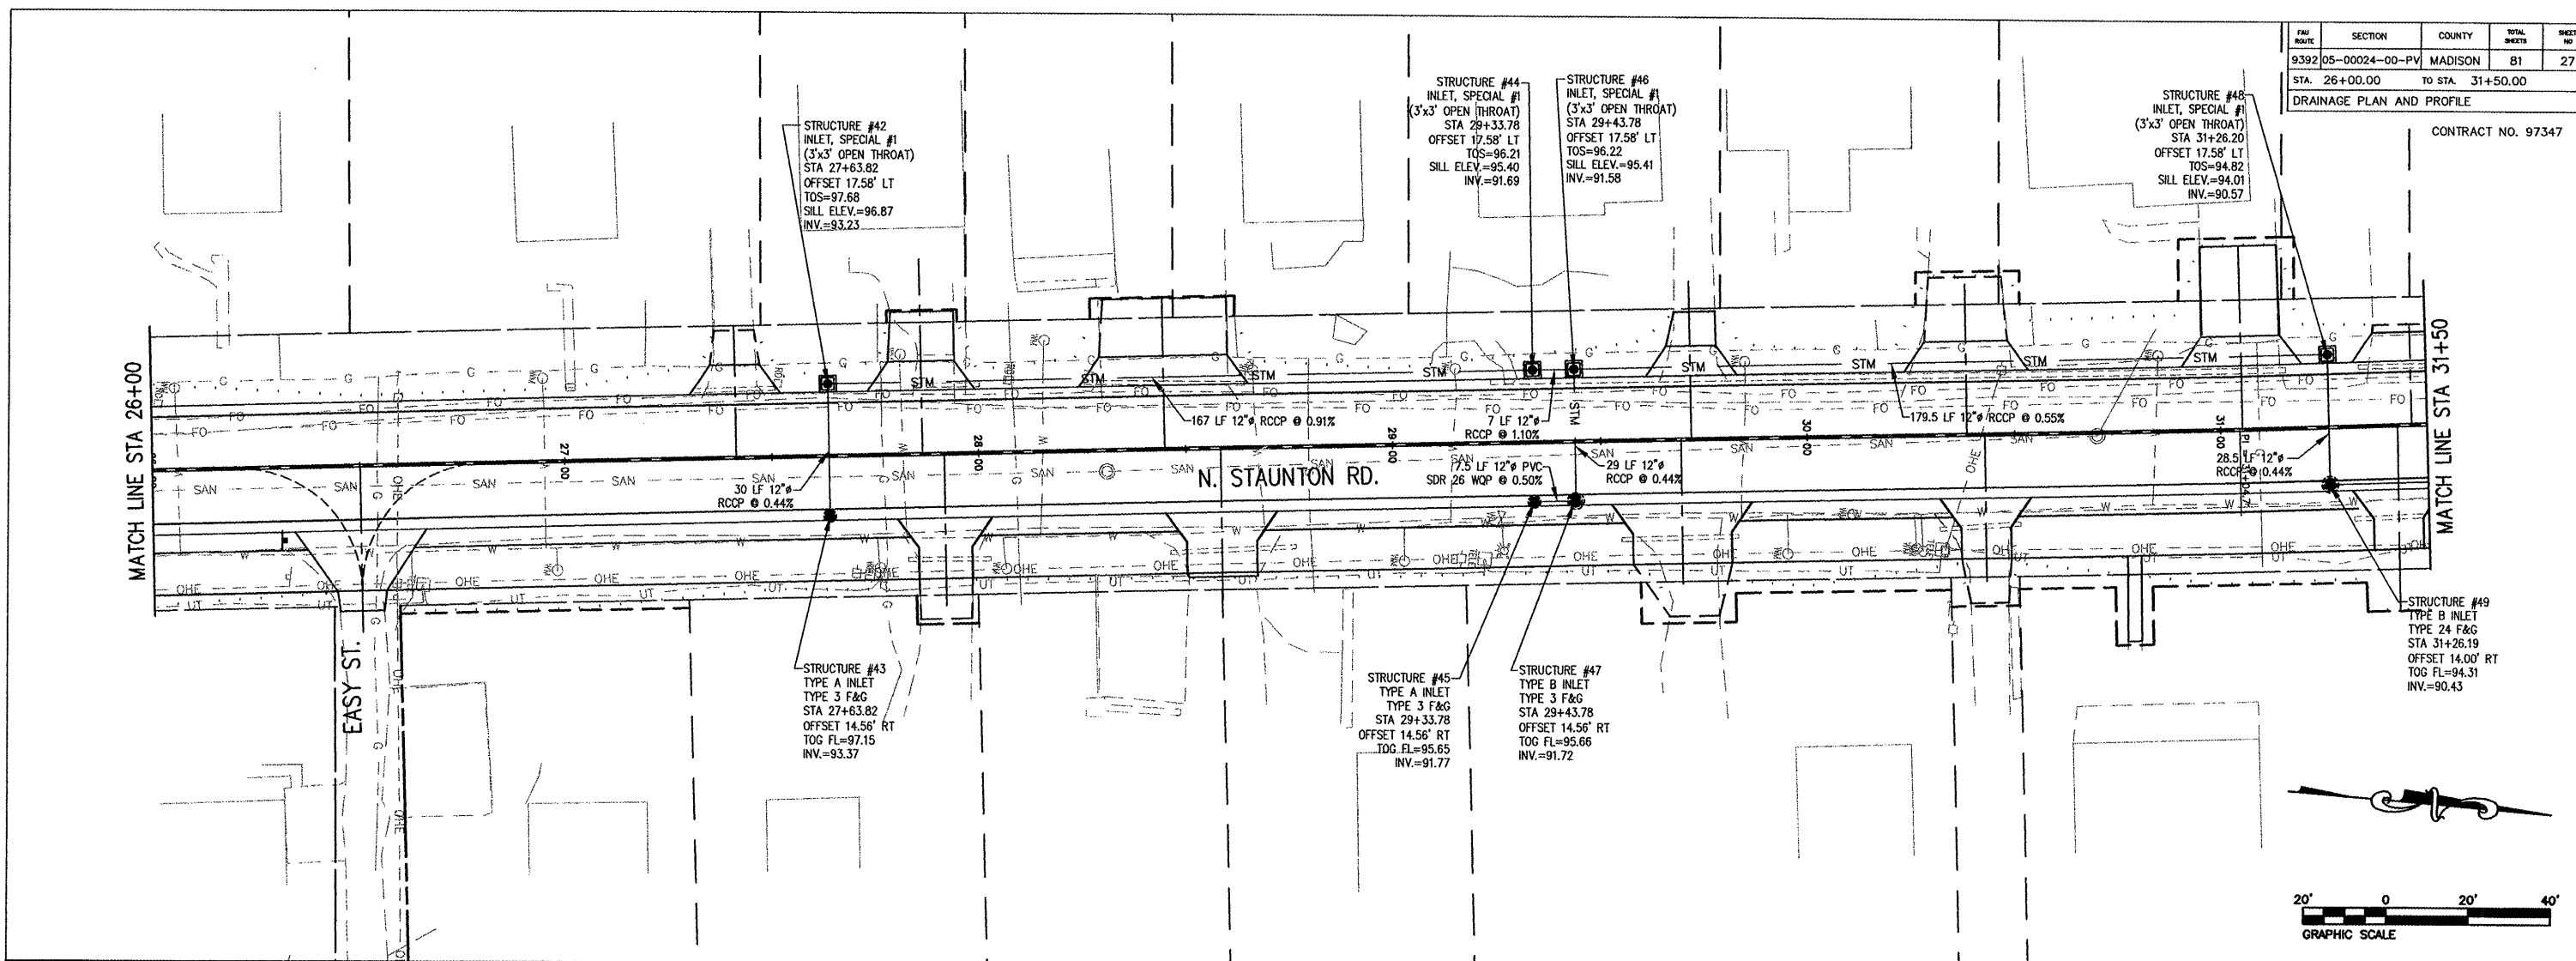

P:\030131\dwg\030131-PPSTORM.dwg 1/16/2008 11:27:19 AM CST