



APR 23, 2006 7:29 AM HAGL000362
 AIRPORTS\METROPOLIS\07A0128\CAD\SHEETS\R-141ELE.DWG - STA. 121+00 TO STA. 135+00

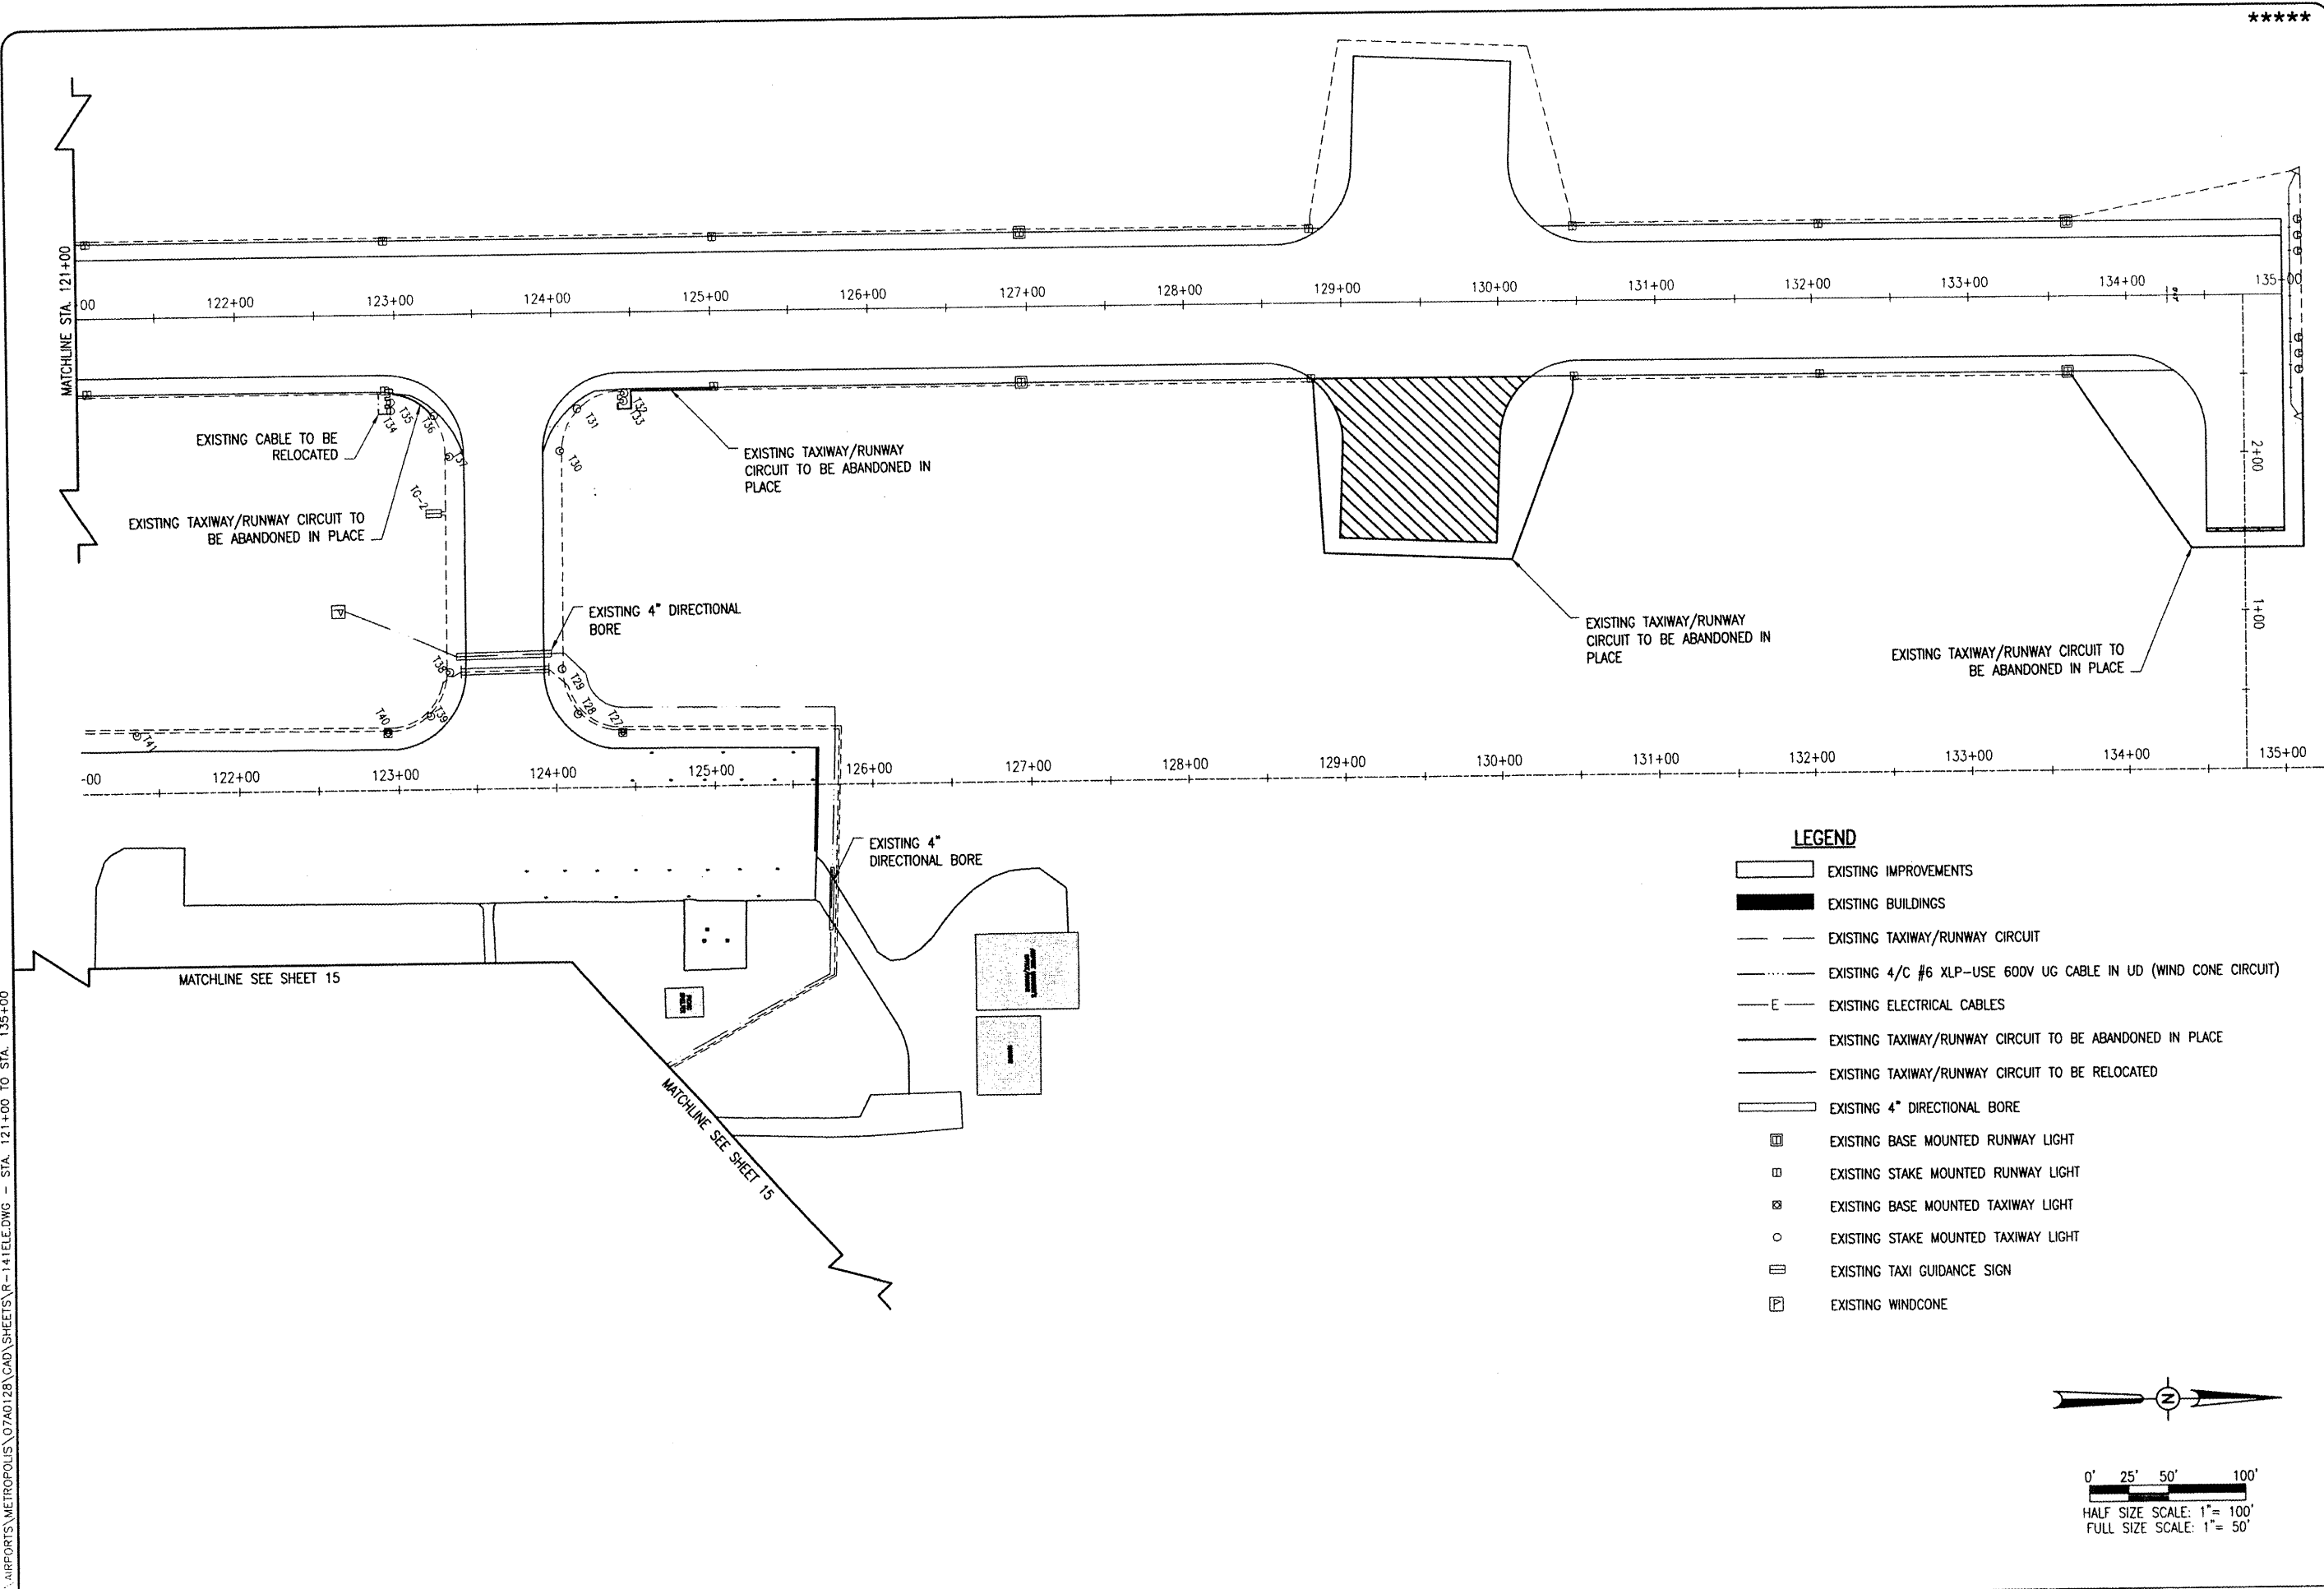

- LEGEND**
- EXISTING IMPROVEMENTS
 - EXISTING BUILDINGS
 - EXISTING TAXIWAY/RUNWAY CIRCUIT
 - EXISTING 4/C #6 XLP-USE 600V UG CABLE IN UD (WIND CONE CIRCUIT)
 - EXISTING ELECTRICAL CABLES
 - EXISTING TAXIWAY/RUNWAY CIRCUIT TO BE ABANDONED IN PLACE
 - EXISTING TAXIWAY/RUNWAY CIRCUIT TO BE RELOCATED
 -
 - EXISTING BASE MOUNTED RUNWAY LIGHT
 - EXISTING STAKE MOUNTED RUNWAY LIGHT
 - EXISTING BASE MOUNTED TAXIWAY LIGHT
 - EXISTING STAKE MOUNTED TAXIWAY LIGHT
 - EXISTING TAXI GUIDANCE SIGN
 - EXISTING WINDCONE

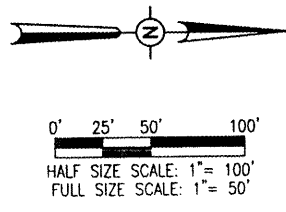

DATE	REVISION	BY

**METROPOLIS MUNICIPAL AIRPORT
 METROPOLIS, ILLINOIS**

IL. PROJ.: M30-3760 A.I.P. PROJ.: 3-17-0057-B9

HE Project No. 07A0128D.0800	03/04/08
Filename: R-141ELE.DWG	03/04/08
Scale: 1" = 50'	03/04/08
Date: 03/04/08	03/18/08
LAYOUT MDR	CAH
DRAWN MDR	
REVIEWED CAH	

HANSON

Hanson Professional Services Inc.
 1525 South Sixth Street
 Springfield, IL 62768
 Office: 618-266-8886

**PROPOSED PARTIAL
 PARALLEL TAXIWAY**

EXISTING
 ELECTRICAL PLAN
 STA. 121+00 TO STA. 135+00