
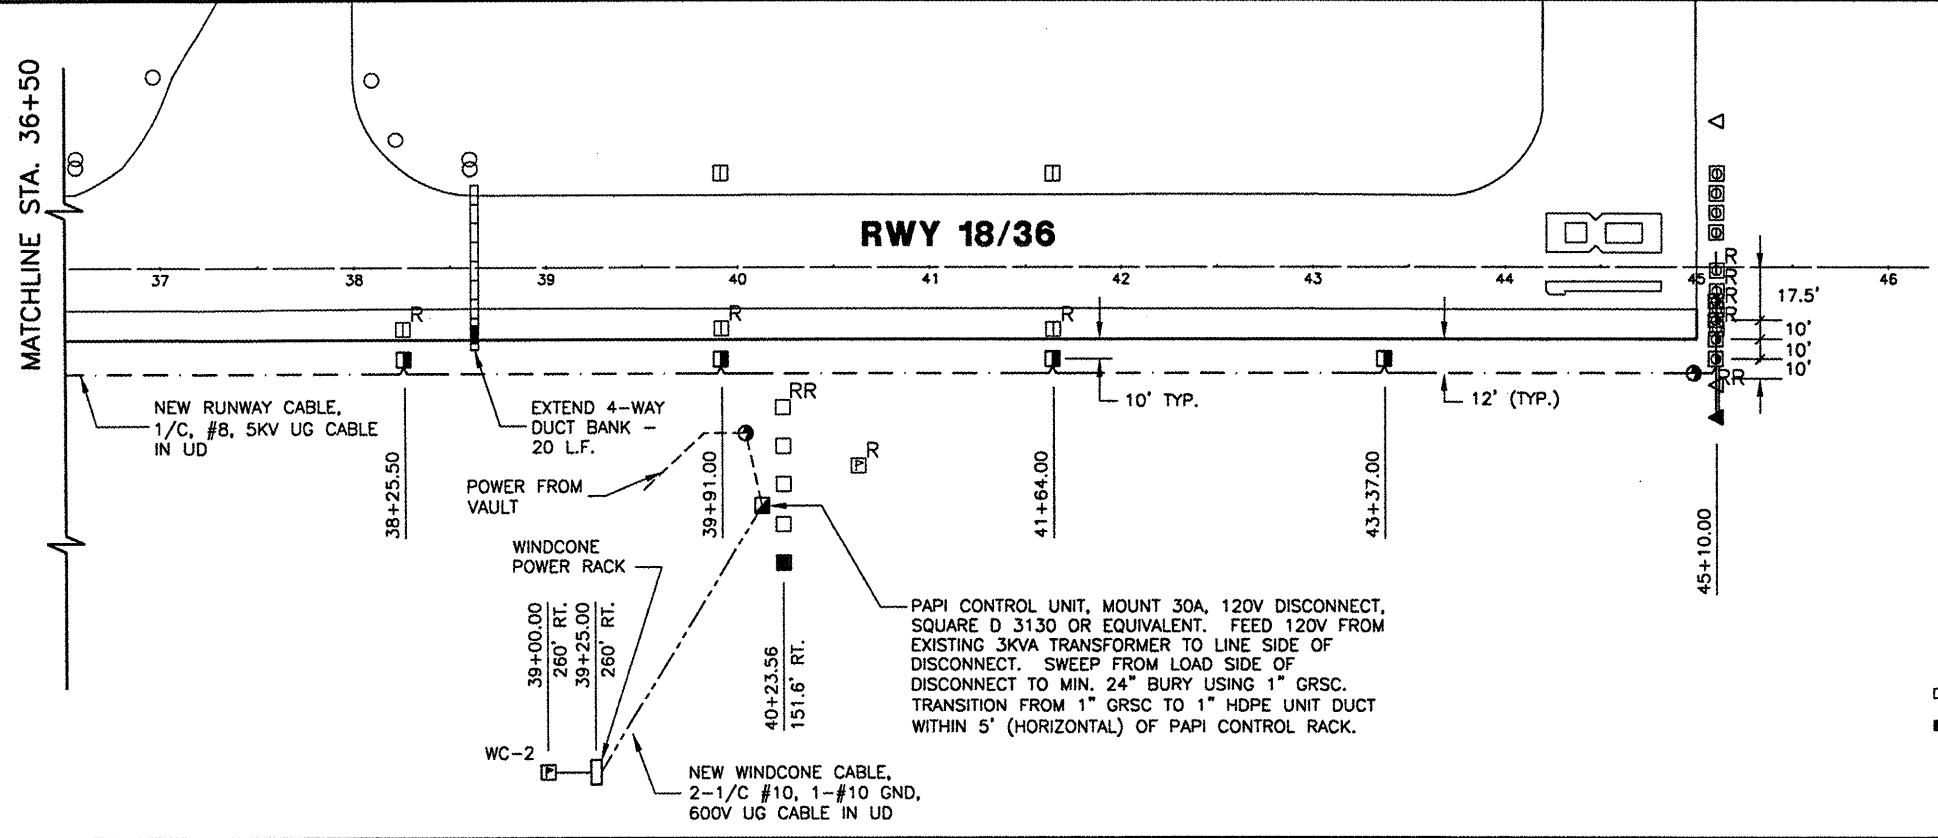
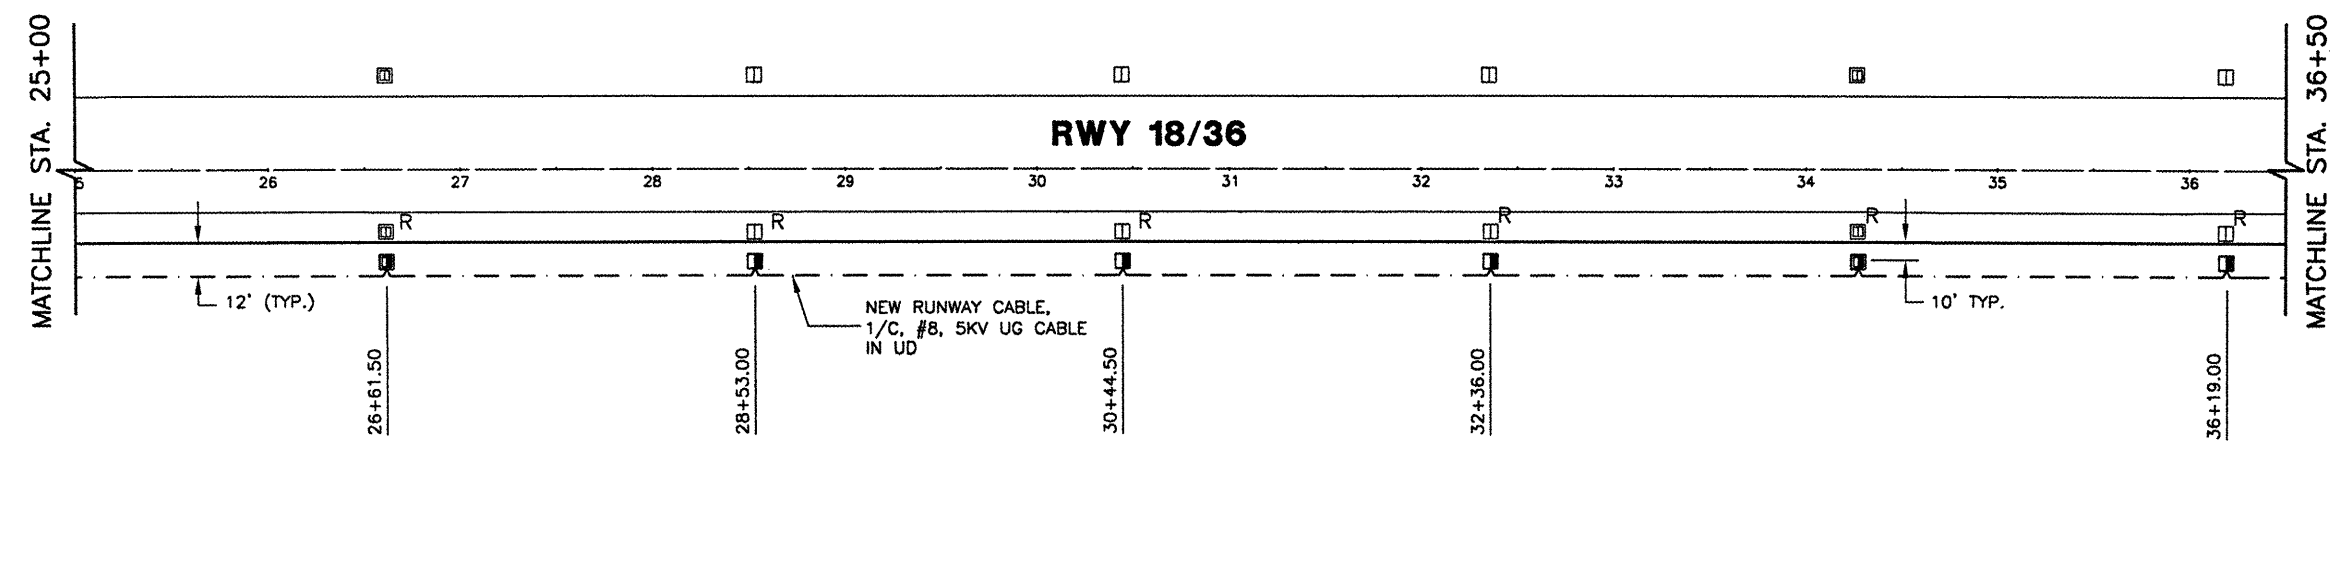
 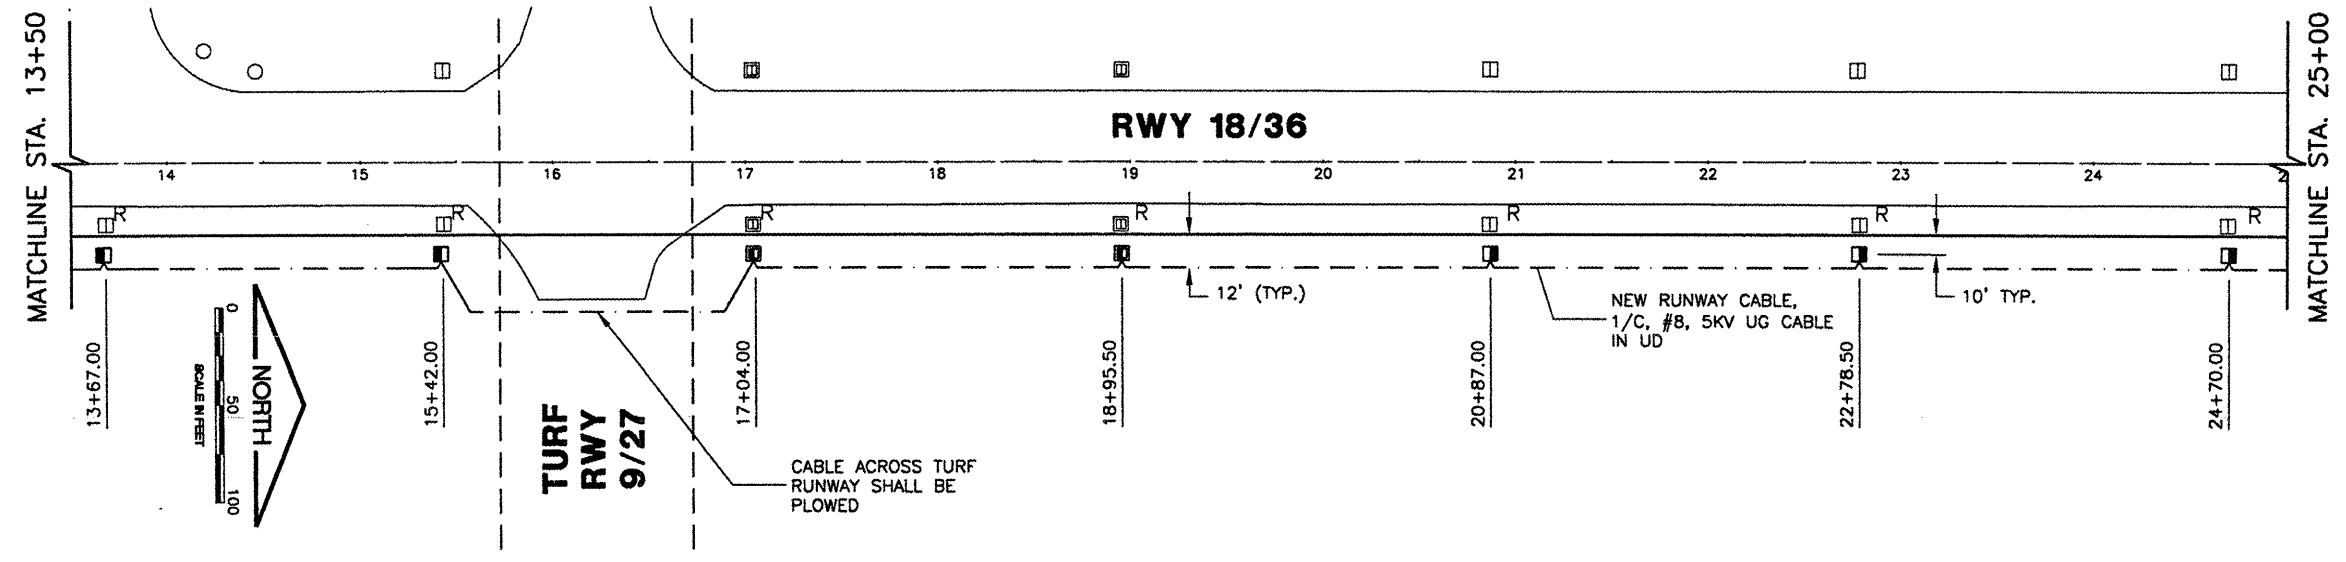


REVISIONS		
NUMBER	BY	DATE



NOTES
 1. AMBER/WHITE LENSES SHALL BE INSTALLED ON RUNWAY EDGE LIGHTS.

LEGEND			
□	EXISTING STAKE MOUNTED RWY. LIGHT	■	NEW STAKE MOUNTED RWY. LIGHT
■	EXISTING BASE MOUNTED RWY. LIGHT	■	NEW BASE MOUNTED RWY. LIGHT
⊠	EXISTING THRESHOLD LIGHT	⊠	NEW THRESHOLD LIGHT
⊠	EXISTING WINDCONE	■	RELOCATED PAPI CONTROL
□	EXISTING PAPI BOX	■	RELOCATED PAPI BOX
△	EXISTING REIL	▲	RELOCATED REIL
○	EXISTING STAKED MOUNTED TXY. LIGHT	●	SPLICE CAN
⊠	EXISTING BASE MOUNTED TXY. LIGHT	⊠	NEW WINDCONE
R	REMOVE	---	NEW RUNWAY CABLE, 1/C, #8, 5KV UG CABLE IN UD
---	EXISTING DUCT BANK	---	NEW WINDCONE CABLE, 3-1/C, #10, 600V UG CABLE IN UD
---	NEW DUCT BANK	RR	REMOVE AND RELOCATE

**SPARTA COMMUNITY AIRPORT
 HUNTER FIELD
 SPARTA, ILLINOIS**

**WIDEN AND OVERLAY RUNWAY 18/36
 ELECTRICAL & LIGHTING PLAN 2**

© Copyright CMT, Inc.
CMT
 CRAWFORD, MURPHY & TILLY, INC.
 CONSULTING ENGINEERS
 License No. 784-000610

DESIGN BY:	KLB
DRAWN BY:	CMT
CHECKED BY:	JEF
APPROVED BY:	JEF
DATE:	04/18/2008
JOB No:	0641203
IL PROJ. NO.	SAR-3652
AIP PROJ. NO.	3-17-0094-B9
SHEET 09 OF 28 SHEETS	