


- SUGGESTED SEQUENCE OF OPERATIONS:
1. REMOVE PAVEMENT AND UNSUITABLE MATERIAL IN EBL.
 2. CONSTRUCT COARSE AGGREGATE - REPLACEMENT AND HMA BASE COURSE 11"
 3. SWITCH TRAFFIC TO STAGE 2 AND REPEAT.

 PAVEMENT REMOVAL

REFER TO STD. 701502 FOR DETAILS NOT SHOWN.
REMOVE CONFLICTING PAVEMENT MARKINGS.

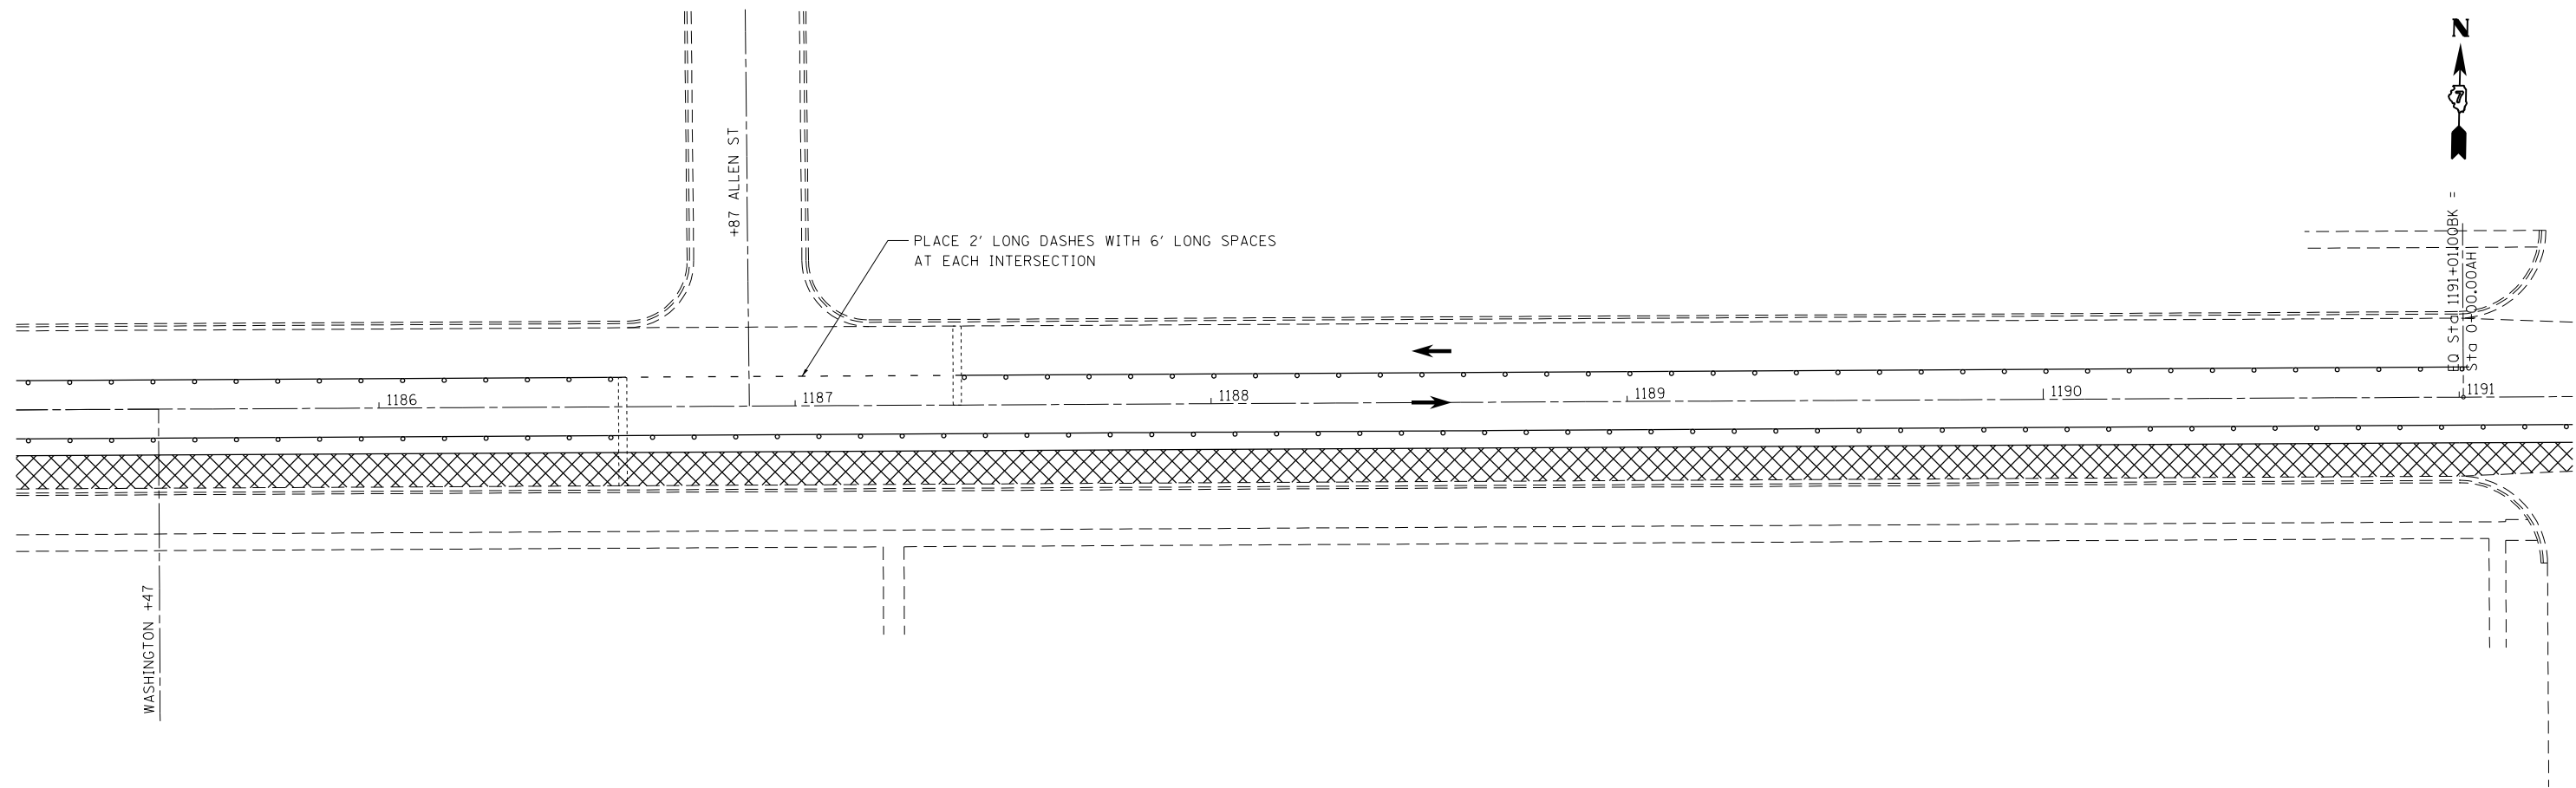

PLACE 2" LONG DASHES WITH 6' LONG SPACES
AT EACH INTERSECTION



FILE NAME =	USER NAME = steffenmk	DESIGNED -	REVISED -
ci:\pw\work\p\idot\stevfenmk\d0282300\074554-sht-stage1.dgn		DRAWN -	REVISED -
	PLOT SCALE = 40.0000' / in.	CHECKED -	REVISED -
	PLOT DATE = 4/5/2013	DATE -	REVISED -

**STATE OF ILLINOIS
DEPARTMENT OF TRANSPORTATION**

**STAGE 1 CONSTRUCTION DETAILS
STA 1179+00 TO STA 1191+00**

SCALE: 20 SHEET 1 OF 5 SHEETS STA. TO STA.

F.A.P. RTE.	SECTION	COUNTY	TOTAL SHEETS	SHEET NO.
781	(1Z,17Z)RS-1	CRAWFORD	60	20
CONTRACT NO. 74554			ILLINOIS FED. AID PROJECT	