


**NOTES:**

1. REFER TO DRAWING E6 FOR LUMINAIRE AND CONDUIT MOUNTING DETAILS.
2. 400W HPS LUMINAIRES TO BE ALIGNED ON OPPOSITE WALLS.
3. REFER TO DRAWING E-6 FOR ILLUMINANCE MOUNTING DETAIL.
4. REFER TO DRAWING E-1 FOR CONDUIT/CABLE TAGS.

**LEGEND:**

- HPS DAYLIGHT UNDERPASS LUMINAIRE, 400W
- HPS NIGHTLIGHT UNDERPASS LUMINAIRE, 70W

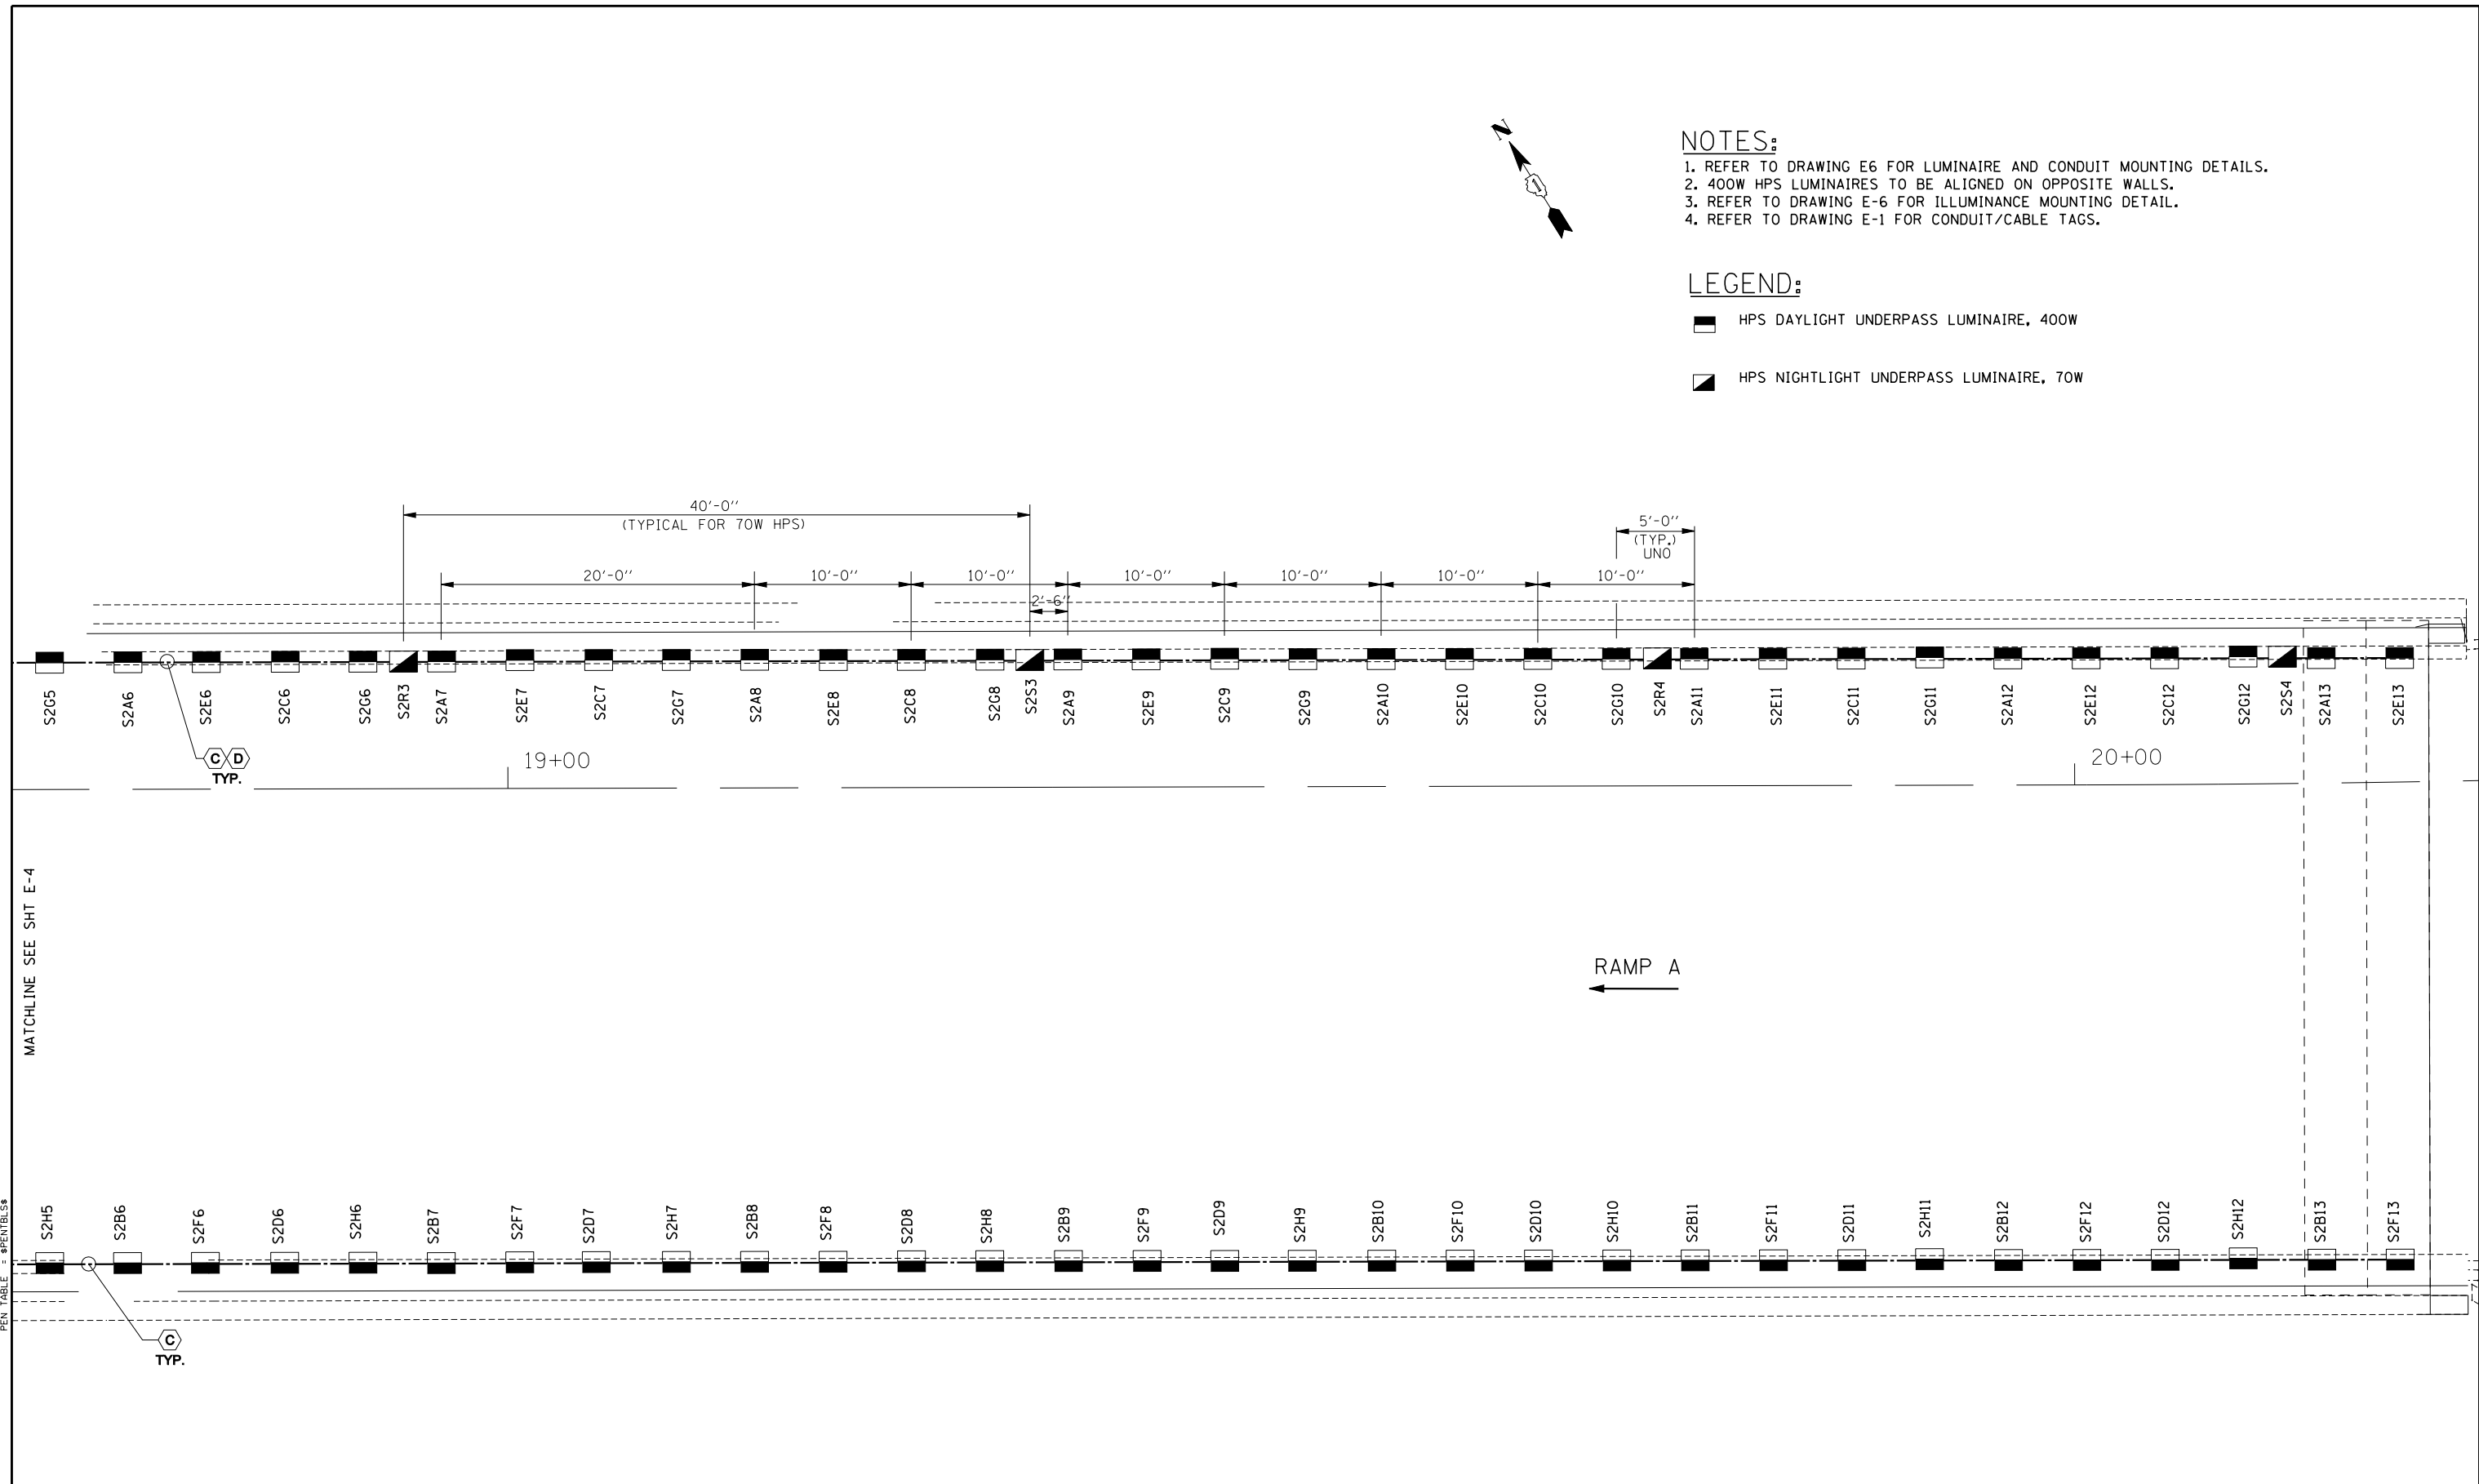

MATCHLINE SEE SHT E-4

RAMP A  
←

PEN TABLE = #PENTBL5\$

**SPAAN Tech, Inc.**  
 311 S. Wacker Drive, Suite 2400 Chicago, IL 60606  
 312.277.8800 312.277.8828  
 www.spaan-tech.com

**COLLINS ENGINEERS**

USER NAME = \$USER\$	DESIGNED - IAB	REVISED -
PLOT SCALE = \$SCALE\$	DRAWN - DL/TM	REVISED -
PLOT DATE = \$DATE\$	CHECKED - YK	REVISED -
PLOT DRIVER = \$PLTDV\$	DATE - DEC 2012	REVISED -

**STATE OF ILLINOIS  
DEPARTMENT OF TRANSPORTATION**

**I-9094 AT OHIO STREET  
UNDERPASS LIGHTING PLAN - PROPOSED**

SCALE: 1" = 10' SHEET NO. OF SHEETS STA. TO STA.

F.A.I. RTE. 90/94	SECTION 0303-474HB-R	COUNTY COOK	TOTAL SHEETS 368	SHEET NO. 166
CONTRACT NO. 60F63				
FED. ROAD DIST. NO. 1 ILLINOIS FED. AID PROJECT				