



WORK LIMIT
 CONTRACT 60R31
 STA. 4045+00 (IL59)

BEGIN WORK
 CONTRACT 60I31
 STA. 4045+00 (IL59)
 STA. 906+99.34 (IL59 NB)
 STA. 807+01 (IL59 SB)

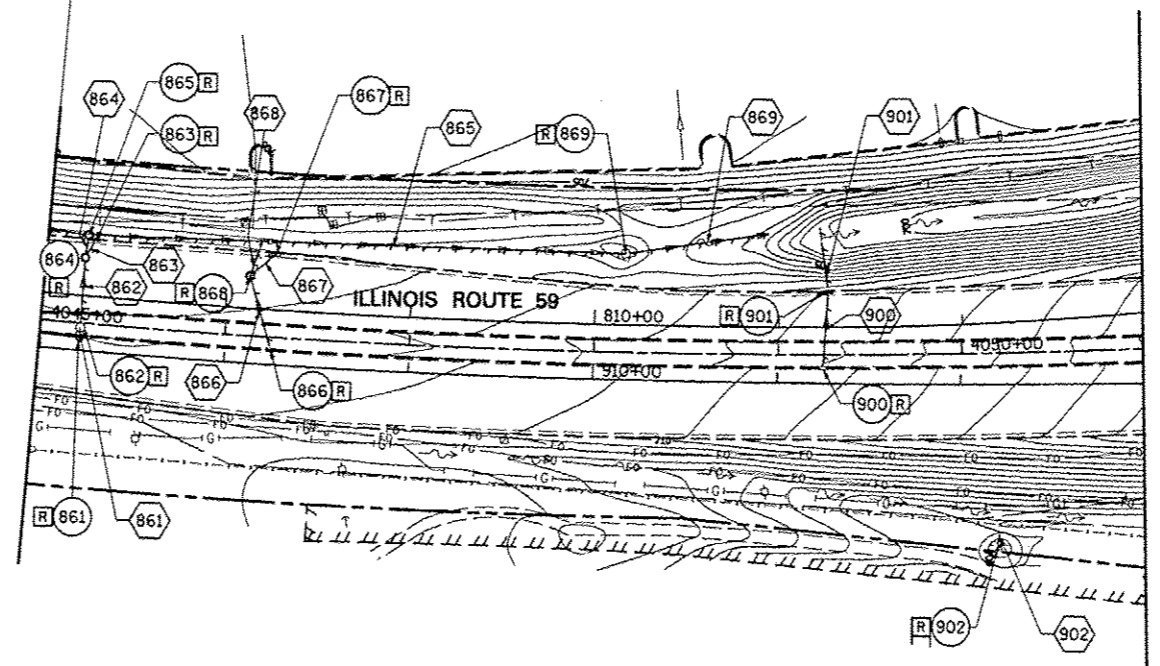

MATCH LINE STA. 913+00 (NB)
 SEE DRAWING DE-02

NOTE:
 1. SEE DRAWING DN-01 FOR EXISTING DRAINAGE LEGEND.

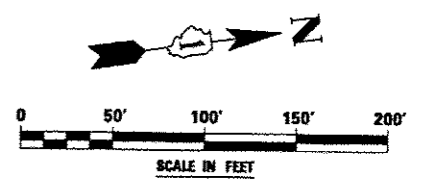

FILE NAME :	USER NAME : #USER#	DESIGNED <i>PJO</i>	REVISED -	STATE OF ILLINOIS DEPARTMENT OF TRANSPORTATION	EXISTING DRAINAGE PLAN - ILLINOIS ROUTE 59	F.A.P. RTE.	SECTION	COUNTY	TOTAL SHEETS	SHEET NO.	
#FILE#		DRAWN <i>KES</i>	REVISED -			338	(112 & 113) WRS-5	DUPAGE	963	328	
		CHECKED <i>JCM</i>	REVISED -			DE-01		CONTRACT NO. 60I31			
		DATE <i>10/15/2012</i>	REVISED -			ILLINOIS FED. AID PROJECT					
					SCALE: 1"=50'	SHEET NO. 1 OF 10 SHEETS		STA. 906+99.34 TO STA. 913+00			