



MATCH LINE STA. 937+00 (NB)
SEE DRAWING DE-03

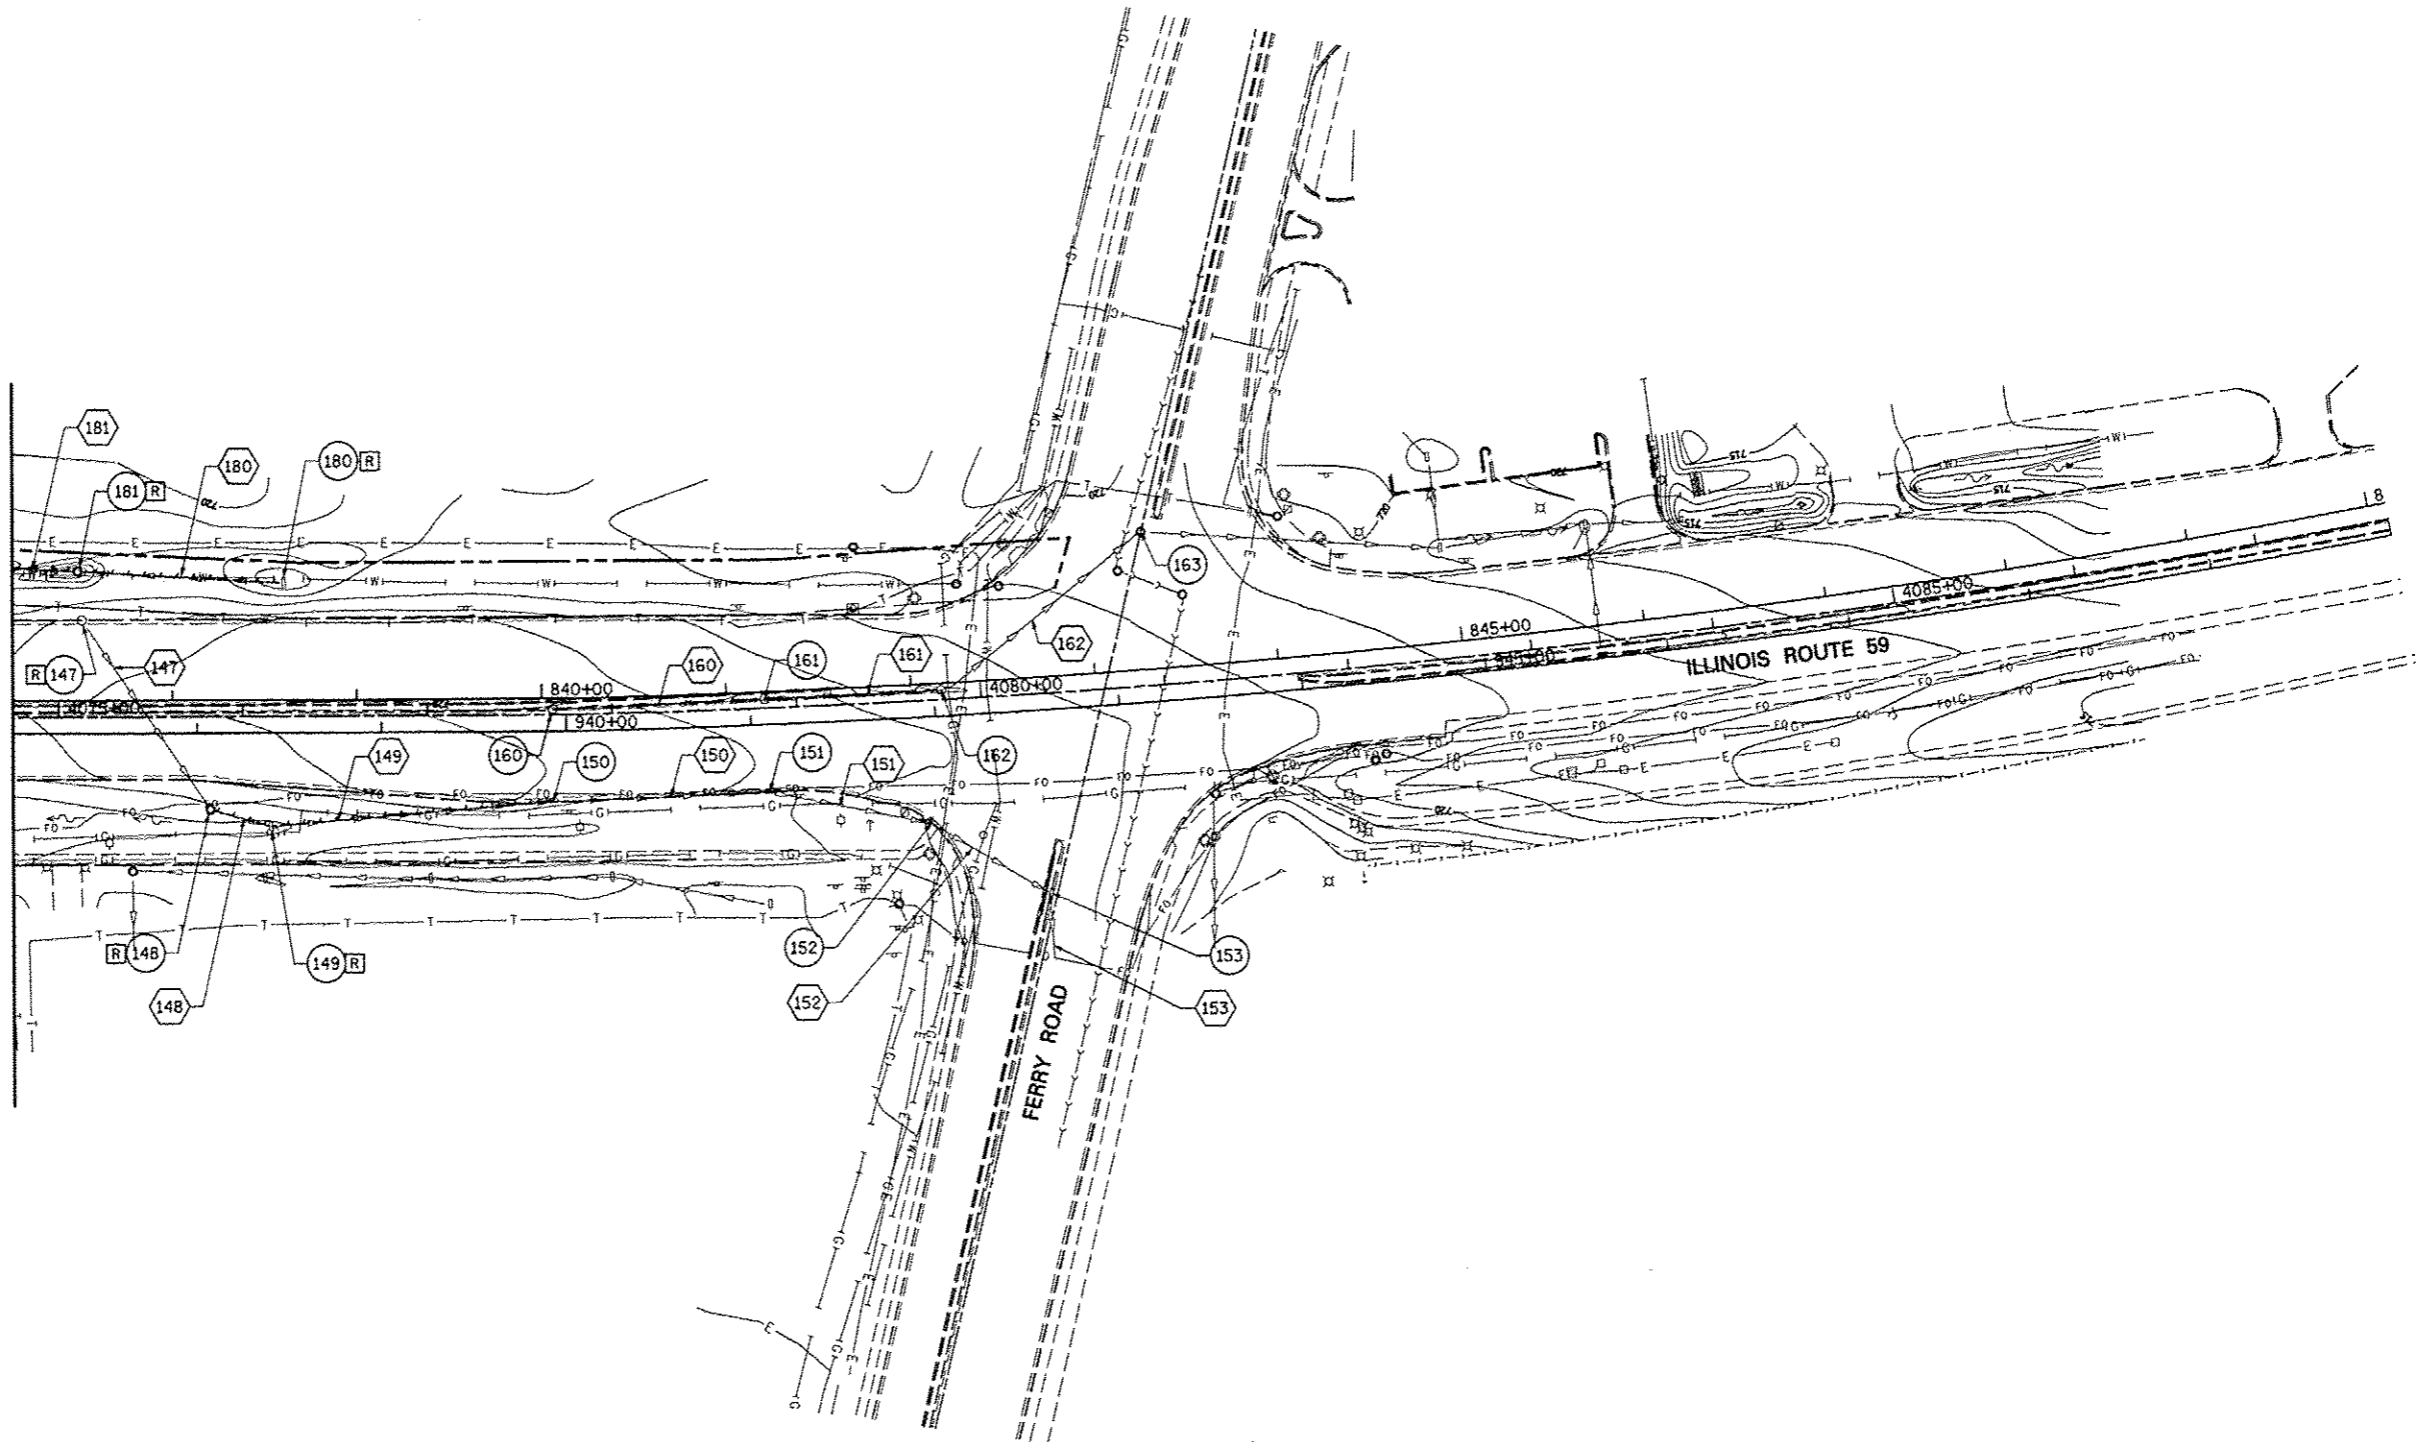

NOTE:
1. SEE DRAWING DN-01 FOR EXISTING DRAINAGE LEGEND.

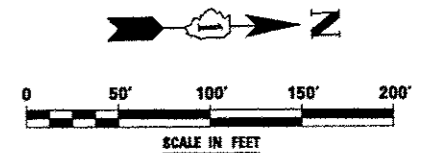

FILE NAME : *FILE*	USER NAME : *USER*	DESIGNED <i>PJO</i>	REVISED -	STATE OF ILLINOIS DEPARTMENT OF TRANSPORTATION	EXISTING DRAINAGE PLAN - ILLINOIS ROUTE 59				F.A.P. RTE.	SECTION	COUNTY	TOTAL SHEETS	SHEET NO.
	DRAWN <i>KES</i>	CHECKED <i>JCM</i>	DATE <i>10/15/2012</i>						REVISED -	33B	(112 & 113) WRS-5	DUPAGE	963
	PLOT SCALE : *SCALE*	DATE	REVISED -		SCALE: 1"=50'	SHEET NO. 4 OF 10 SHEETS	STA. 937+00 TO STA. END	DE-04		CONTRACT NO. 60131			
	PLOT DATE : *DATE*	REVISED -			ILLINOIS FED. AID PROJECT								