



MATCH LINE STA. 8975+00
SEE BELOW

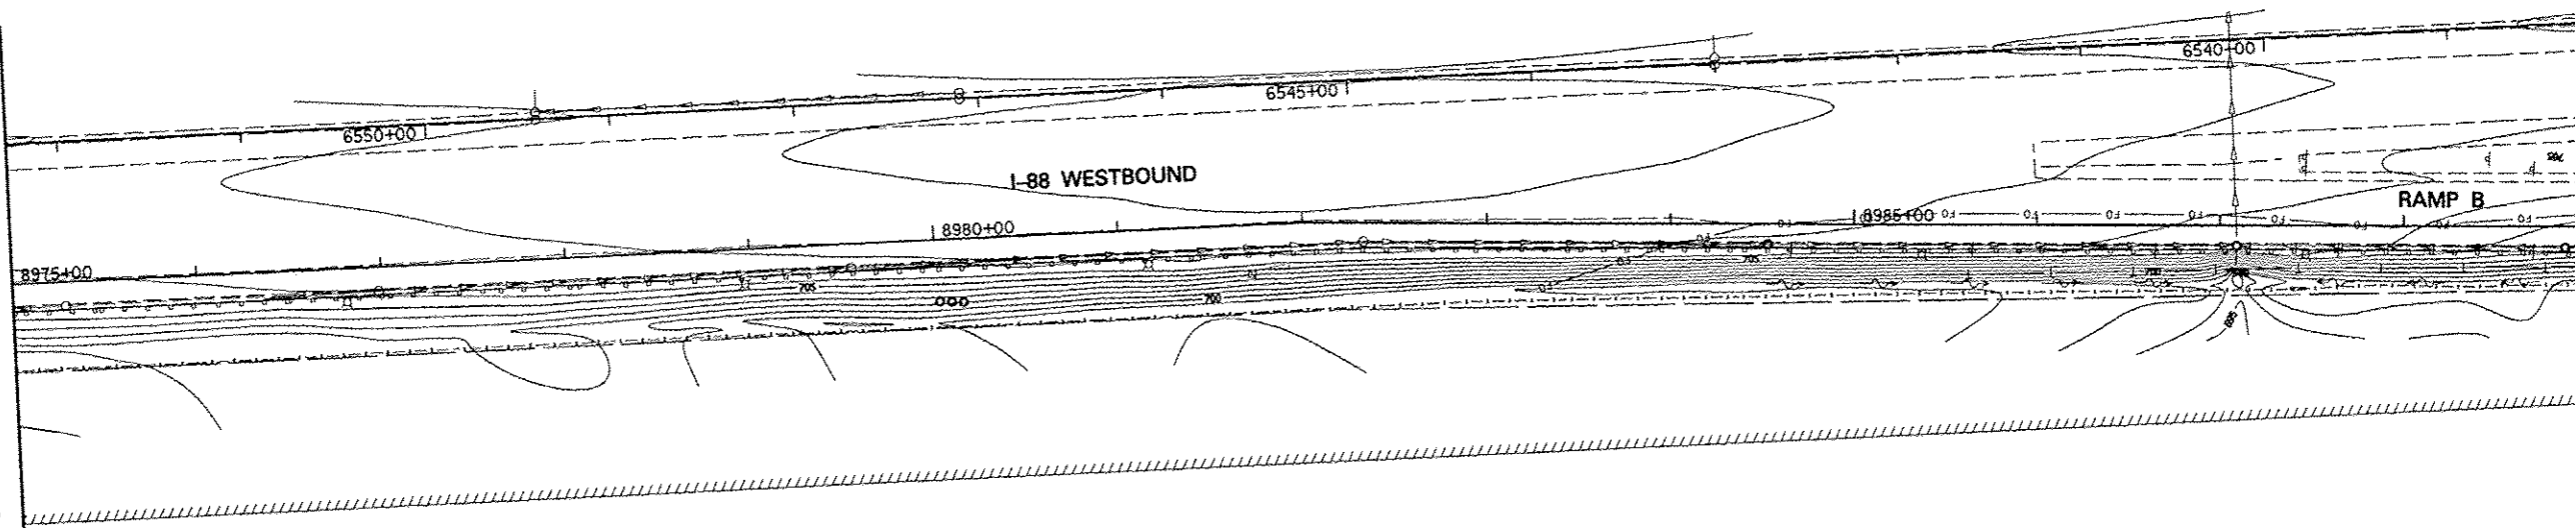

MATCH LINE STA. 8989+00
SEE DRAWING DE-07

MATCH LINE STA. 8975+00
SEE ABOVE

 NOTE:
1. SEE DRAWING DN-01 FOR EXISTING DRAINAGE LEGEND.



FILE NAME =	USER NAME = #USER#	DESIGNED <i>PJO</i>	REVISED -	STATE OF ILLINOIS DEPARTMENT OF TRANSPORTATION	EXISTING DRAINAGE PLAN - RAMP B	F.A.P. RTE.	SECTION	COUNTY	TOTAL SHEETS	SHEET NO.
#FILE#		DRAWN <i>KES</i>	REVISED -			338	(112 & 113) WRS-5	DUPAGE	963	333
		CHECKED <i>JCM</i>	REVISED -			DE-06		CONTRACT NO. 60131		
		DATE <i>10/15/2012</i>	REVISED -			ILLINOIS FED. AID PROJECT				
				SCALE: 1"=50'	SHEET NO. 6 OF 10 SHEETS	STA. BEGIN	TO STA.	8989+00		