 




DATE	
BY	
DESIGNED	
DRAWN	
CHECKED	
DATE	
NO.	

DATE	
BY	
DESIGNED	
DRAWN	
CHECKED	
DATE	
NO.	

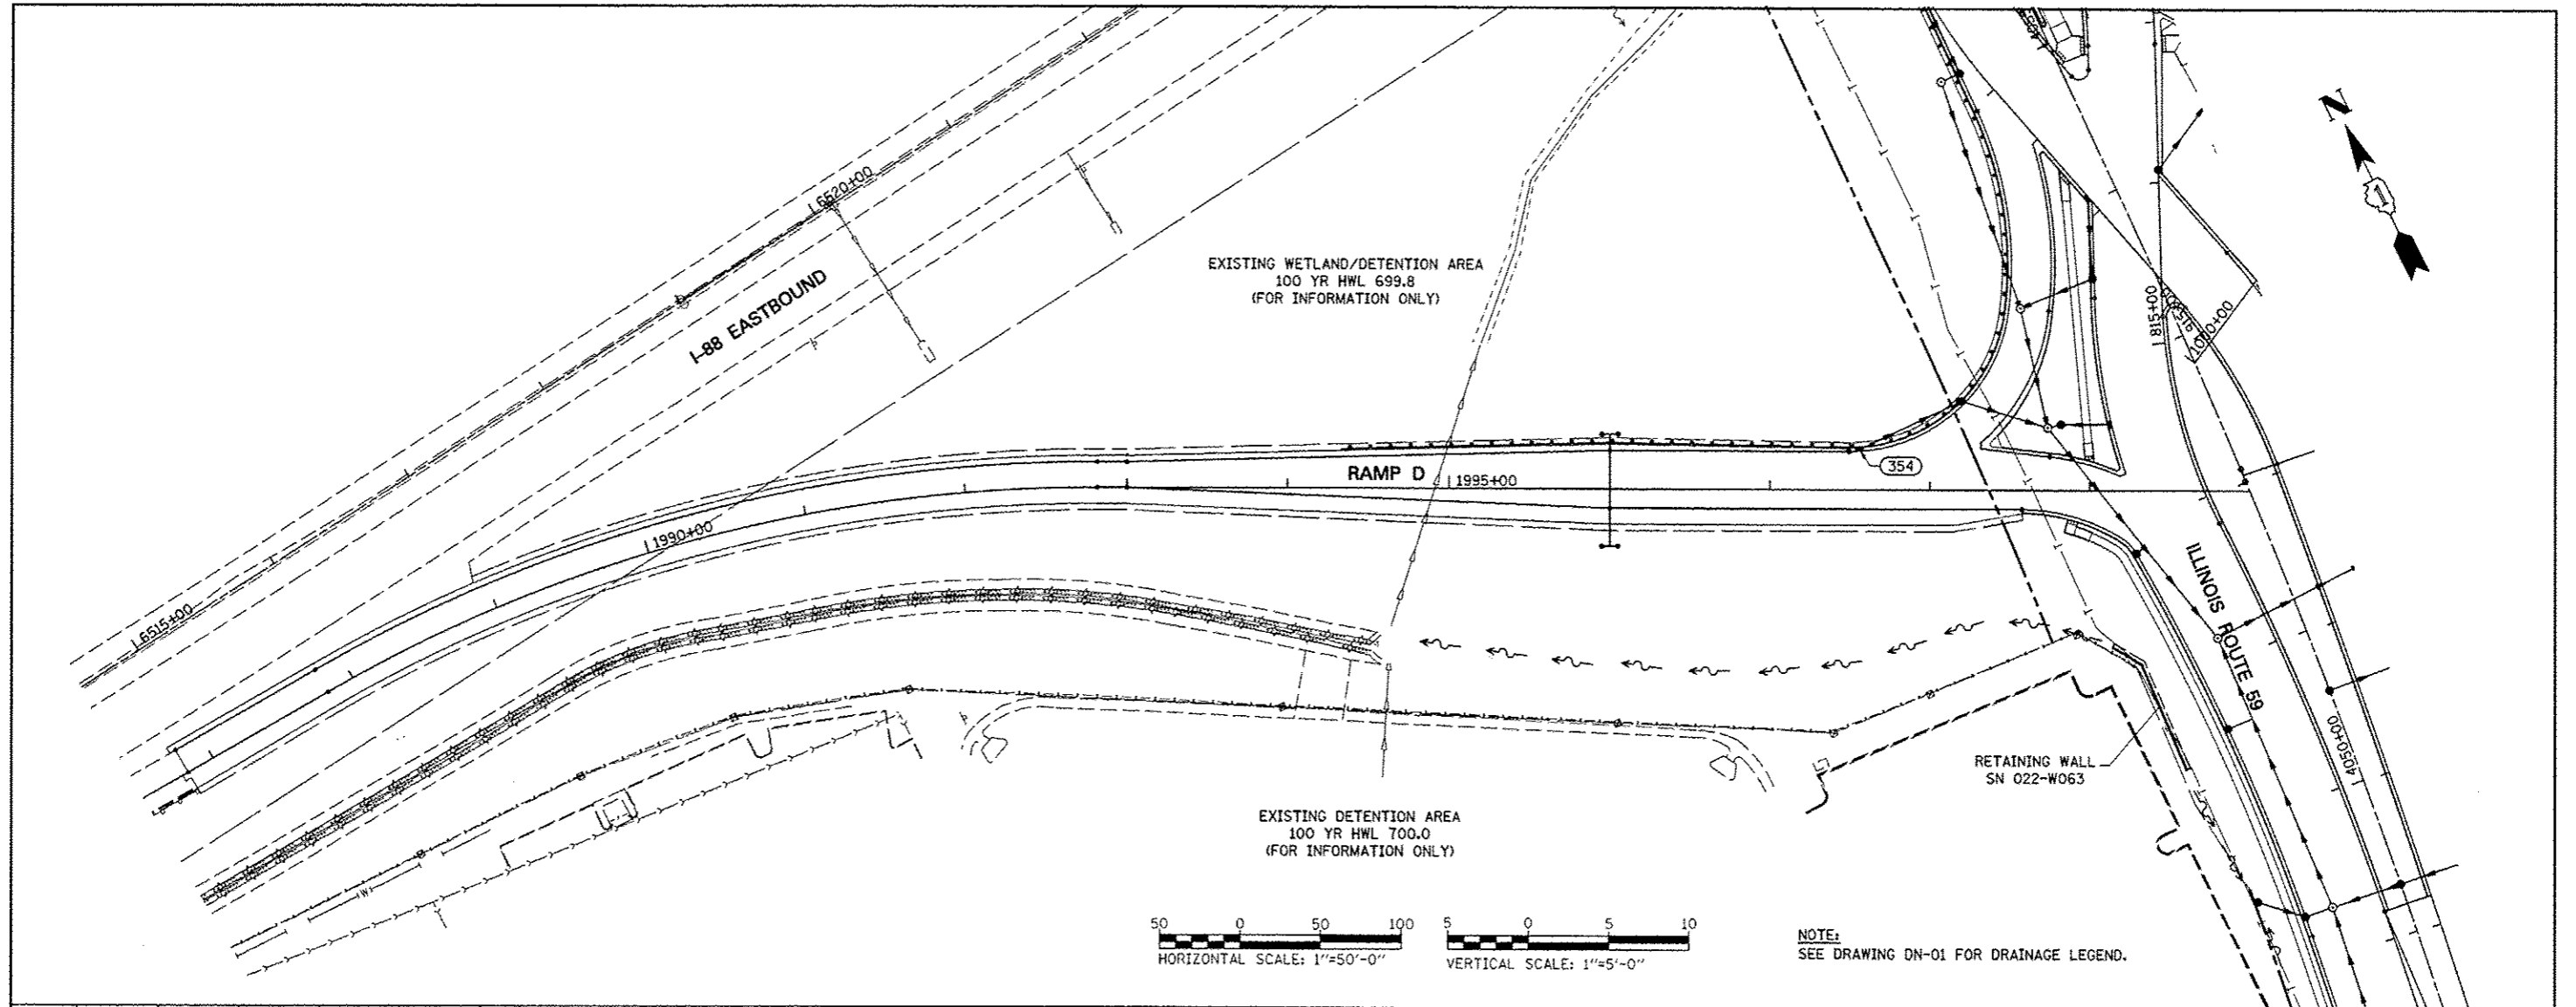

NOTE:
SEE DRAWING DN-01 FOR DRAINAGE LEGEND.

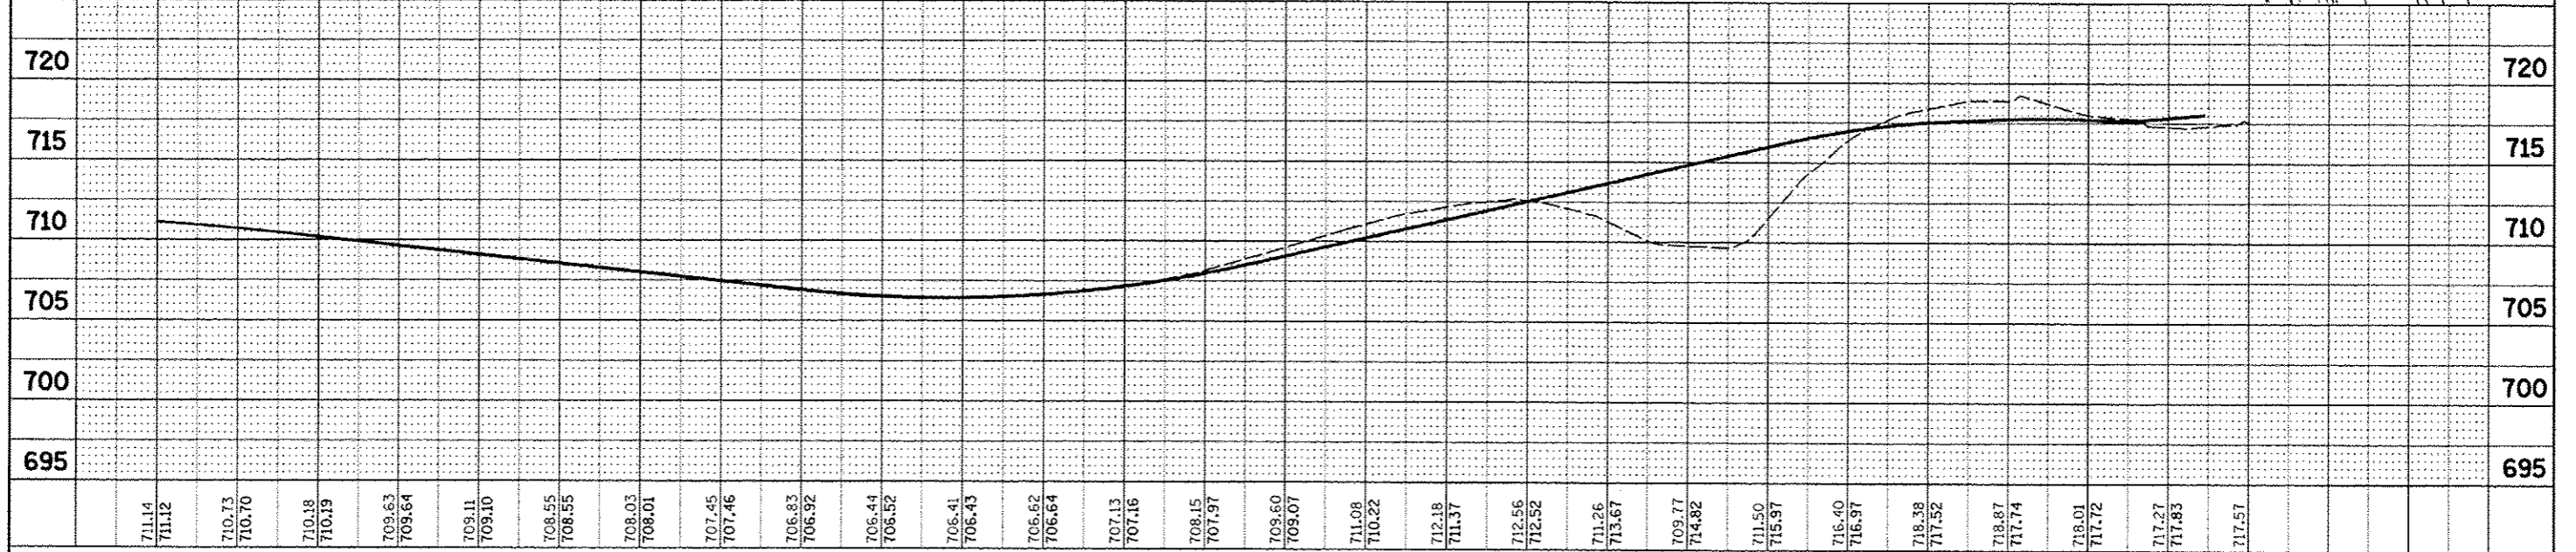

FILE NAME =	USER NAME = #USER#	DESIGNED <i>JWM</i>	REVISED -	STATE OF ILLINOIS DEPARTMENT OF TRANSPORTATION	PROPOSED DRAINAGE PLAN & PROFILE - RAMP D	F.A.P. RYE,	SECTION	COUNTY	TOTAL SHEETS	SHEET NO.	
#FILE#		DRAWN <i>KES</i>	REVISED -			33B	(112 & 113) WRS-5	DUPAGE	963	349	
PLOT SCALE = #SCALE#		CHECKED <i>JRS</i>	REVISED -			DP-12					
PLOT DATE = #DATE#		DATE <i>10/15/2012</i>	REVISED -			CONTRACT NO. 60131					
				SCALE: 1"=50'		SHEET NO. 12 OF 12 SHEETS		STA. BEGIN TO STA. 2000+00		FED. ROAD DIST. NO. ILLINOIS FED. AID PROJECT	