


SIGN DETAIL
1:75

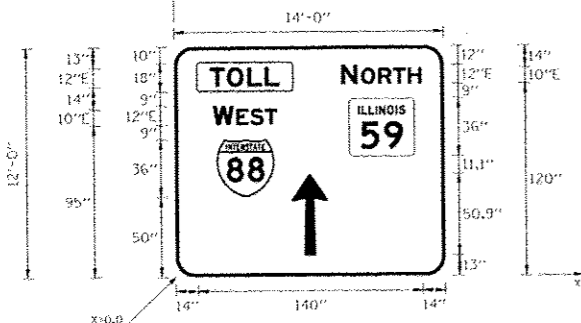

SIGN NUMBER	NB-IL59-TR-1
WIDTH x HIGHT.	14'-0" x 12'-0"
BORDER WIDTH	2"
CORNER RADIUS	12"
MOUNTING	Overhead
BACKGROUND	TYPE: ZZ SHEETING
	COLOR: Green
LEGEND/BORDER	TYPE: ZZ SHEETING
	COLOR: White/Black/White


SYMBOL	ROT	X	Y	WID	HT
M1: HGA-2-32-ISO	0	109	75	40.5	36
M1_1	0	26	50	36	36
AR Type A - Extended	0	72.9	13	22.2	50.9

Panel Style: guide_exp_advance_intermediate.ssi
Dimensions are in inches tenths

Letter locations are panel edge to lower left corner

LETTER POSITIONS (X)					LENGTH	SERIES/SIZE
N	O	R	T	H		E 2000
104.5	116.8	127.5	136.7	145.9	49.5	12,10
T	O	L	L		43.6	12
22.2	32.9	45.7	56.8			E 2000
W	E	S	T		40.1	12,10
24	38.5	47.4	56.6			

SIGN DETAIL
1:75

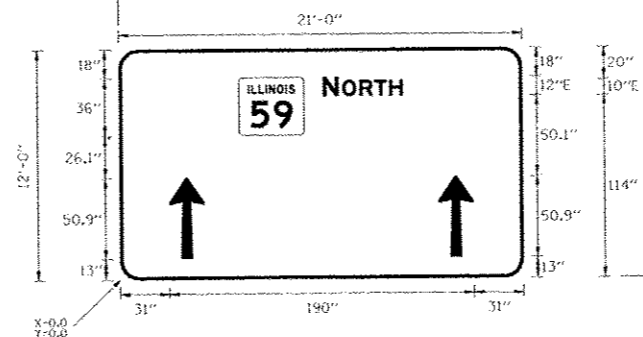

SIGN NUMBER	NB-IL59-TR-2
WIDTH x HIGHT.	21'-0" x 12'-0"
BORDER WIDTH	2"
CORNER RADIUS	12"
MOUNTING	Overhead
BACKGROUND	TYPE: ZZ SHEETING
	COLOR: Green
LEGEND/BORDER	TYPE: ZZ SHEETING
	COLOR: White/White


SYMBOL	ROT	X	Y	WID	HT
M1: HGA-2-32-ISO	0	75	90	40.5	36
AR Type A - Extended	0	31	13	22.2	50.9
AR Type A - Extended	0	198.9	13	22.2	50.9

Panel Style: guide_exp_advance_intermediate.ssi
Dimensions are in inches tenths

Letter locations are panel edge to lower left corner

LETTER POSITIONS (X)					LENGTH	SERIES/SIZE
N	O	R	T	H		E 2000
127.5	139.8	150.5	159.7	168.9	49.5	12,10

SIGN DETAIL
1:75

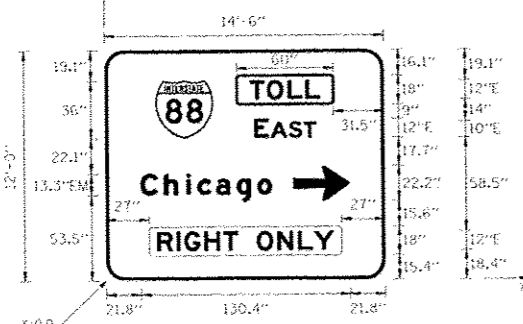


SIGN NUMBER	NB-IL59-TR-3
WIDTH x HIGHT.	14'-6" x 12'-0"
BORDER WIDTH	2"
CORNER RADIUS	12"
MOUNTING	Overhead
BACKGROUND	TYPE: ZZ SHEETING
	COLOR: Green
LEGEND/BORDER	TYPE: ZZ SHEETING
	COLOR: White/Black/White

SYMBOL	ROT	X	Y	WID	HT
M1_1	0	31.5	88.9	36	36
AR Type A	270	117.3	49	22.2	34.9

Panel Style: guide_exp_advance_intermediate.ssi
Dimensions are in inches tenths

Letter locations are panel edge to lower left corner

LETTER POSITIONS (X)										LENGTH	SERIES/SIZE
T	O	L	L								E 2000
90.7	101.4	114.2	125.3							43.6	12
E	A	S	T							38.3	E 2000
93.4	103.6	114.9	124.1								12,10
C	H	I	C	A	G	D				82.1	EM 2000
21.8	36.3	50.5	57.3	69	81.9	94.9					13,3/0
R	I	G	H	T	O	N	L	Y		110.2	E 2000
31.9	44	49	61.4	73.2	82.2	94.2	107	119.9	129.8		12

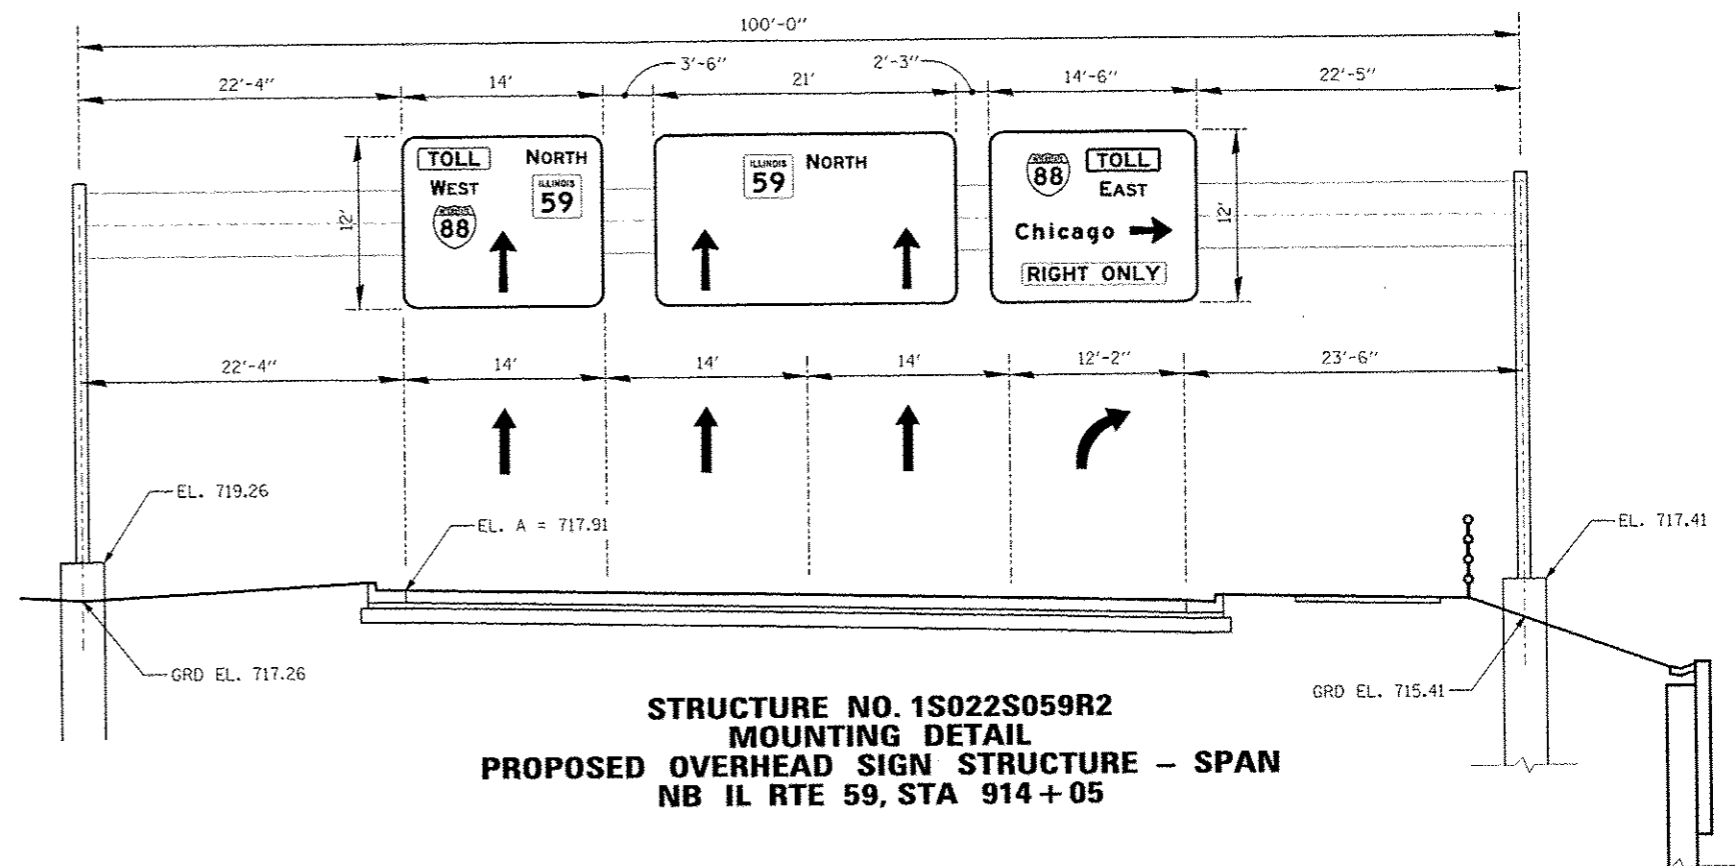

STRUCTURE NO. 1S022S059R2
MOUNTING DETAIL
PROPOSED OVERHEAD SIGN STRUCTURE - SPAN
NB IL RTE 59, STA 914 + 05

FILE NAME	USER NAME	DESIGNED	REVISED
APR11.4	USERA	PJO	
		DRAWN	REVISED
		KES	
		CHECKED	REVISED
		JCM	
		DATE	REVISED
		10/15/2012	

STATE OF ILLINOIS
DEPARTMENT OF TRANSPORTATION

SIGN STRUCTURES
SPAN 1S022S059R2 (IDOT)
SCALE: SHEET NO. 2 OF 15 SHEETS STA. 914+05 TO STA.

F.A.P. RTE.	SECTION	COUNTY	TOTAL SHEETS	SHEET NO.
338	(112 & 113) WRS-5	DUPAGE	963	402
				CONTRACT NO. 60131
ILLINOIS FED. AID PROJECT				