
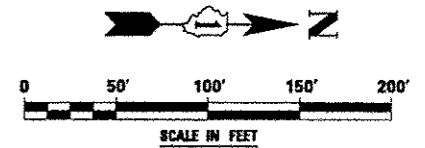


**NOTES:**

1. ALL LIGHTING POLES AND WIRING SHALL BE INSTALLED AND POWERED UNDER CONTRACT 60I31.
2. FOR SYMBOL LIST AND GENERAL ELECTRICAL NOTES, SEE SHEET LT-01.
3. NOT USED.
4. UNIT DUCT, 600V, 3-1C NO. 4, 1/C NO.6 GROUND, (XLP-TYPE USE), 1 1/4" DIA. POLYETHYLENE.
5. LIGHTING/WIRING SHALL BE INSTALLED UNDER CONTRACT 60R31. A
6. POLE SETBACK SHALL BE MEASURED FROM THE BACK OF CURB TO THE CENTER OF THE POLE.
7. INSTALL AND CAP CONDUIT ELBOW IN FOUNDATION FOR FUTURE CONNECTION TO THE INTERSECTION LIGHTING.

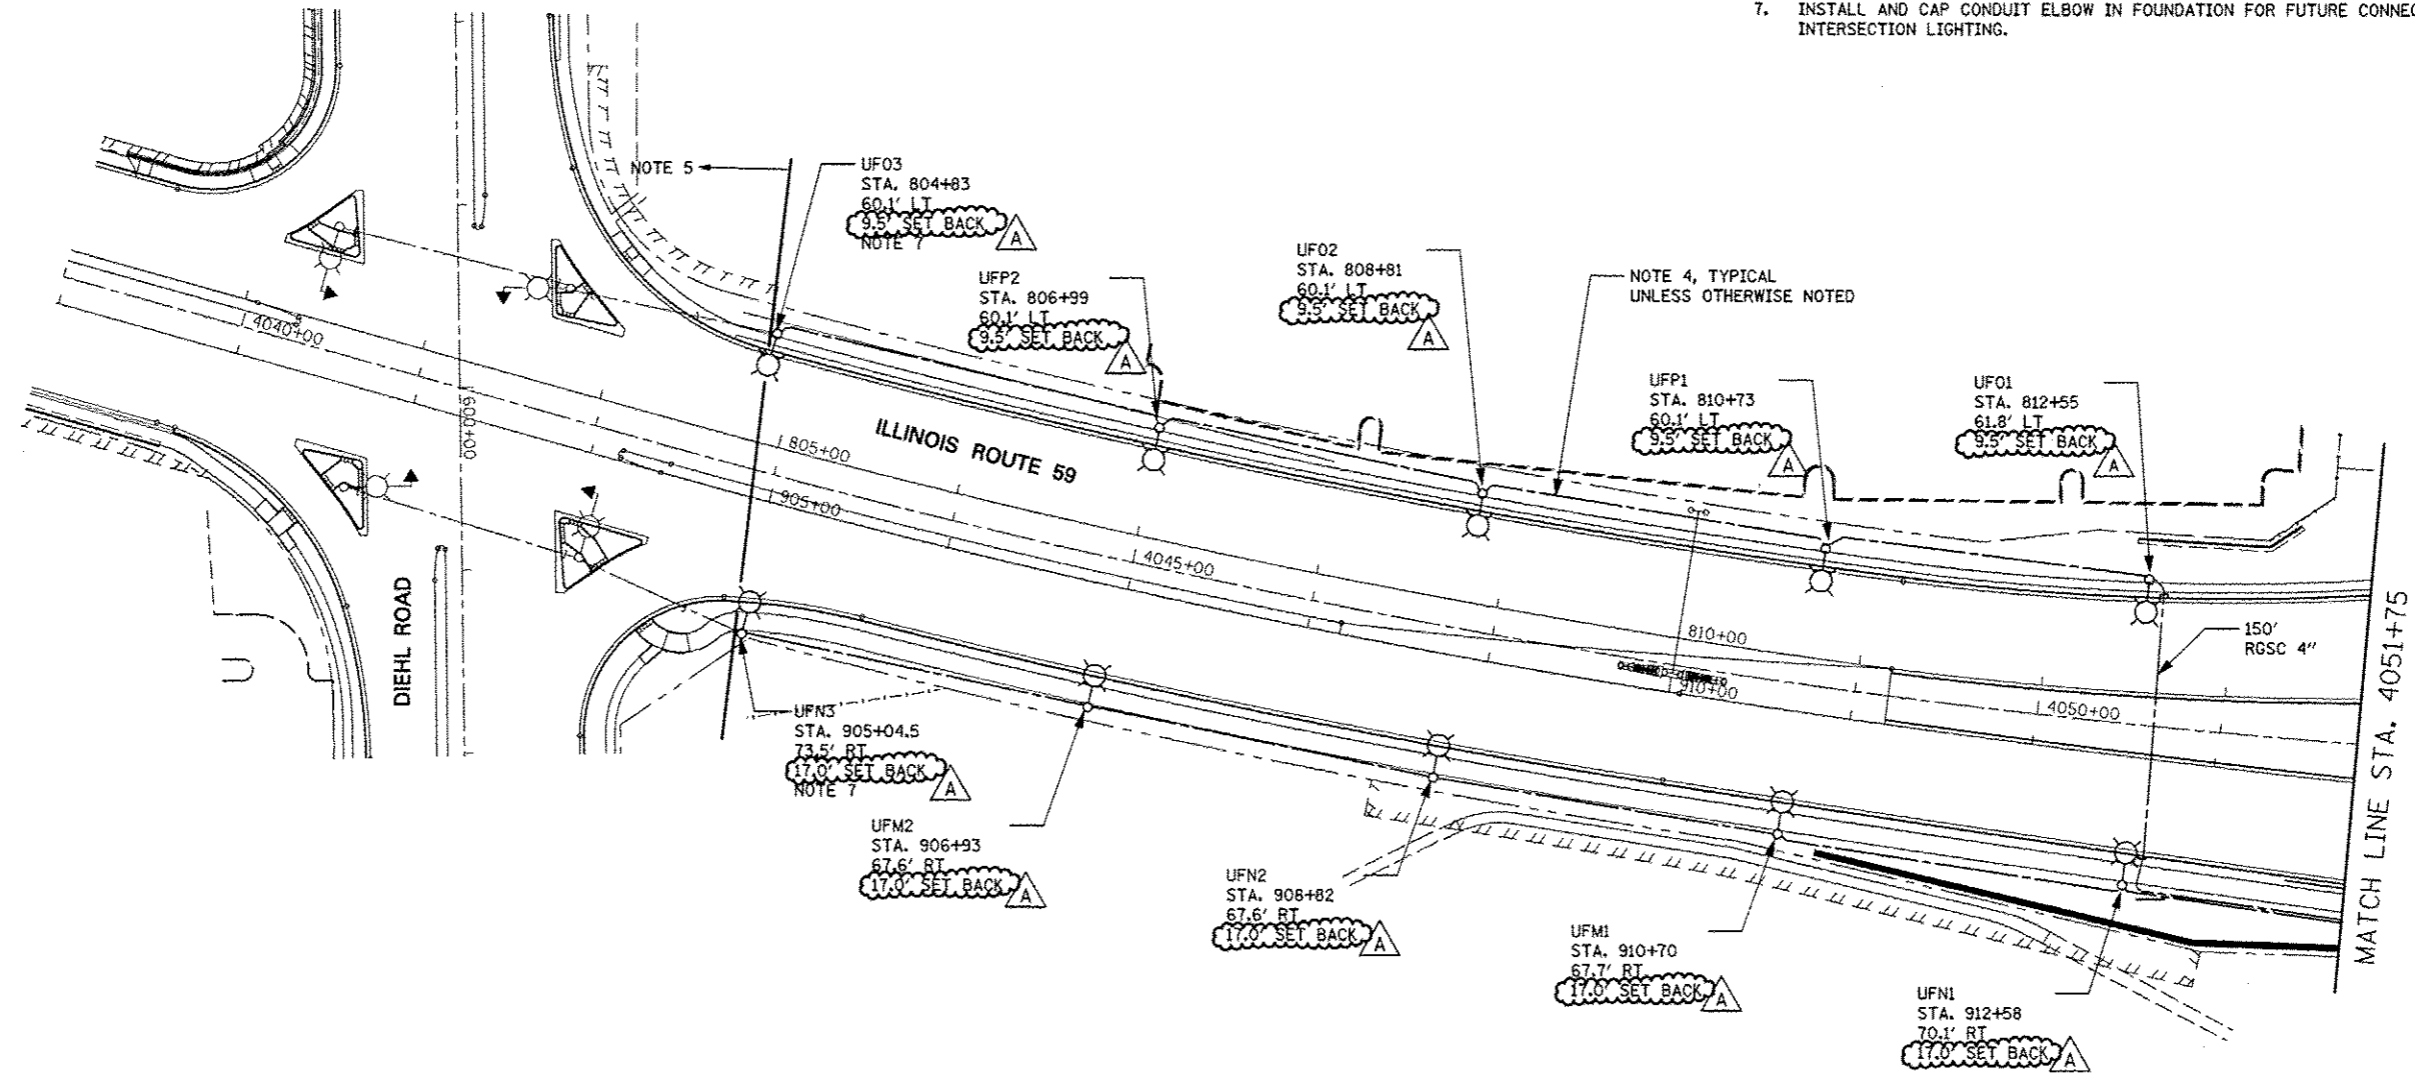

FILE NAME *	USER NAME * #USER#	DESIGNED MCP	REVISED ADDENDUM A 12/17/2012	<b>STATE OF ILLINOIS DEPARTMENT OF TRANSPORTATION</b>	<b>IDOT LIGHTING PLAN - ILLINOIS ROUTE 59</b>	F.A.P. RTE.	SECTION	COUNTY	TOTAL SHEETS	SHEET NO.	
*FILE#		DRAWN MLB	REVISED -			338	(112 & 113) WRS-5	DUPAGE	963	558	
PLOT SCALE = #SCALE#		CHECKED MCP	REVISED -			<b>LT-03</b>		CONTRACT NO. 60I31			
PLOT DATE = #DATE#		DATE 10/15/2012	REVISED -			SCALE: AS SHOWN SHEET NO. 1 OF 2 SHEETS STA. 4039+00 TO STA. 4051+75		ILLINOIS FED. AID PROJECT			