


NOTE:
 1. THE GENERAL CONTRACTOR IS REQUIRED TO HIRE AN ENVIRONMENTAL FIRM WITH AT LEAST FIVE (5) DOCUMENTED LEAKING UNDERGROUND STORAGE TANK CLEANUPS OR THAT IS PRE-QUALIFIED IN HAZARDOUS WASTE BY THE DEPARTMENT TO REMEDIATE THE SOIL CONTAMINATION AND MONITOR FOR WORKER PROTECTION.

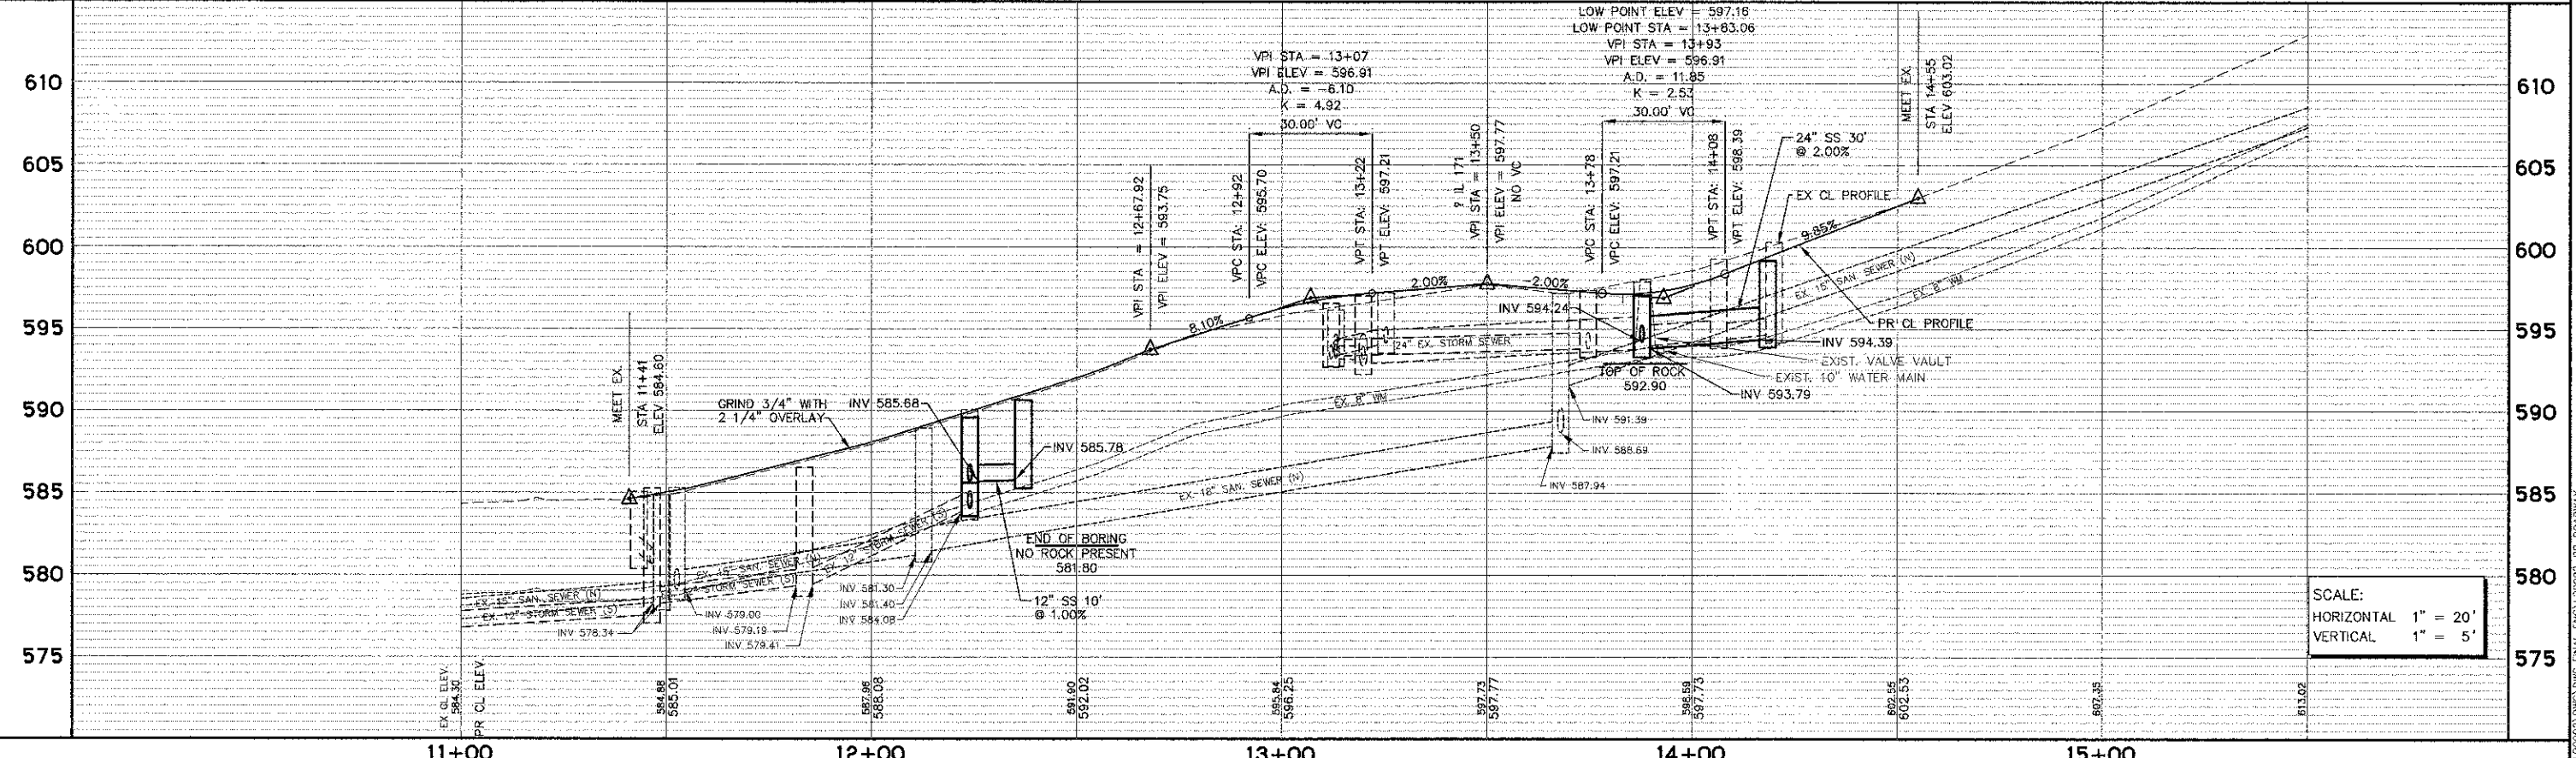

SCALE:
 HORIZONTAL 1" = 20'
 VERTICAL 1" = 5'

Plotter: February 8, 2013 @ 9:15 AM By: Jim Schmidt - Tab: 15 13th 22d34

COPYRIGHT © 2013 ENGINEERING ENTERPRISES, INC.				STATE OF ILLINOIS				13th STREET				F.A.P. RTE. 577		SECTION 10-00068-00-TL		COUNTY WILL		TOTAL SHEETS 65		SHEET NO. 15					
Engineering Enterprises, Inc. CONSULTING ENGINEERS 52 Wheeler Road Sugar Grove, Illinois 60554 630.466.6700 / www.eeiweb.com				DESIGNED - JRL & SWM DRAWN - CLN CHECKED - JL DATE - 11/13/12				REVISED - JPS 02/08/13 REVISED - REVISED - REVISED -				DEPARTMENT OF TRANSPORTATION				PLAN AND PROFILE				CONTRACT NO. 63788		FED. ROAD DIST. NO. 1 ILLINOIS FED. AID PROJECT M-30031619			
USER NAME = Jim Schmidt				PLOT SCALE =				PLOT DATE = February 8, 2013				SCALE: HORIZ. 1"=20' VERT. 1"=5'				SHEET NO. 4 OF 4 SHEETS				STA. 11+00 TO STA. 15+50					