



TYPICAL SPLICE DETAIL

N.T.S.

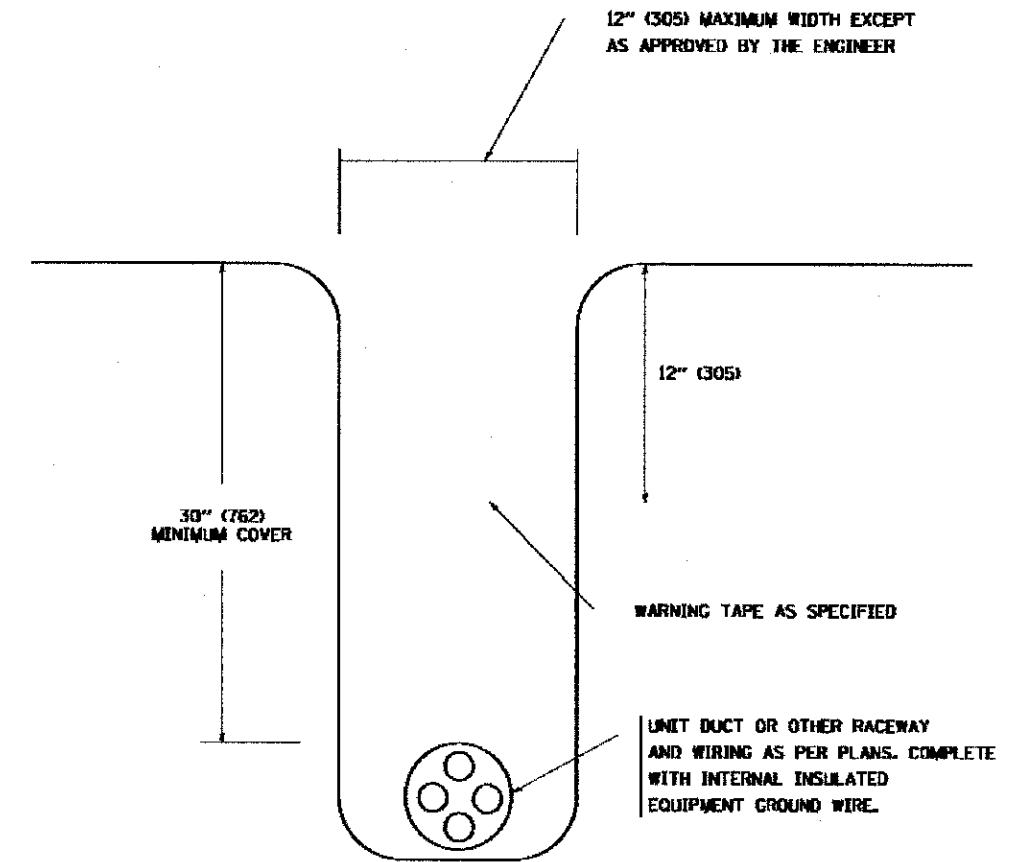

TYPICAL WIRING IN TRENCH DETAIL

N.T.S.

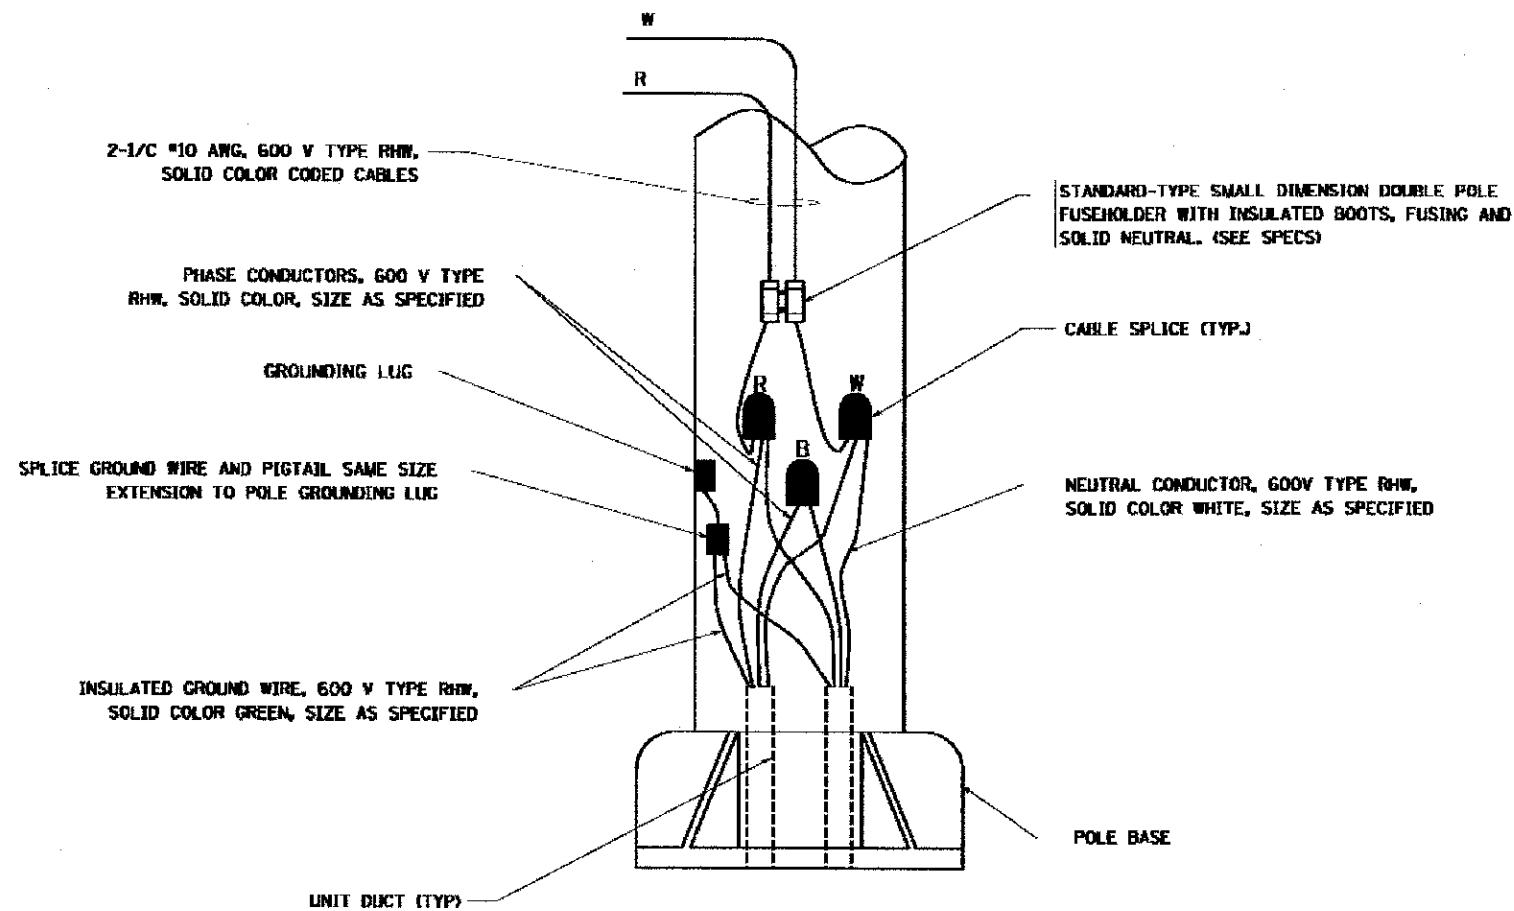

POLE WIRING DETAIL

N.T.S.

FILE NAME = I:\SPRQ\0829087.dwg; I:\Rollins\Design\Lighting\0829087.dwg; Rollins-Lighting\0829087.dwg



Ciorba Group, Inc.
CONSULTING ENGINEERS
5507 North Cumberland Avenue, Suite 402
Chicago, Illinois 60656
Tel. 773.775.4009 Fax 773.775.4014

USER NAME = jk,jelimon	DESIGNED - JMV	REVISED -
PLOT SCALE = 2,0000' / in.	DRAWN - JMV	REVISED -
PLOT DATE = 4/8/2013	CHECKED - MJL	REVISED -
	DATE - 4/8/2013	REVISED -

**MILLENNIUM TRAIL
LAKE COUNTY FOREST PRESERVES**

**MISCELLANEOUS ELECTRICAL DETAILS
ROLLINS ROAD UNDERPASS**

SCALE: NONE SHEET NO. OF SHEETS STA. TO STA.

F.A.U. RTE.	SECTION	COUNTY	TOTAL SHEETS	SHEET NO.
181	12-F3000-01-BT	LAKE	118	48
FED. ROAD DIST. NO. - ILLINOIS FED. AID PROJECT				CONTRACT NO. 63807