

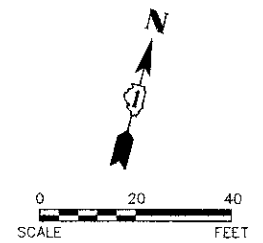


DATE	
BY	
PROJECT	
CLIENT	
NO. OF SHEETS	
NO. OF THIS SHEET	
DATE	
BY	
PROJECT	
CLIENT	
NO. OF SHEETS	
NO. OF THIS SHEET	
DATE	
BY	
PROJECT	
CLIENT	
NO. OF SHEETS	
NO. OF THIS SHEET	

DATE	
BY	
PROJECT	
CLIENT	
NO. OF SHEETS	
NO. OF THIS SHEET	
DATE	
BY	
PROJECT	
CLIENT	
NO. OF SHEETS	
NO. OF THIS SHEET	
DATE	
BY	
PROJECT	
CLIENT	
NO. OF SHEETS	
NO. OF THIS SHEET	

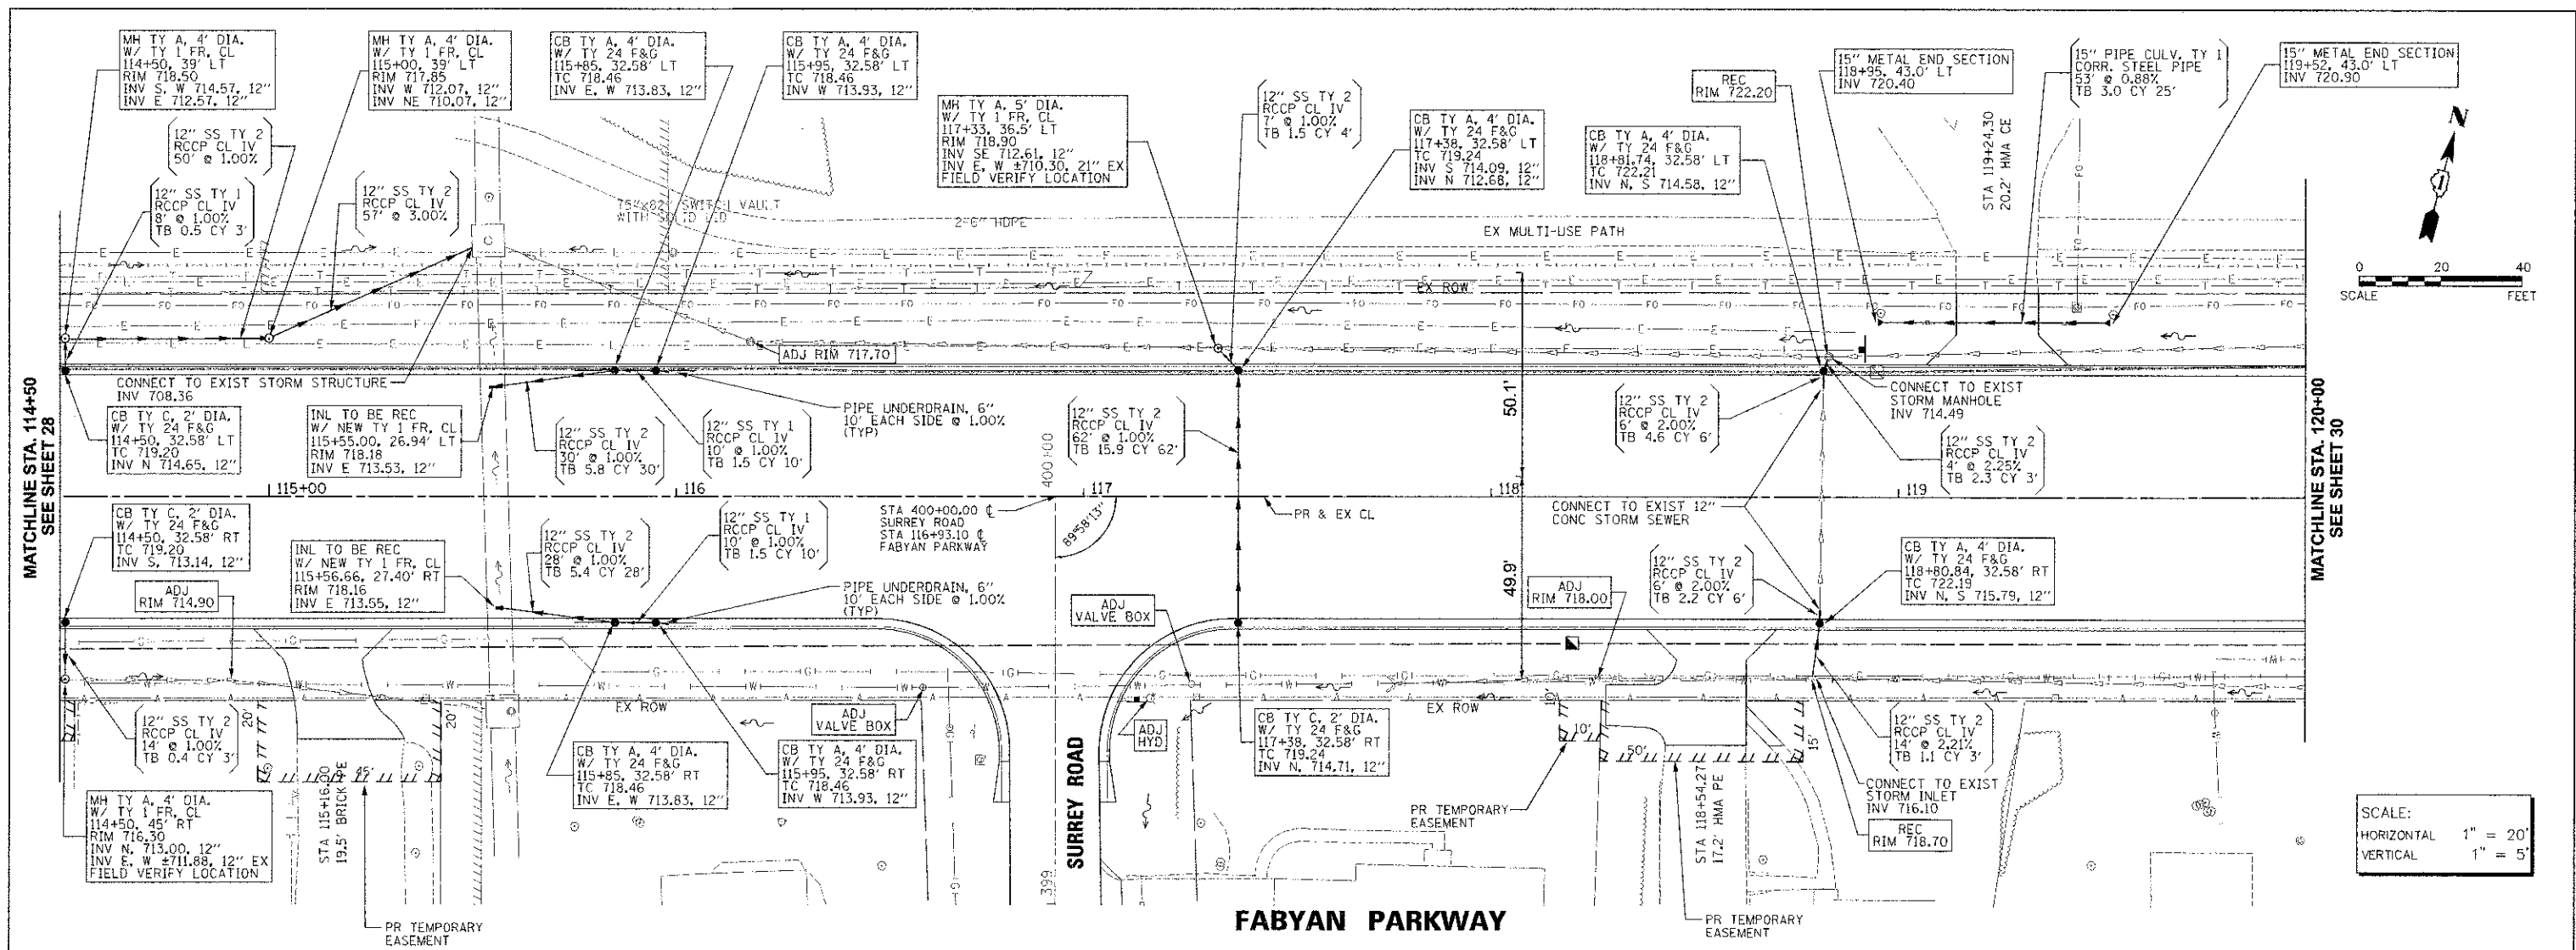

SCALE:  
 HORIZONTAL 1" = 20'  
 VERTICAL 1" = 5'

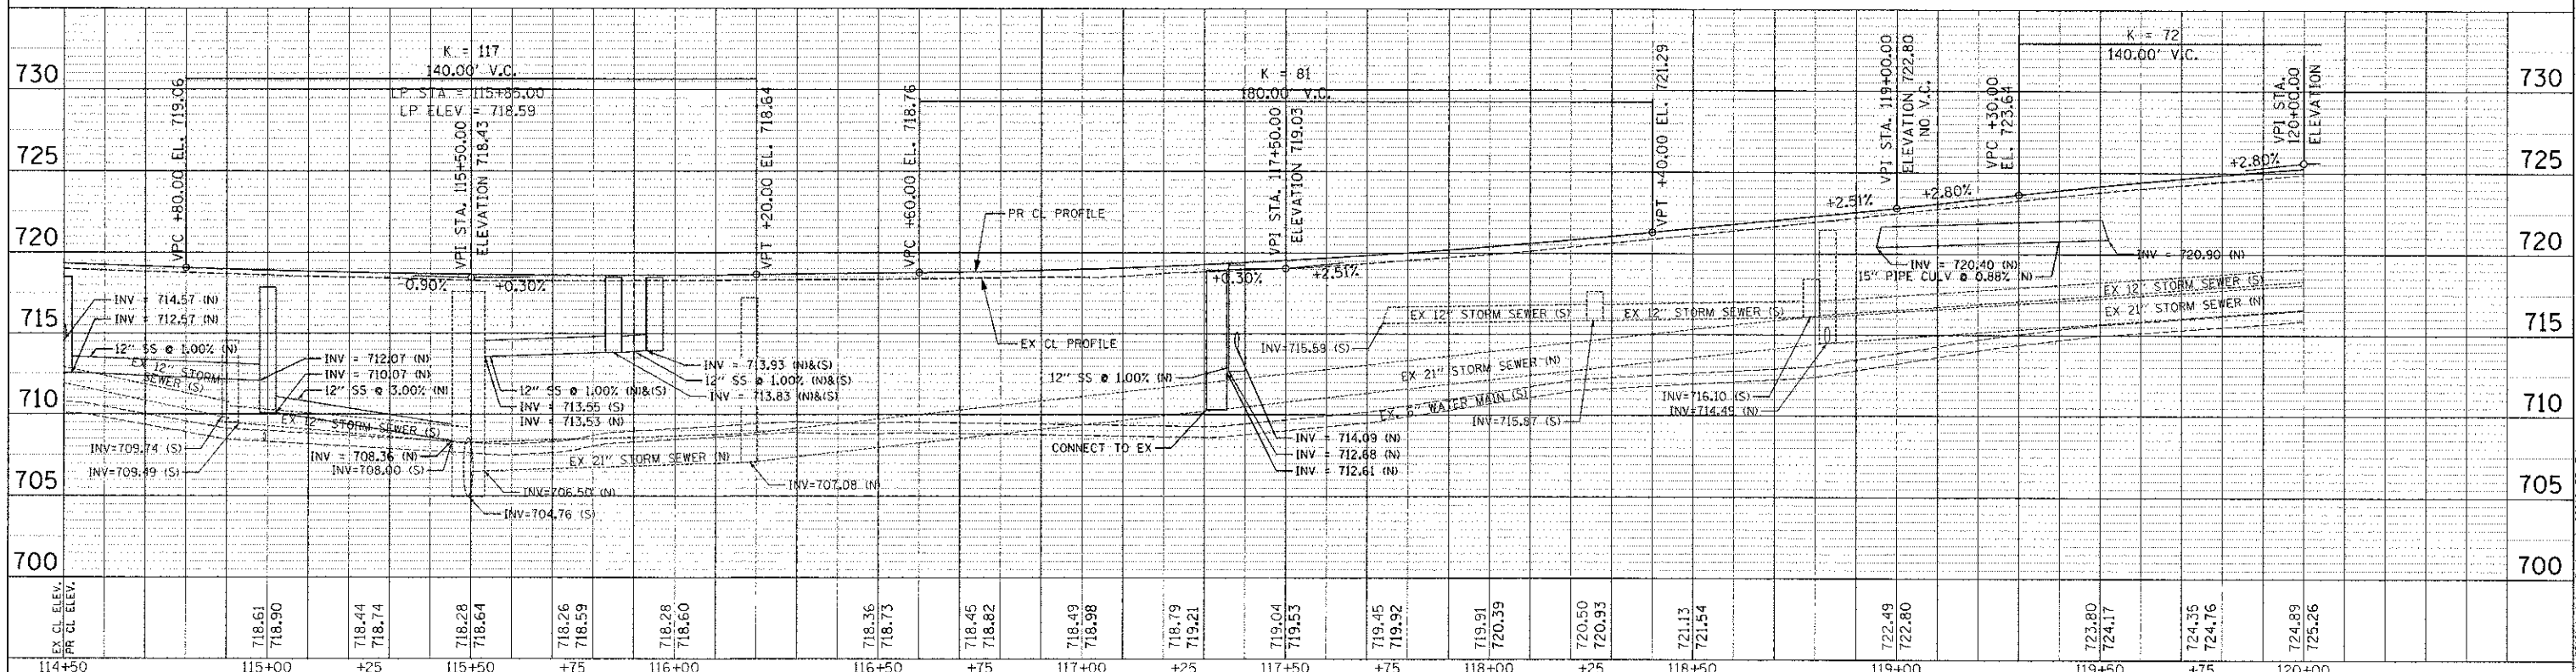

 <b>Engineering Enterprises, Inc.</b> CONSULTING ENGINEERS 52 Wheeler Road Sugar Grove, Illinois 60554 630.466.6700 / www.eelweb.com	<b>KANE COUNTY DIVISION          OF TRANSPORTATION</b> 41W011 BURLINGTON ROAD ST. CHARLES, IL 60175	DESIGNED JWS, SWZ	REVISED JPS 02/04/13	<b>STATE OF ILLINOIS          DEPARTMENT OF TRANSPORTATION</b> <b>FABYAN PARKWAY          DRAINAGE AND UTILITY PLAN &amp; PROFILE</b>	F.A.P. RTE. 363	SECTION 10-00404-00-CH	COUNTY KANE	TOTAL SHEETS 59	SHEET NO. 29
		DRAWN JPS	REVISED -		C-91-496-10	CONTRACT NO. 63818			
		CHECKED JR	REVISED -		SCALE: 1"=20' SHEET NO. 4 OF 5 SHEETS STA. 114+50 TO STA. 120+00 ILLINOIS FED. AID PROJECT CMM-90031627				
DATE 12/1/12	REVISED -								

Plot Date: 2/17/2013 10:22:15 AM By: dschmitt

Path: \\nas001\proj\63818\Fabyan\114-120.dwg