


BORDER
R=1.13"
TH=0.63"
IN=0.38"

Panel Style: regulatory.ssi
M.U.T.C.D.: 2009 Edition

CYCLISTS DISMOUNT SIGN DETAILS

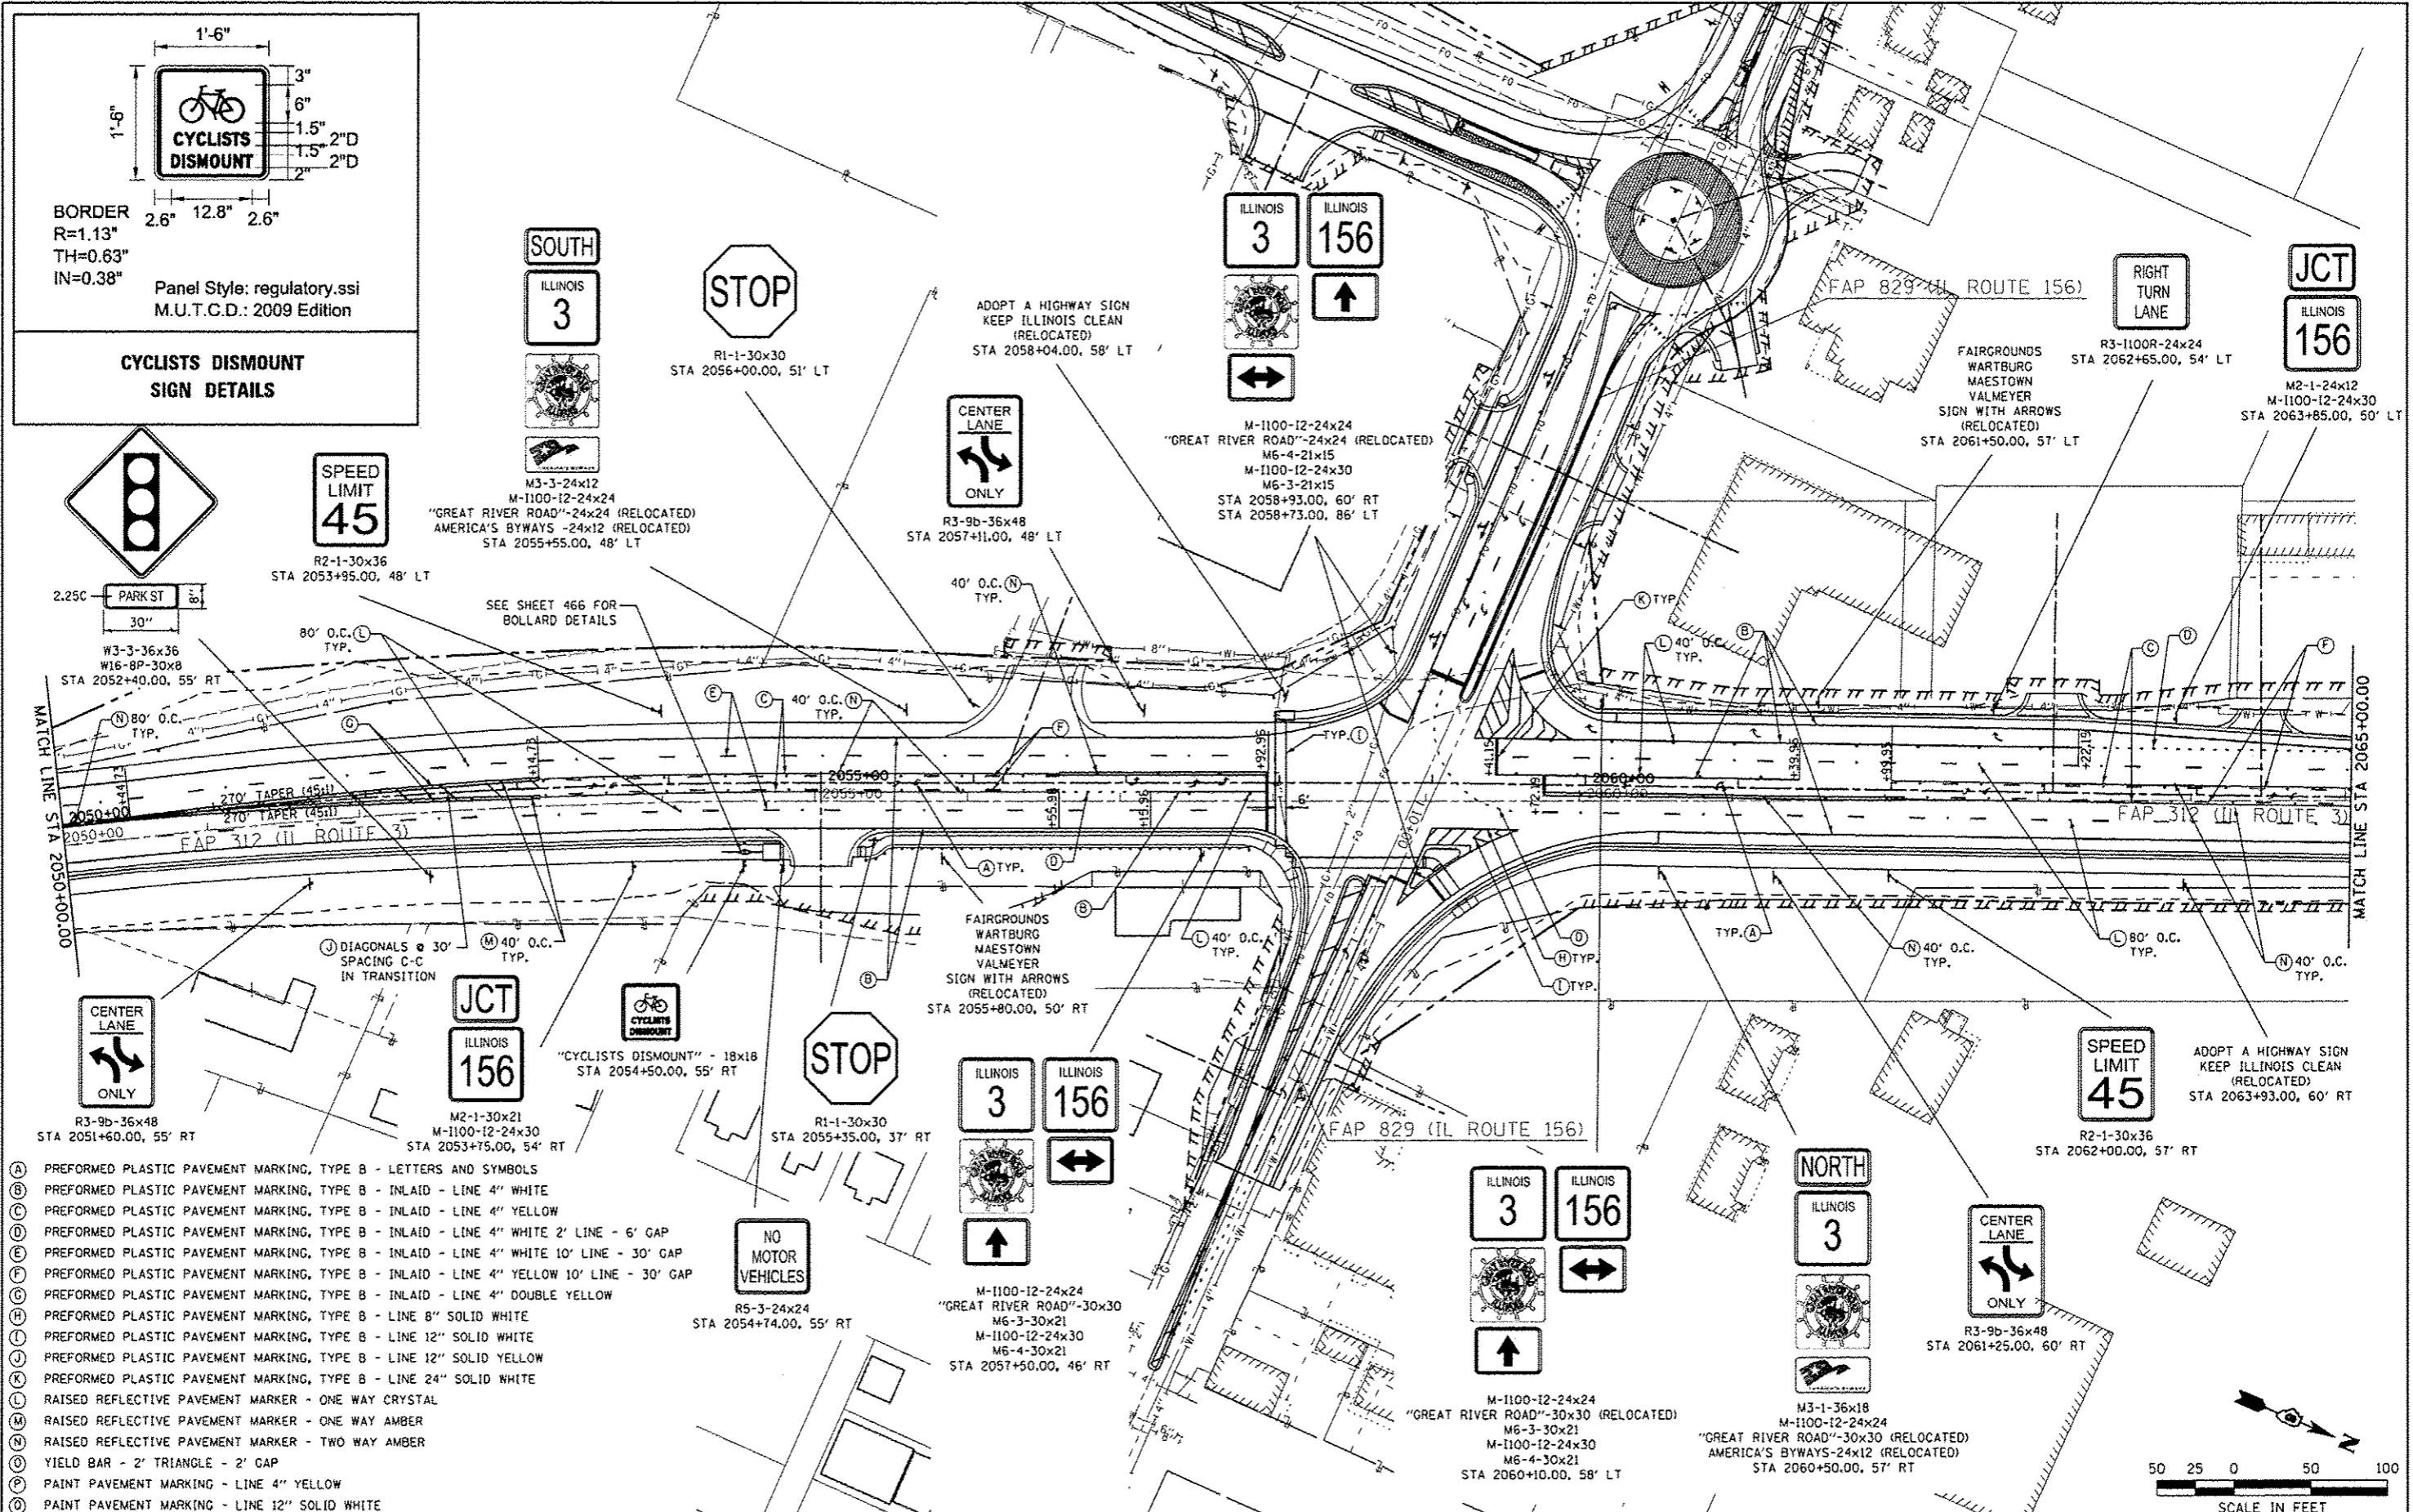

- (A) PREFORMED PLASTIC PAVEMENT MARKING, TYPE B - LETTERS AND SYMBOLS
- (B) PREFORMED PLASTIC PAVEMENT MARKING, TYPE B - INLAID - LINE 4" WHITE
- (C) PREFORMED PLASTIC PAVEMENT MARKING, TYPE B - INLAID - LINE 4" YELLOW
- (D) PREFORMED PLASTIC PAVEMENT MARKING, TYPE B - INLAID - LINE 4" WHITE 2' LINE - 6' GAP
- (E) PREFORMED PLASTIC PAVEMENT MARKING, TYPE B - INLAID - LINE 4" WHITE 10' LINE - 30' GAP
- (F) PREFORMED PLASTIC PAVEMENT MARKING, TYPE B - INLAID - LINE 4" YELLOW 10' LINE - 30' GAP
- (G) PREFORMED PLASTIC PAVEMENT MARKING, TYPE B - INLAID - LINE 4" DOUBLE YELLOW
- (H) PREFORMED PLASTIC PAVEMENT MARKING, TYPE B - LINE 8" SOLID WHITE
- (I) PREFORMED PLASTIC PAVEMENT MARKING, TYPE B - LINE 12" SOLID WHITE
- (J) PREFORMED PLASTIC PAVEMENT MARKING, TYPE B - LINE 12" SOLID YELLOW
- (K) PREFORMED PLASTIC PAVEMENT MARKING, TYPE B - LINE 24" SOLID WHITE
- (L) RAISED REFLECTIVE PAVEMENT MARKER - ONE WAY CRYSTAL
- (M) RAISED REFLECTIVE PAVEMENT MARKER - ONE WAY AMBER
- (N) RAISED REFLECTIVE PAVEMENT MARKER - TWO WAY AMBER
- (O) YIELD BAR - 2' TRIANGLE - 2' GAP
- (P) PAINT PAVEMENT MARKING - LINE 4" YELLOW
- (Q) PAINT PAVEMENT MARKING - LINE 12" SOLID WHITE

FILE NAME	USER NAME	DESIGNED	REVISION
PROJECTS\98-101-IL-ASD	Richard Hainke	JAH	4/8/13
Drawings\98-101-IL-ASD	Sheets\Contract 2\176_0876817-sh	DRAWN	REVISION
		RNH	REVISION
		CHECKED	REVISION
		TMM	REVISION
		DATE	REVISION
			REVISION

**STATE OF ILLINOIS
DEPARTMENT OF TRANSPORTATION**

McDonough-Willow, P.C.
PROFESSIONAL DESIGNER NO. 181-002734

PAVEMENT MARKING AND SIGNING PLAN
IL ROUTE 3

F.A.P. RTE.	SECTION	COUNTY	TOTAL SHEETS	SHEET NO.
312	68-WRS-1	MONROE	760	372
CONTRACT NO. 76817			ILLINOIS FED. AID PROJECT	

