
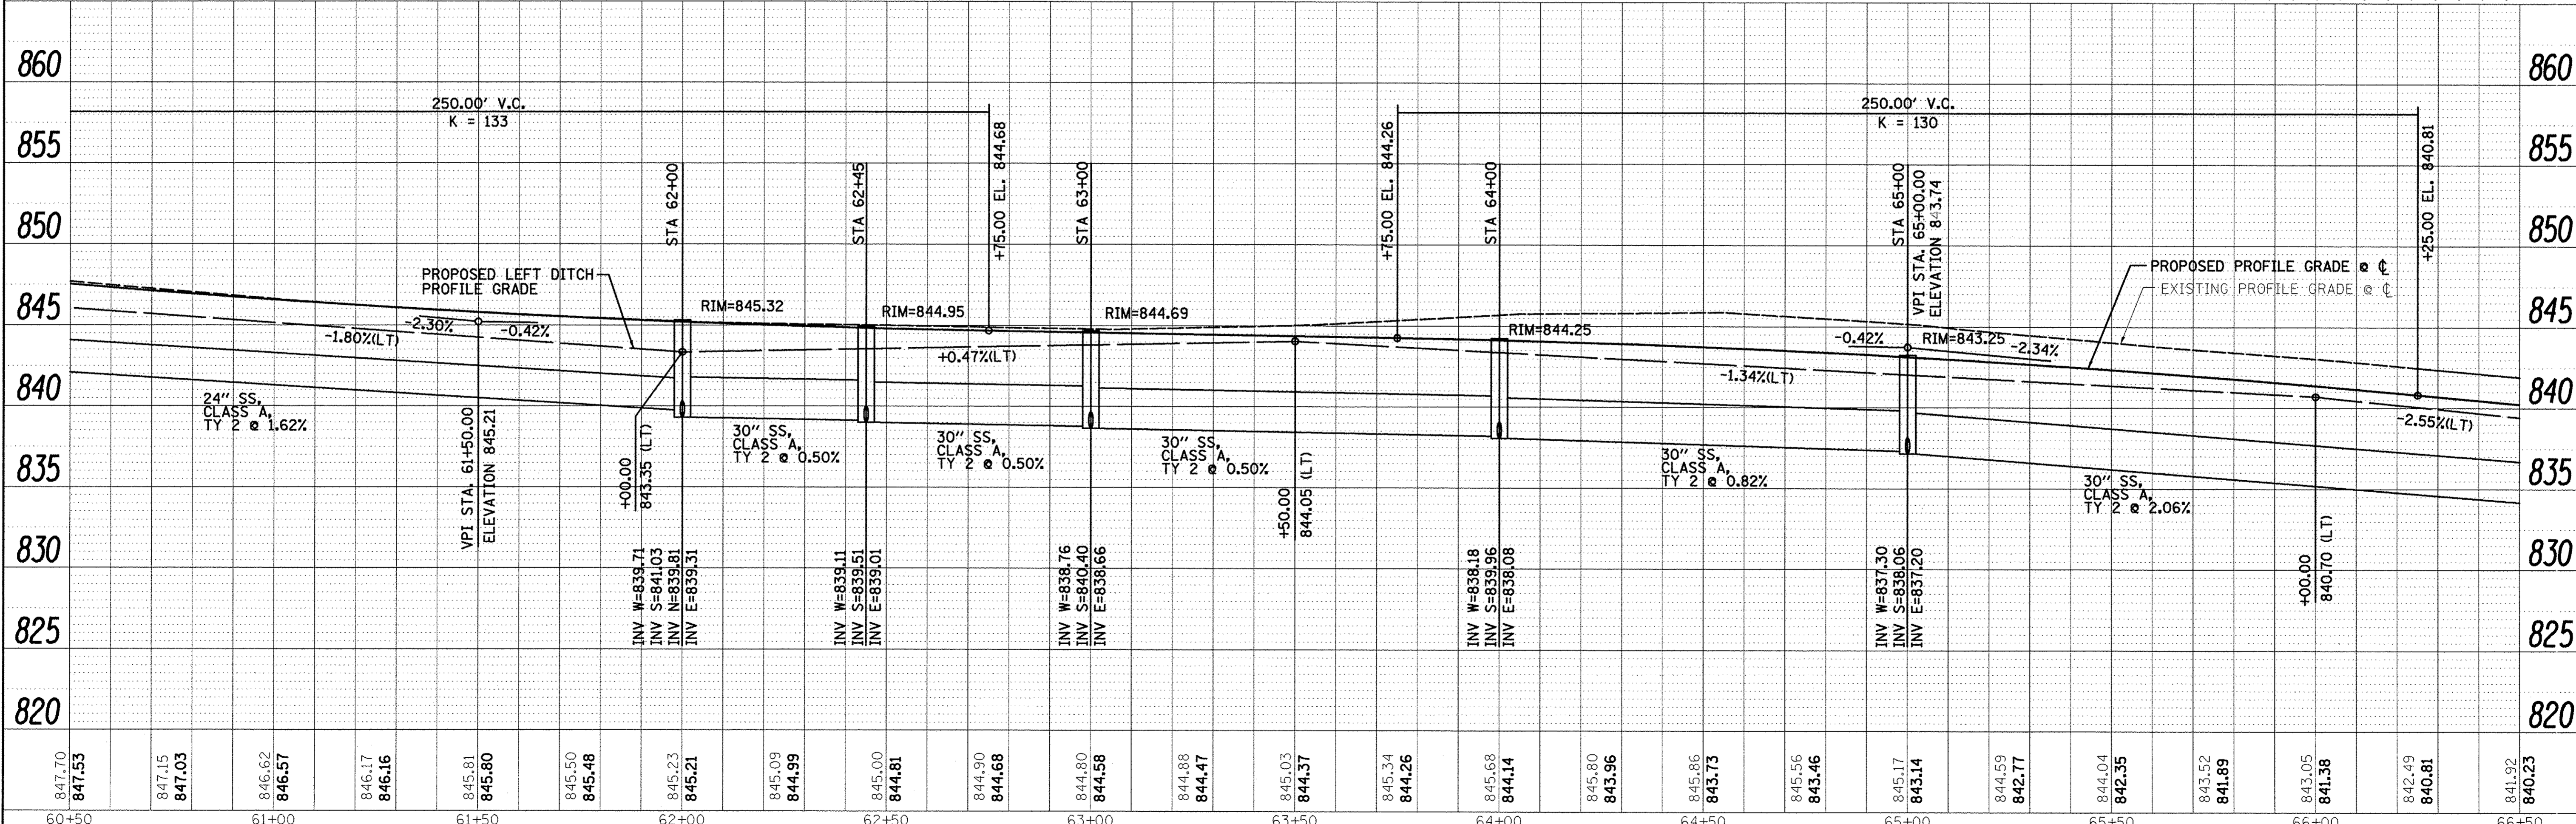
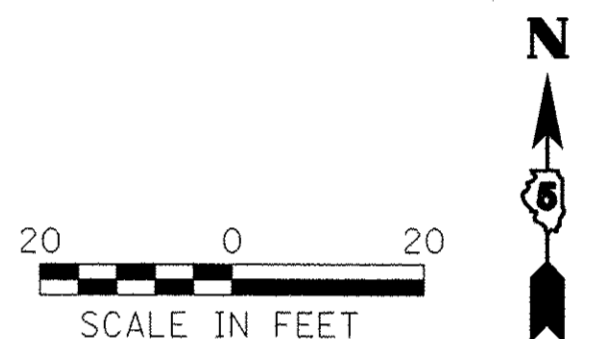


DATE	BY
REVISED	PLANNED
NOTE BOOK	ALIGNMENT CHECKED
NO.	ADD FILE NAME

DATE	BY
REVISED	GRADES CHECKED
NOTE BOOK	STRUCTURE NOTATIONS CHECKED
NO.	

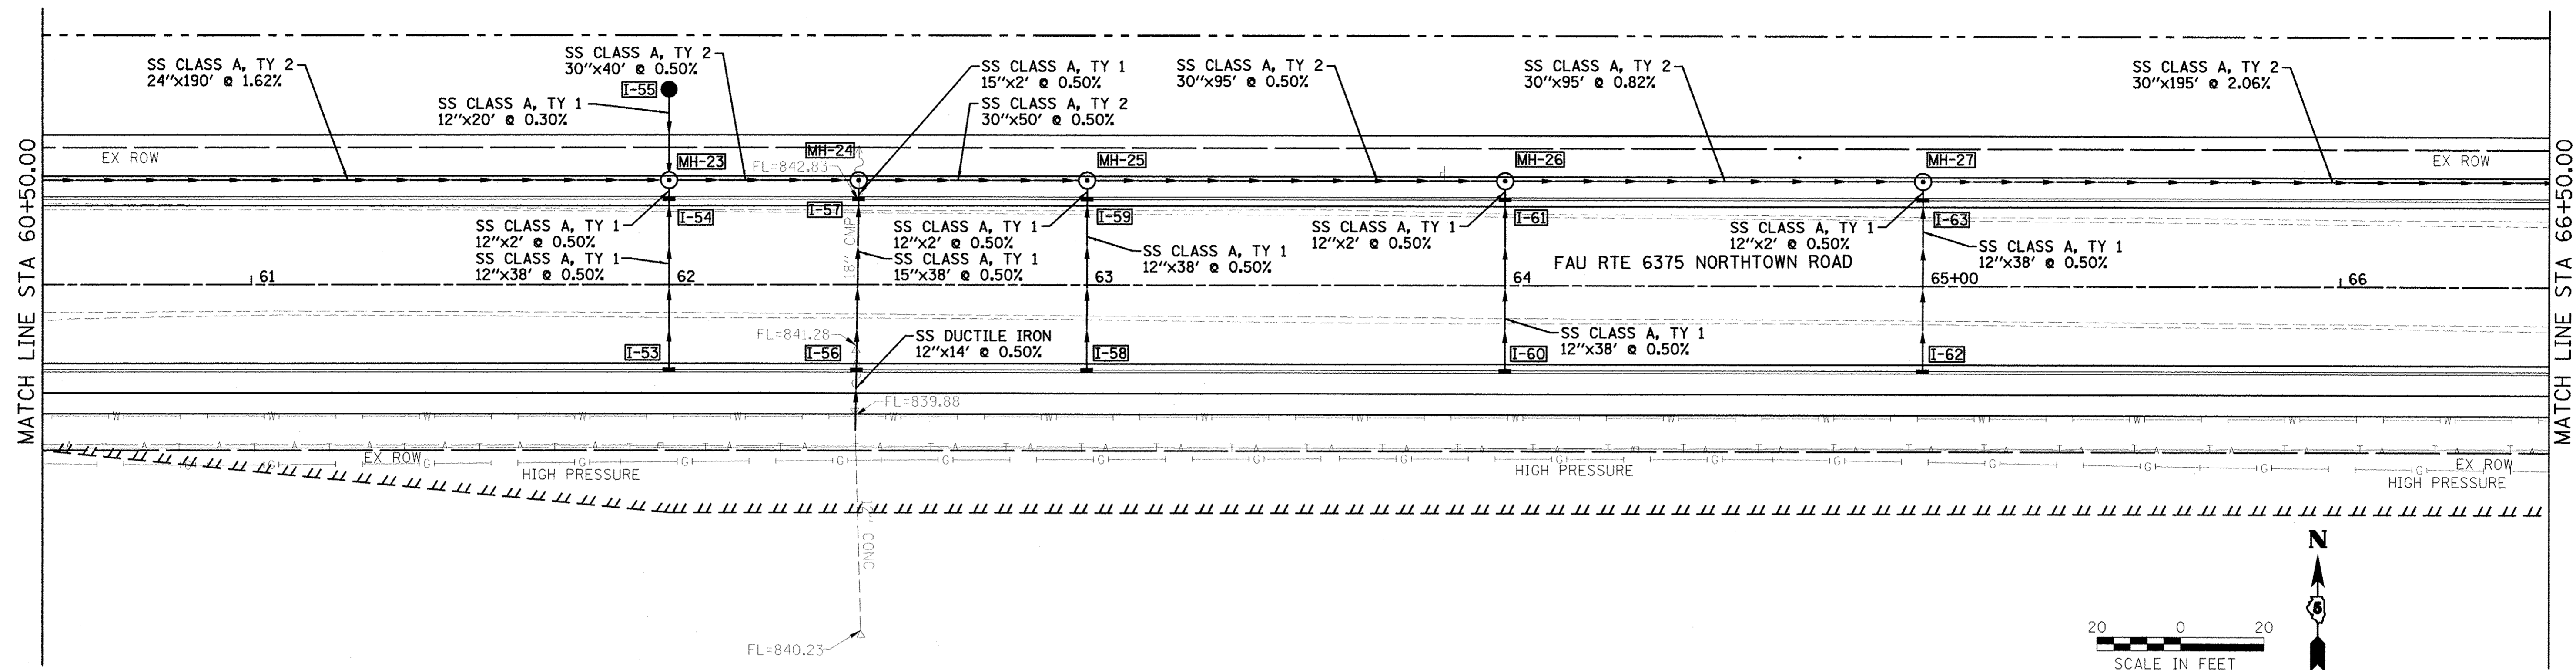

Farnsworth
GROUP, INC.
2709 McGraw Drive
Bloomington, Illinois 61704
309/663-8435, 309/663-1571 fax

DESIGNED - PJM
DRAWN - JJO/LAT
CHECKED - PJM
DATE - 01/18/13

REVISED -
REVISED -
REVISED -
REVISED -

**TOWN OF NORMAL
NORTHTOWN ROAD FROM
1200' WEST OF LINDEN STREET TO TOWANDA AVENUE**

DRAINAGE PLAN AND PROFILE

SCALE: SHEET OF SHEETS STA. 60+50.00 TO STA. 66+50.00

F.A.U. RTE. 6375	SECTION 00-00206-00-RP	COUNTY McLEAN	TOTAL SHEETS 129	SHEET NO. 66
CONTRACT NO. 91479				
ILLINOIS FED. AID PROJECT				