
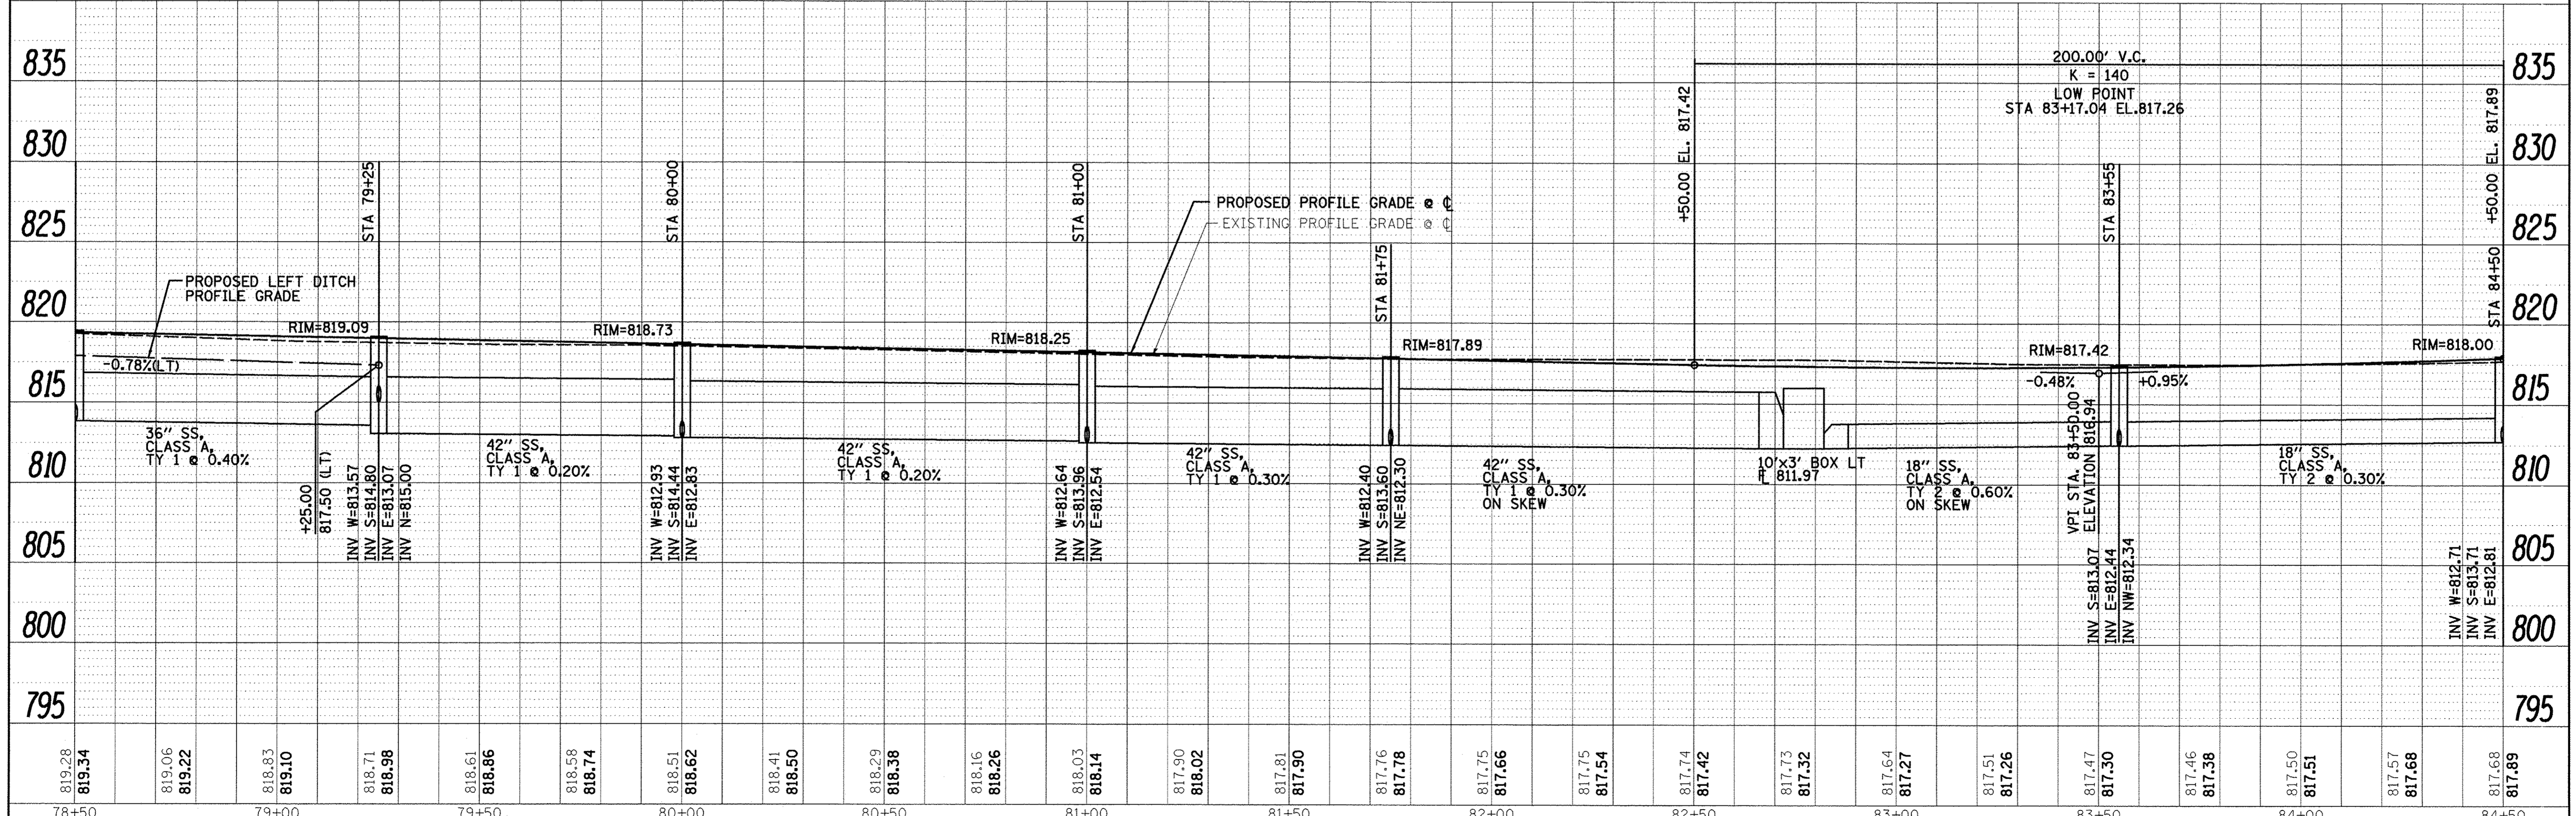


PLAN	SUBMITTED	DATE
	BY	
	NOTED	
	CHECKED	
	APPROVED	
	ADD. FILE NAME	
	NO.	

PROFILE	SUBMITTED	DATE
	BY	
	NOTED	
	CHECKED	
	APPROVED	
	ADD. FILE NAME	
	NO.	

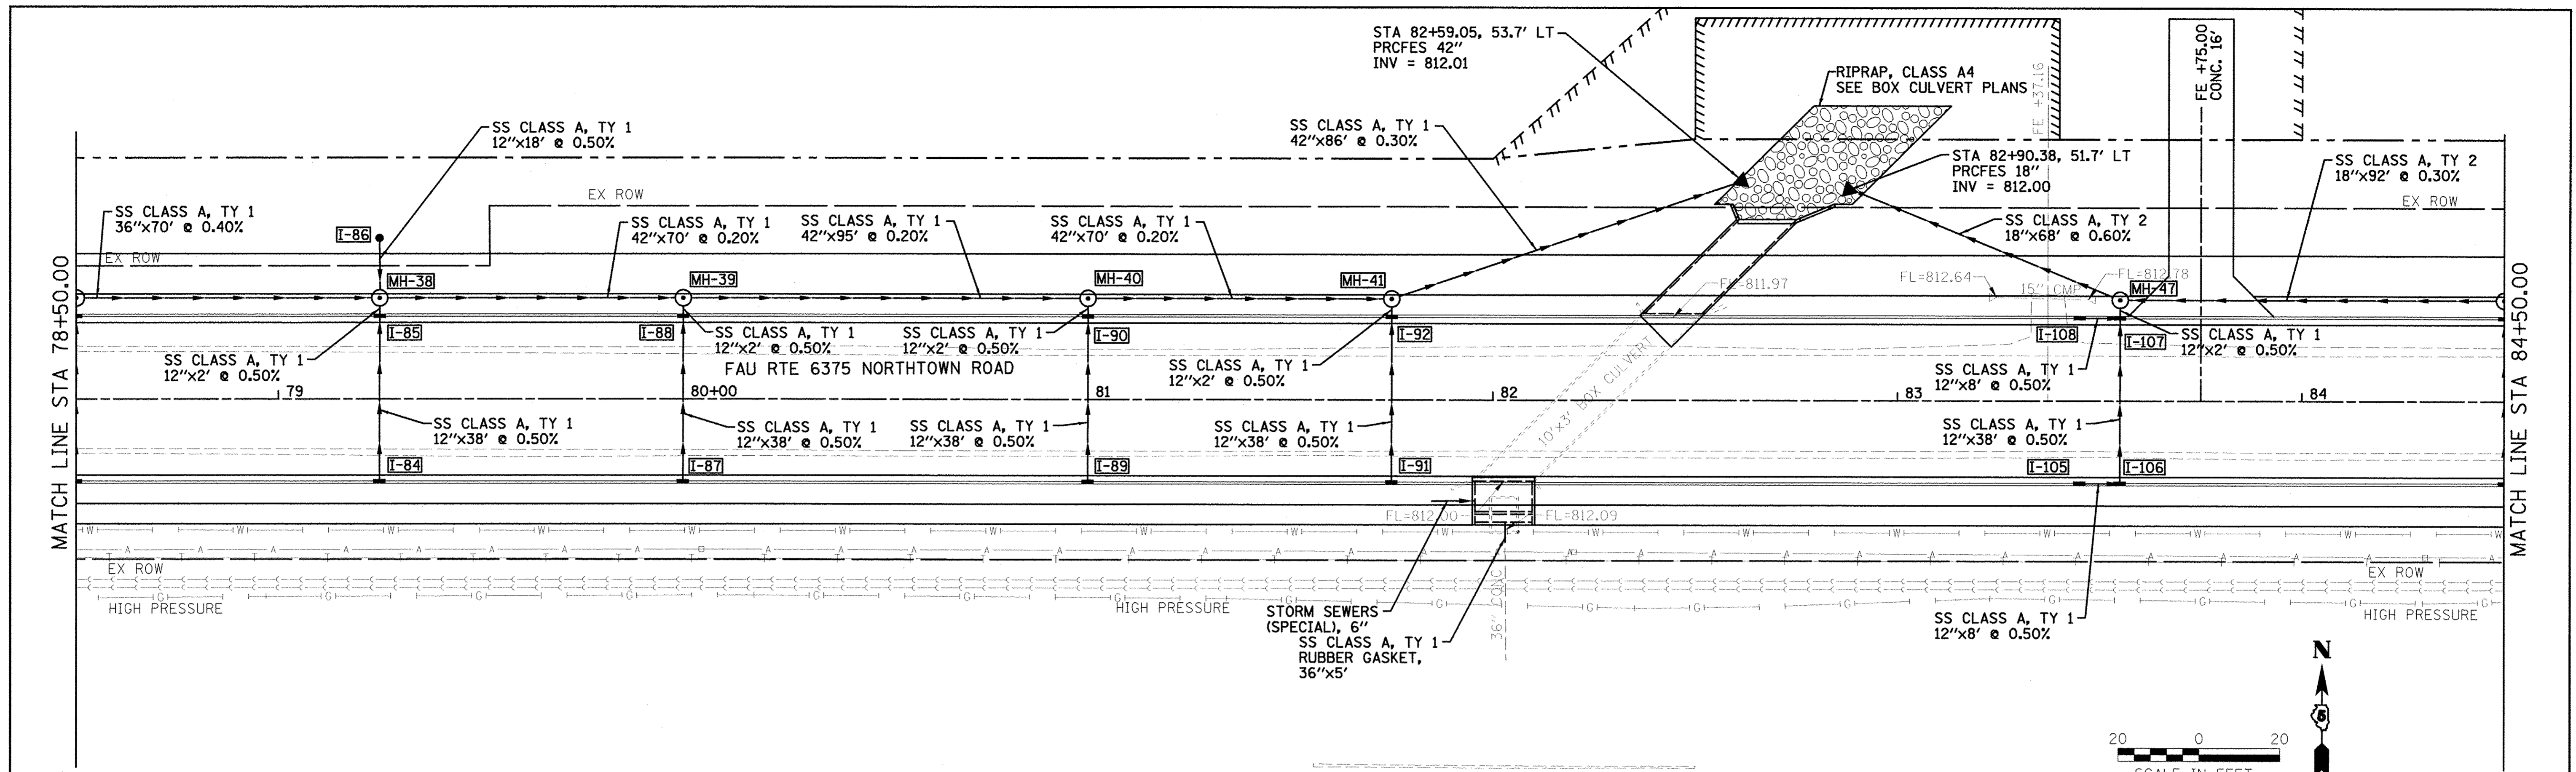

 Farnsworth GROUP, INC. 2709 McGraw Drive Bloomington, Illinois 61704 309/663-8435, 309/663-1571 fax	DESIGNED - PJM	REVISED -	TOWN OF NORMAL NORTHTOWN ROAD FROM 1200' WEST OF LINDEN STREET TO TOWANDA AVENUE	DRAINAGE PLAN AND PROFILE	F.A.U. RFE: 6375	SECTION 00-00206-00-RP	COUNTY McLEAN	TOTAL SHEETS 129	SHEET NO. 69
	DRAWN - JJO/LAT	REVISED -			SCALE: SHEET OF SHEETS STA. 78+50.00 TO STA. 84+50.00	CONTRACT NO. 91479			
	CHECKED - PJM	REVISED -			ILLINOIS FED. AID PROJECT				
	DATE - 01/18/13	REVISED -							