
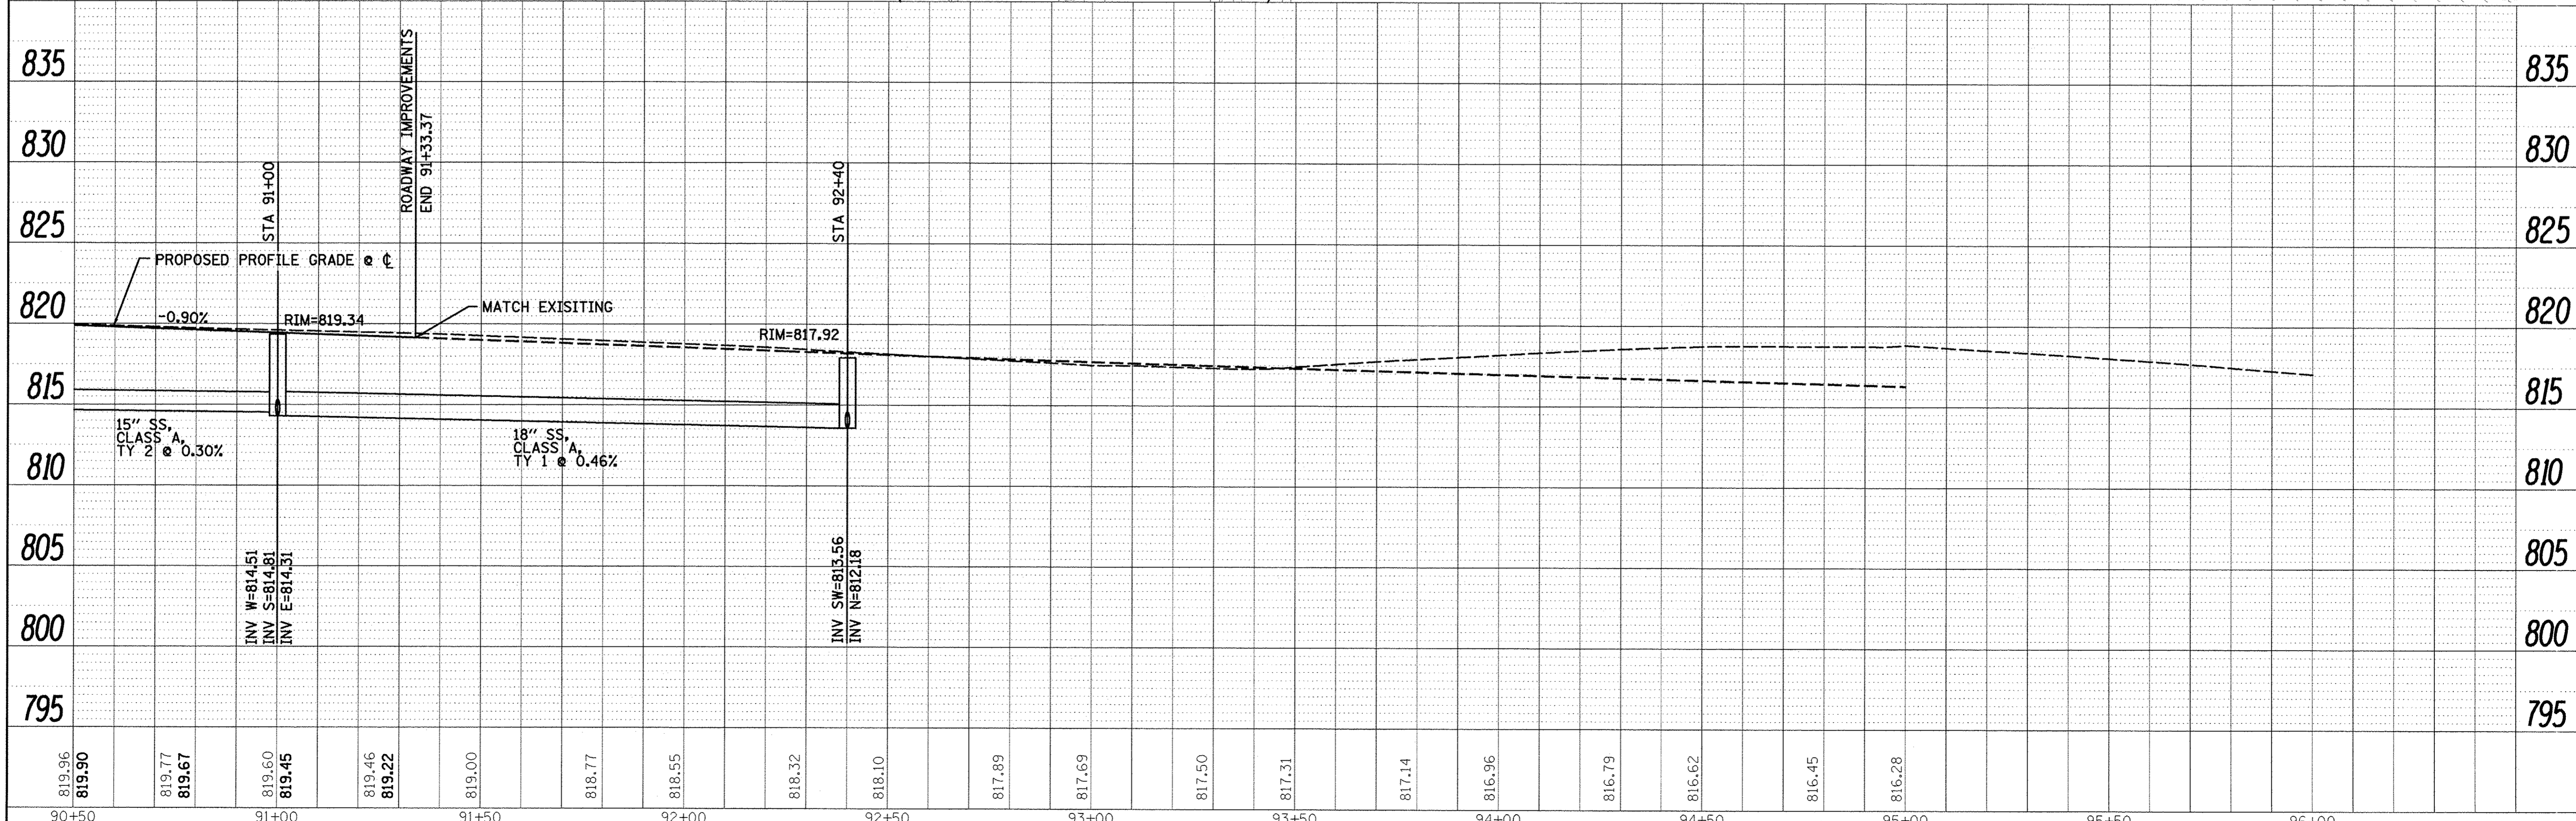
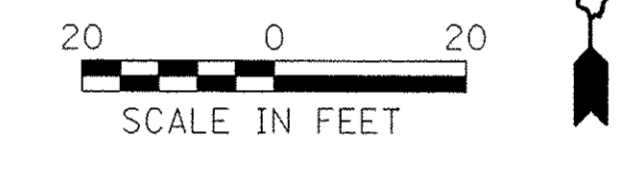


PLAN	SURVEYED	DATE
	PLOTTED	BY
	CHECKED	
	APPROVED	
	CAD FILE NAME	
	NO.	

PROFILE	SURVEYED	DATE
	PLOTTED	BY
	CHECKED	
	APPROVED	
	STRUCTURE NOTATION	
	NO.	

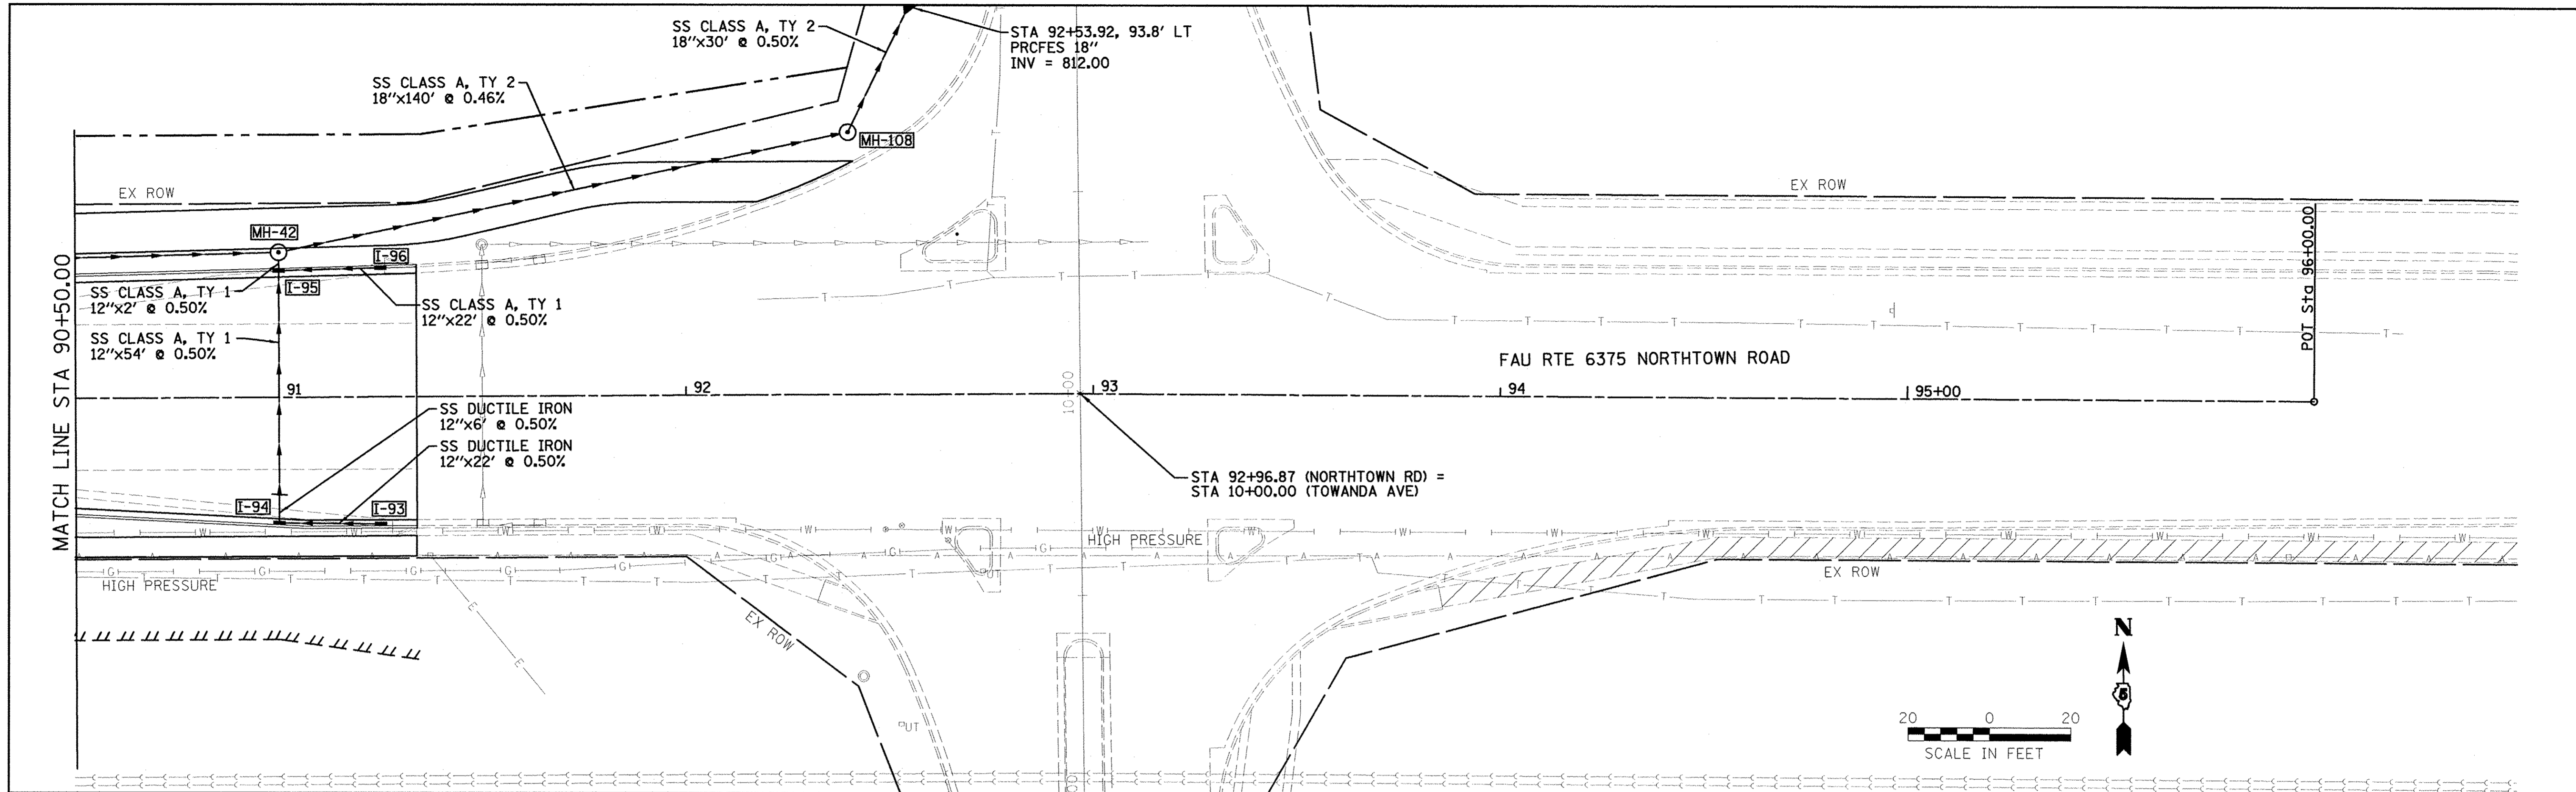

Farnsworth GROUP, INC. 2709 McGraw Drive Bloomington, Illinois 61704 309/663-8435, 309/663-1671 fax	DESIGNED - PJM	REVISED -	TOWN OF NORMAL NORTHTOWN ROAD FROM 1200' WEST OF LINDEN STREET TO TOWANDA AVENUE	DRAINAGE PLAN AND PROFILE	F.A.U. RTE. 6375	SECTION 00-00206-00-RP	COUNTY McLEAN	TOTAL SHEETS 129	SHEET NO. 71
	DRAWN - JJO/LAT	REVISED -			CONTRACT NO. 91479				
	CHECKED - PJM	REVISED -			ILLINOIS FED. AID PROJECT				
	DATE - 01/18/13	REVISED -		SCALE: SHEET OF SHEETS STA. 90+50.00 TO STA. 96+00.00					