
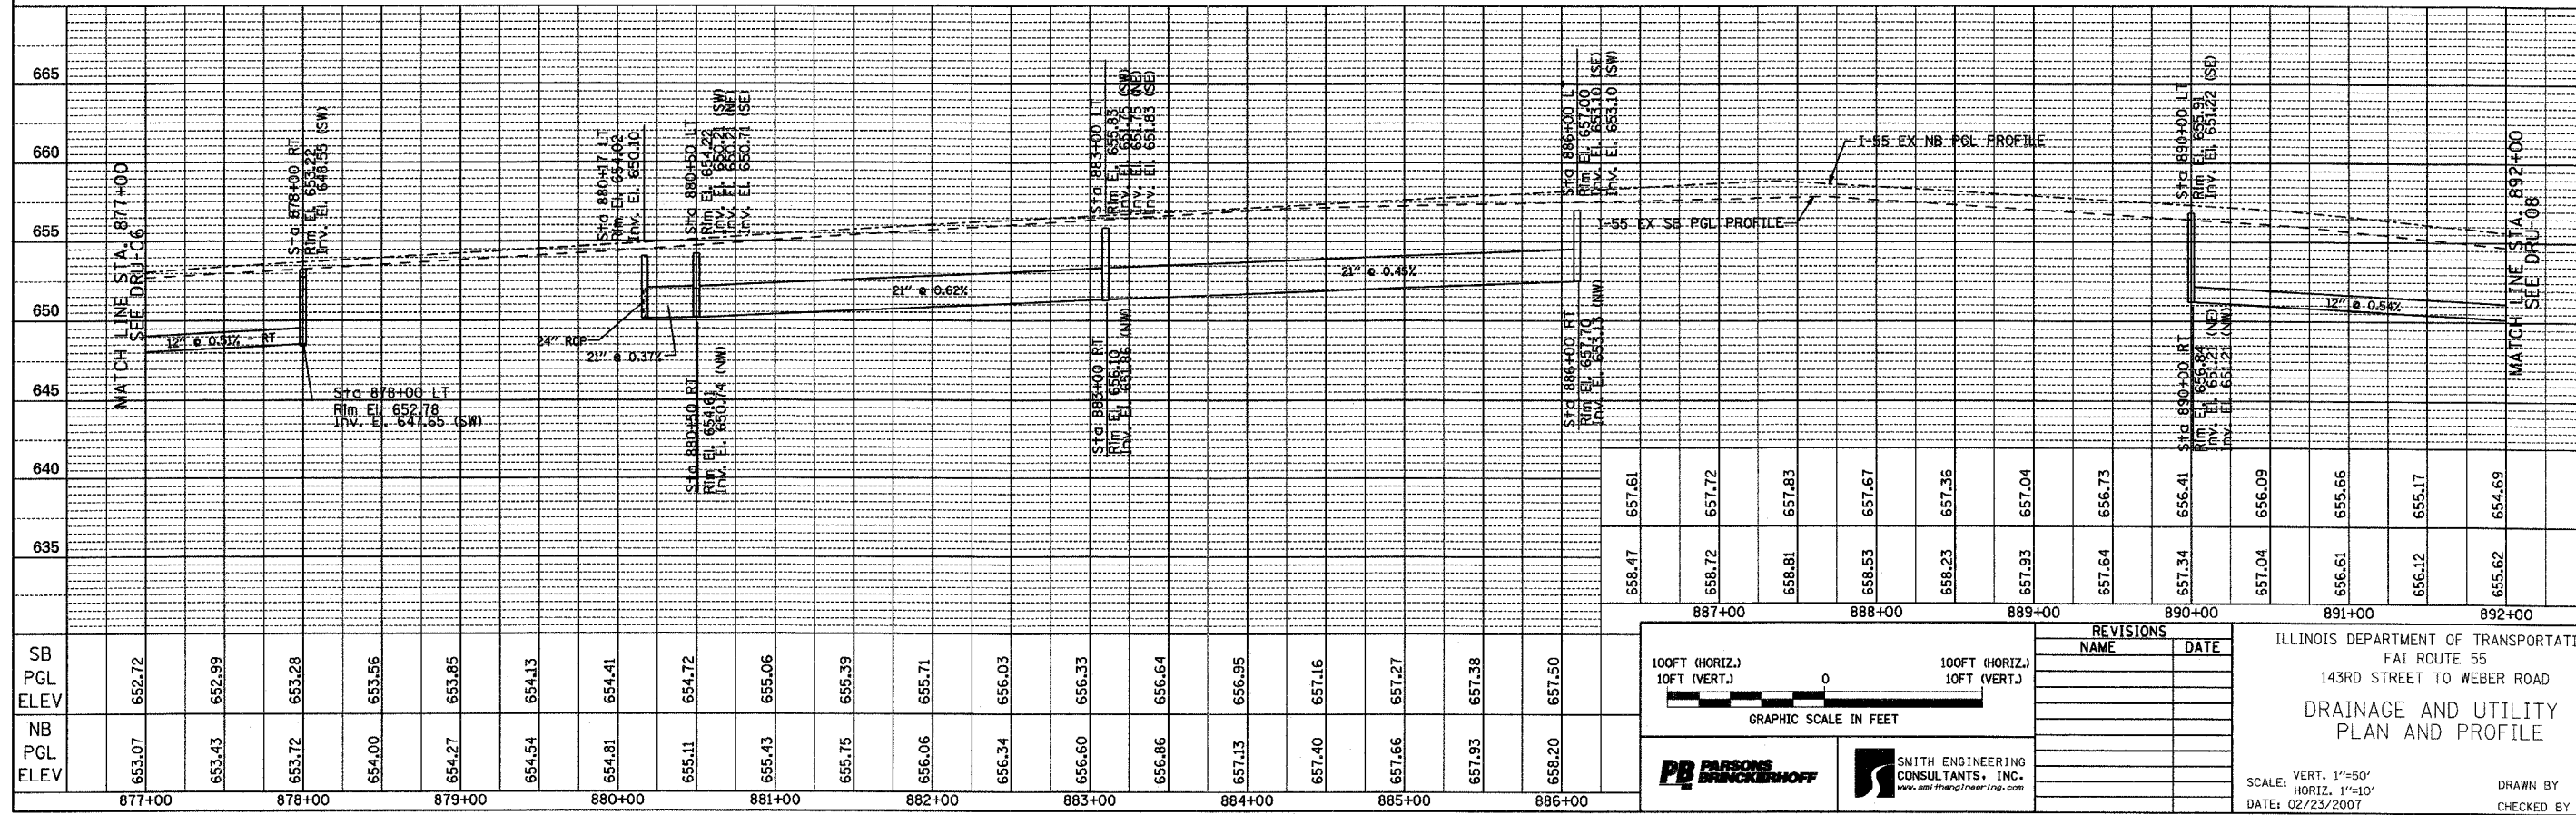


CONTRACT NO. 60B47				
F.A. RTE.	SECTION	COUNTY	TOTAL SHEETS	SHEET NO.
55	99 (I&2) WRS-3	WILL	305	112
STA. 877+00	TO STA. 892+00			
FED. ROAD DIST. NO.	ILLINOIS	FED. AID PROJECT		
DRU-07 OF 14				

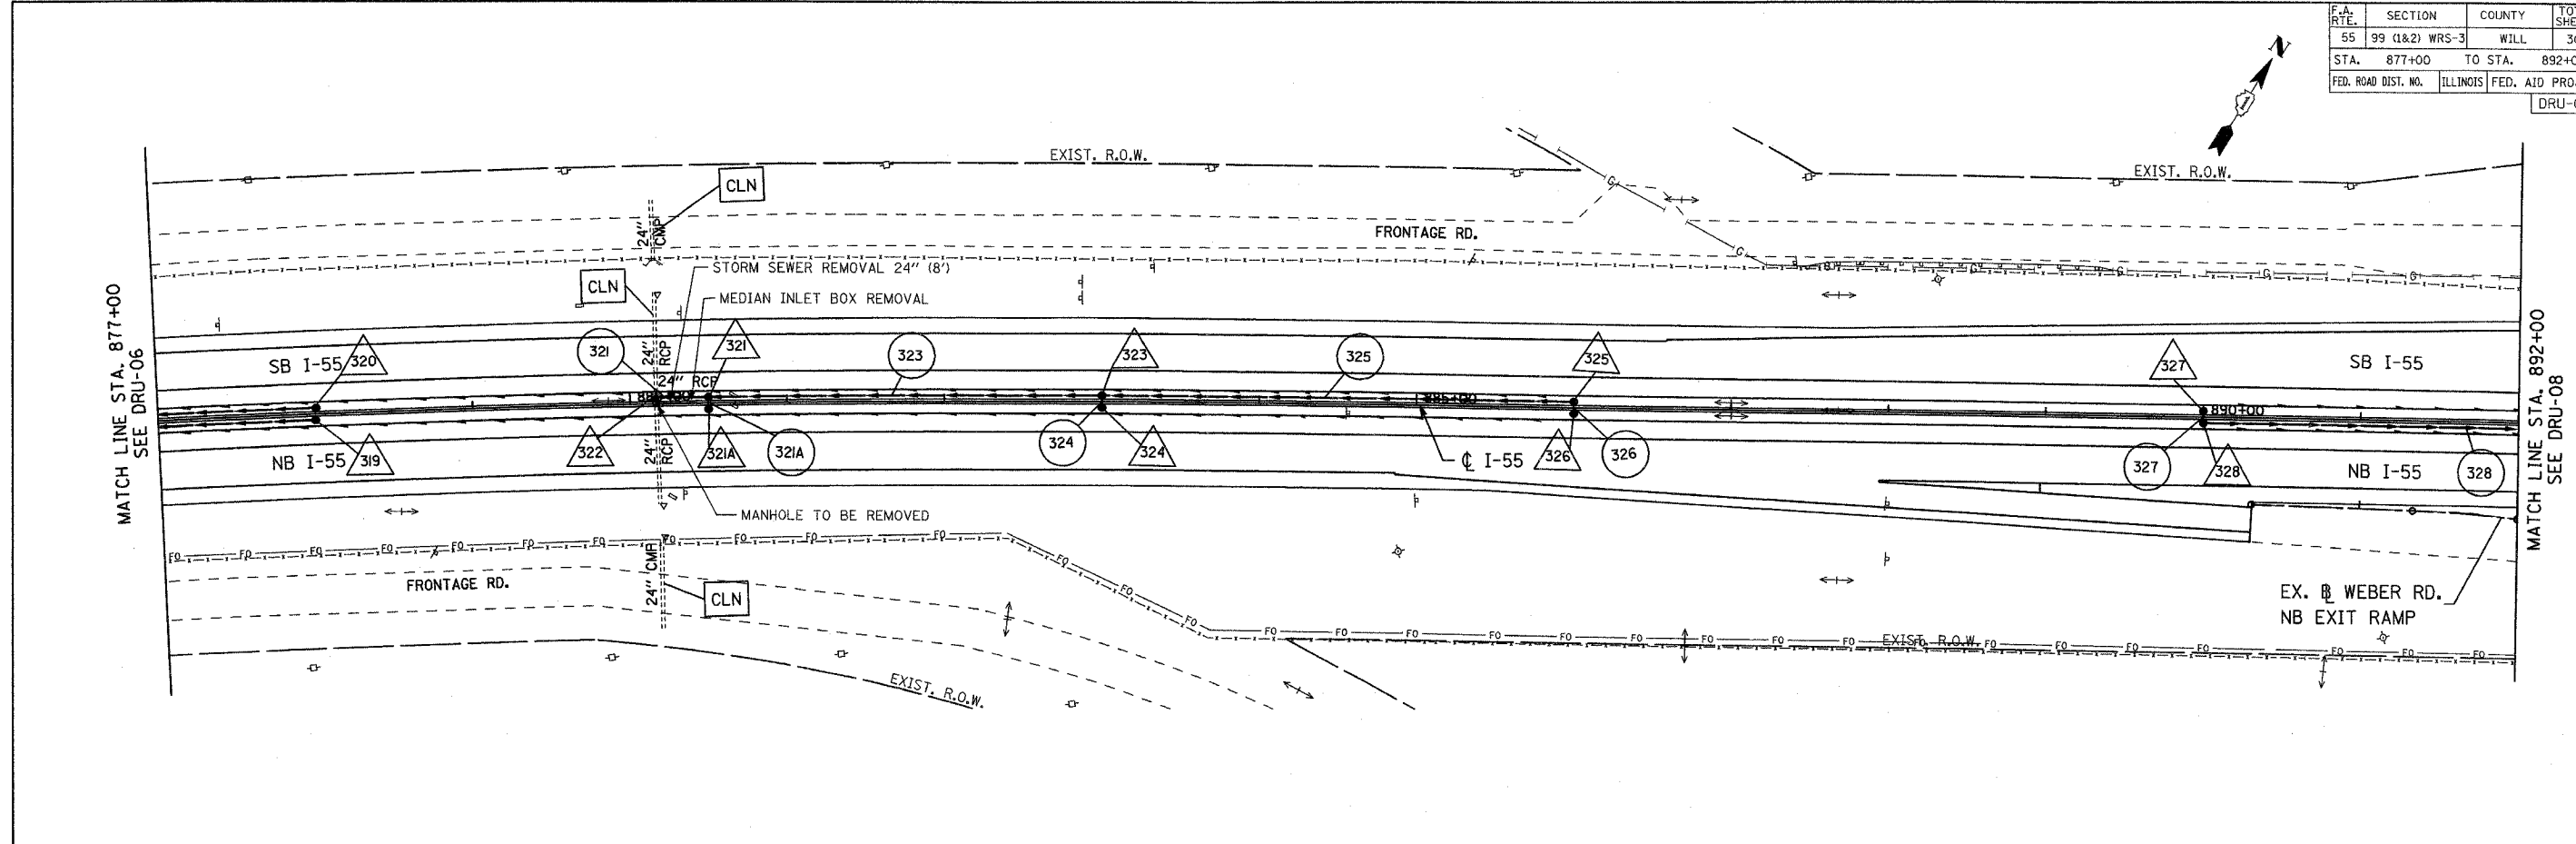

100FT (HORIZ.)
10FT (VERT.)

GRAPHIC SCALE IN FEET

REVISIONS

NAME	DATE

ILLINOIS DEPARTMENT OF TRANSPORTATION
FAI ROUTE 55
143RD STREET TO WEBER ROAD
DRAINAGE AND UTILITY
PLAN AND PROFILE

SCALE: VERT. 1"=50'
HORIZ. 1"=10'
DATE: 02/23/2007

SMITH ENGINEERING CONSULTANTS, INC.
www.smithengr.com

DRWN BY JPA
CHKD BY TEH

FINAL