 





F.A.I. RTE.	SECTION	COUNTY	TOTAL SHEETS	SHEET NO.
55	99 (I&S) WRS-3	WILL	305	169
STA. 907+00		TO STA. 922+00		
FED. ROAD DIST. NO. 1		ILLINOIS FED. AID PROJECT		
L-2 OF 13				

 

LEGEND

-  EXISTING HIGH MAST LIGHT TOWER
-  EXISTING DUCT
-  IDOT FIBER OPTIC CABLE



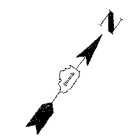NOTES:

1. CONTRACTOR TO USE EXTREME CAUTION EXCAVATING IN AREAS OF EXISTING OR PROPOSED UNIT DUCT AND EXISTING FIBER OPTIC CABLE. CONTRACTOR SHALL PROTECT EXISTING CABLE DUCT AS NEEDED DURING EXCAVATION, TRENCHING, PLOWING, GUARDRAIL INSTALLATION, FOUNDATION INSTALLATION, AND PAVING ACTIVITIES.

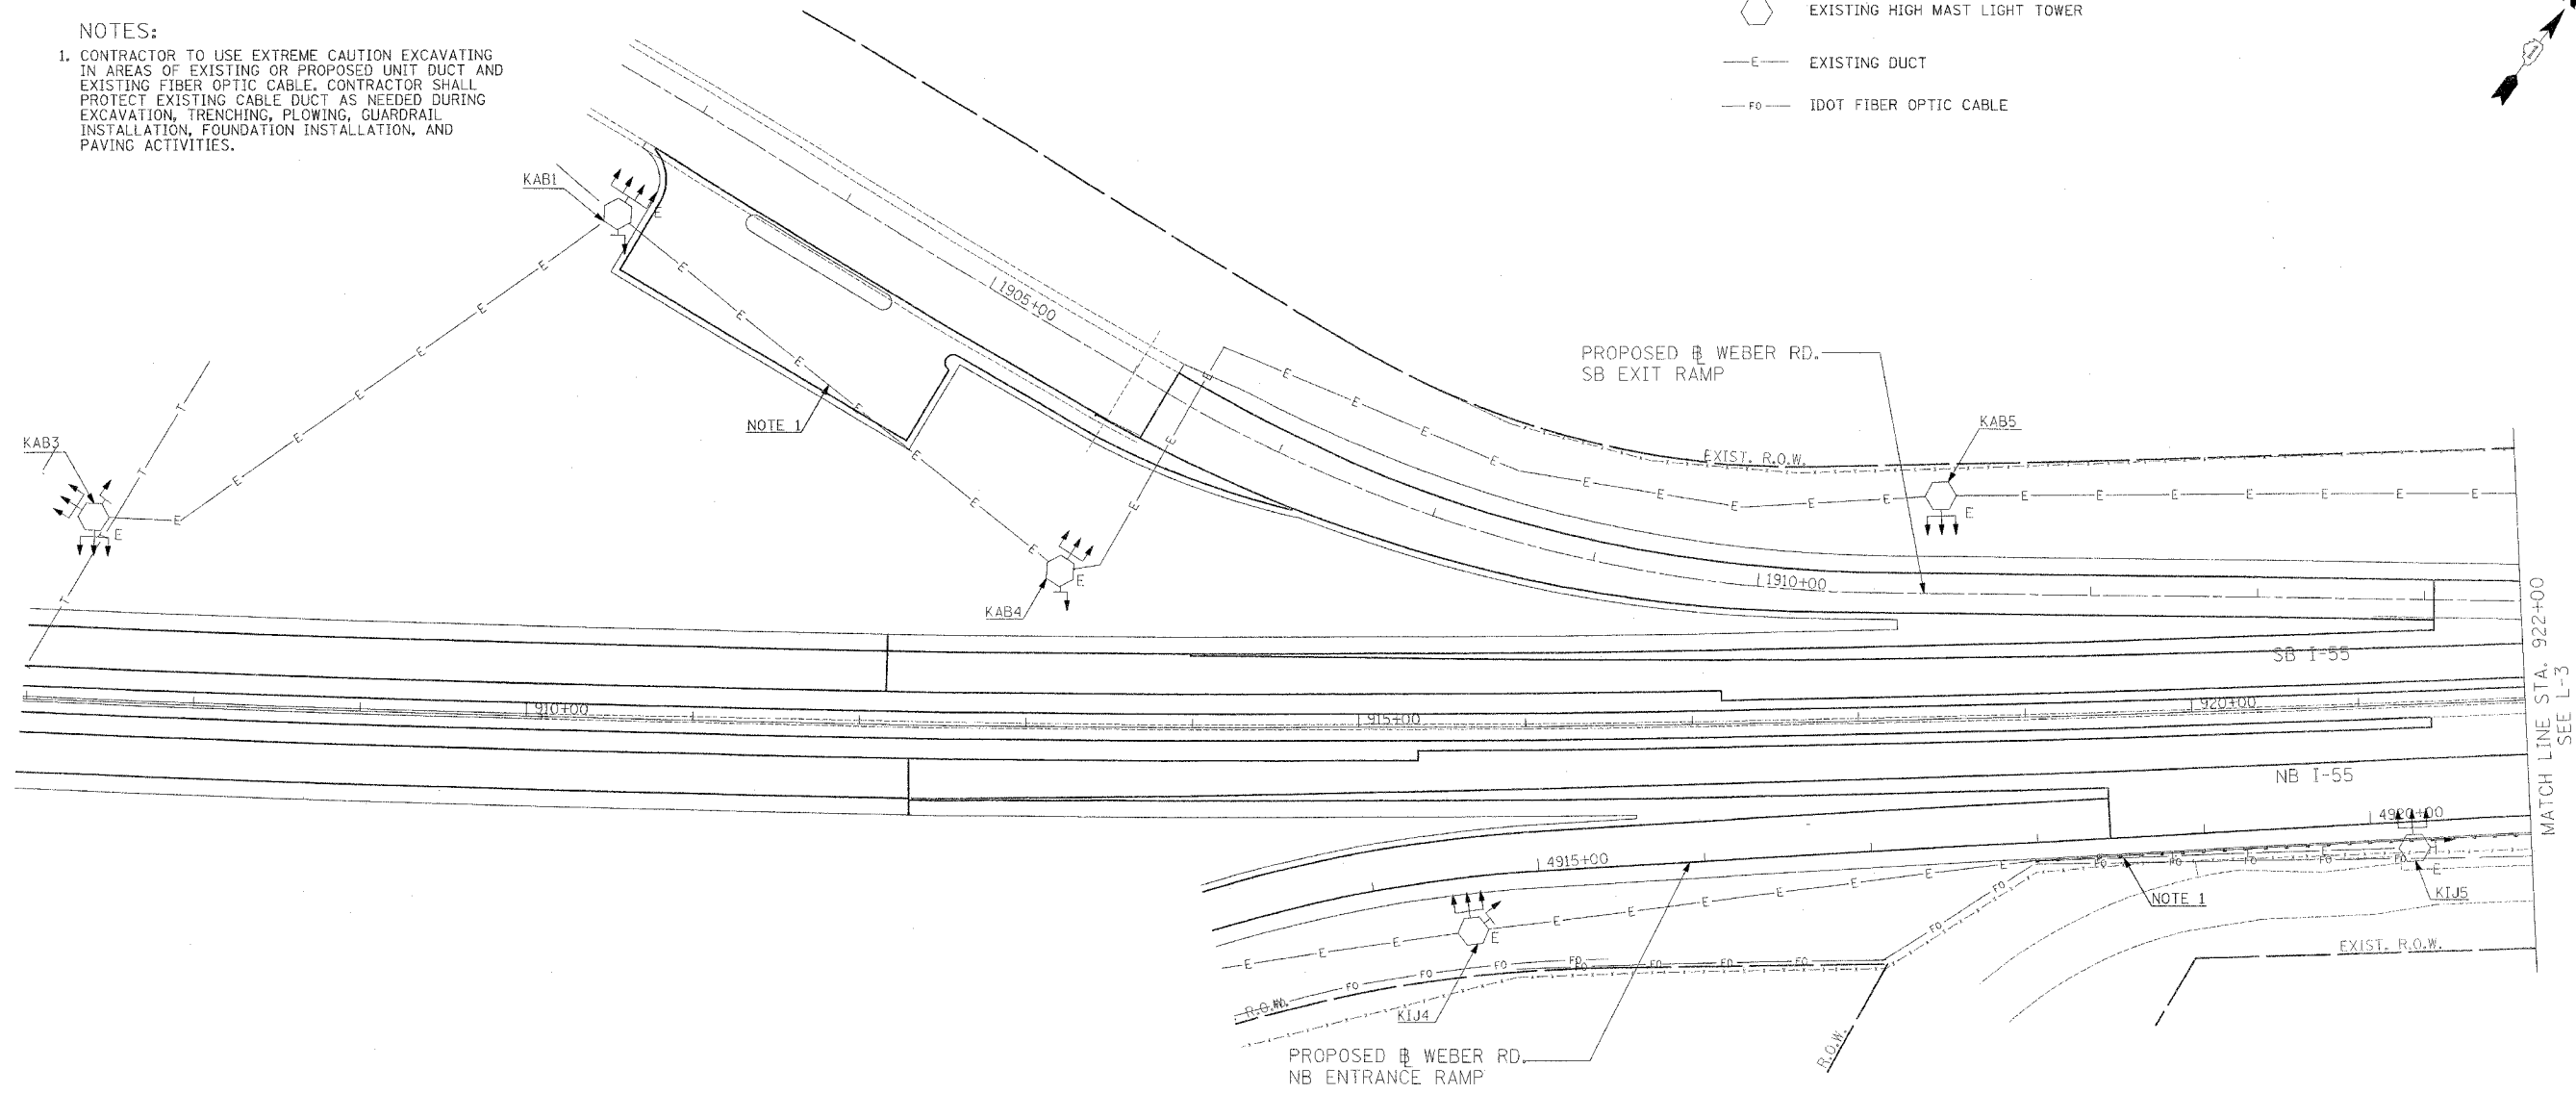

REVISIONS	
NAME	DATE

ILLINOIS DEPARTMENT OF TRANSPORTATION
 F.A.I. I-55
 143rd STREET TO WEBER ROAD
 EXISTING LIGHTING PLAN

SCALE: 1" = 50'
 DATE: 02-23-07

DRAWN BY: VG
 CHECKED BY: PV

SINGH
 SINGH & ASSOCIATES, INC.
 CONSULTING ENGINEERS

PB PARSONS BRINCKERHOFF

L-2

FINAL