


*REF-drain05
*REF-drain06

CONTRACT NO. 62719

| F.A.P. R.T.E. | SECTION | COUNTY | TOTAL SHEETS | SHEET NO. |
|---------------------|---------------------------|--------|--------------|-----------|
| 344 | 3034N-1 | COOK | 71 | 15 |
| STA. | TO STA. | | | |
| FED. ROAD DIST. NO. | ILLINOIS FED. AID PROJECT | | | |


- EXISTING**
- R** STRUCTURE TO BE REMOVED
 - AB** STORM SEWER TO BE PLUGGED AND ABANDONED
 - ADJ** STRUCTURE TO BE ADJUSTED
 - REL** RELOCATE STORM SEWER

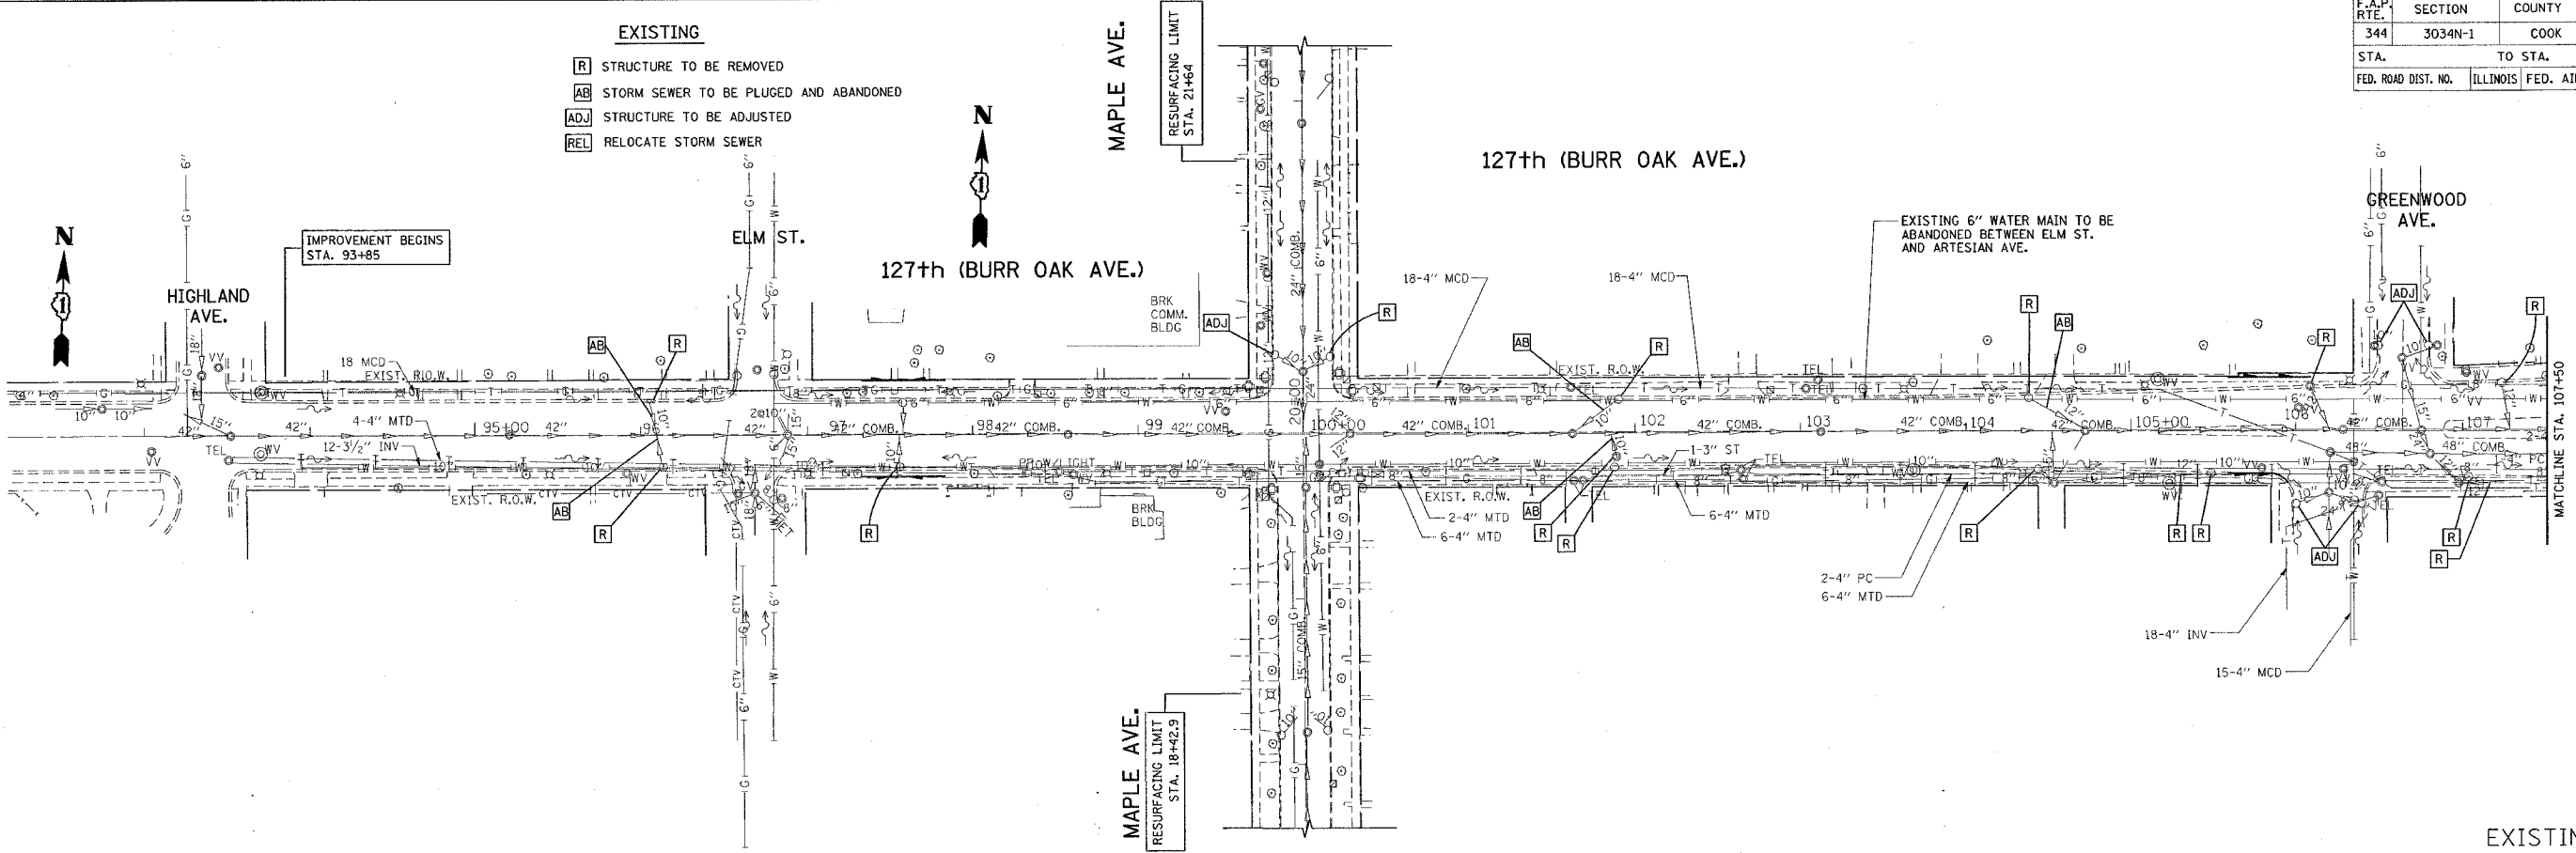

EXISTING

PROPOSED

- CATCH BASIN
- MANHOLE
- STORM SEWER

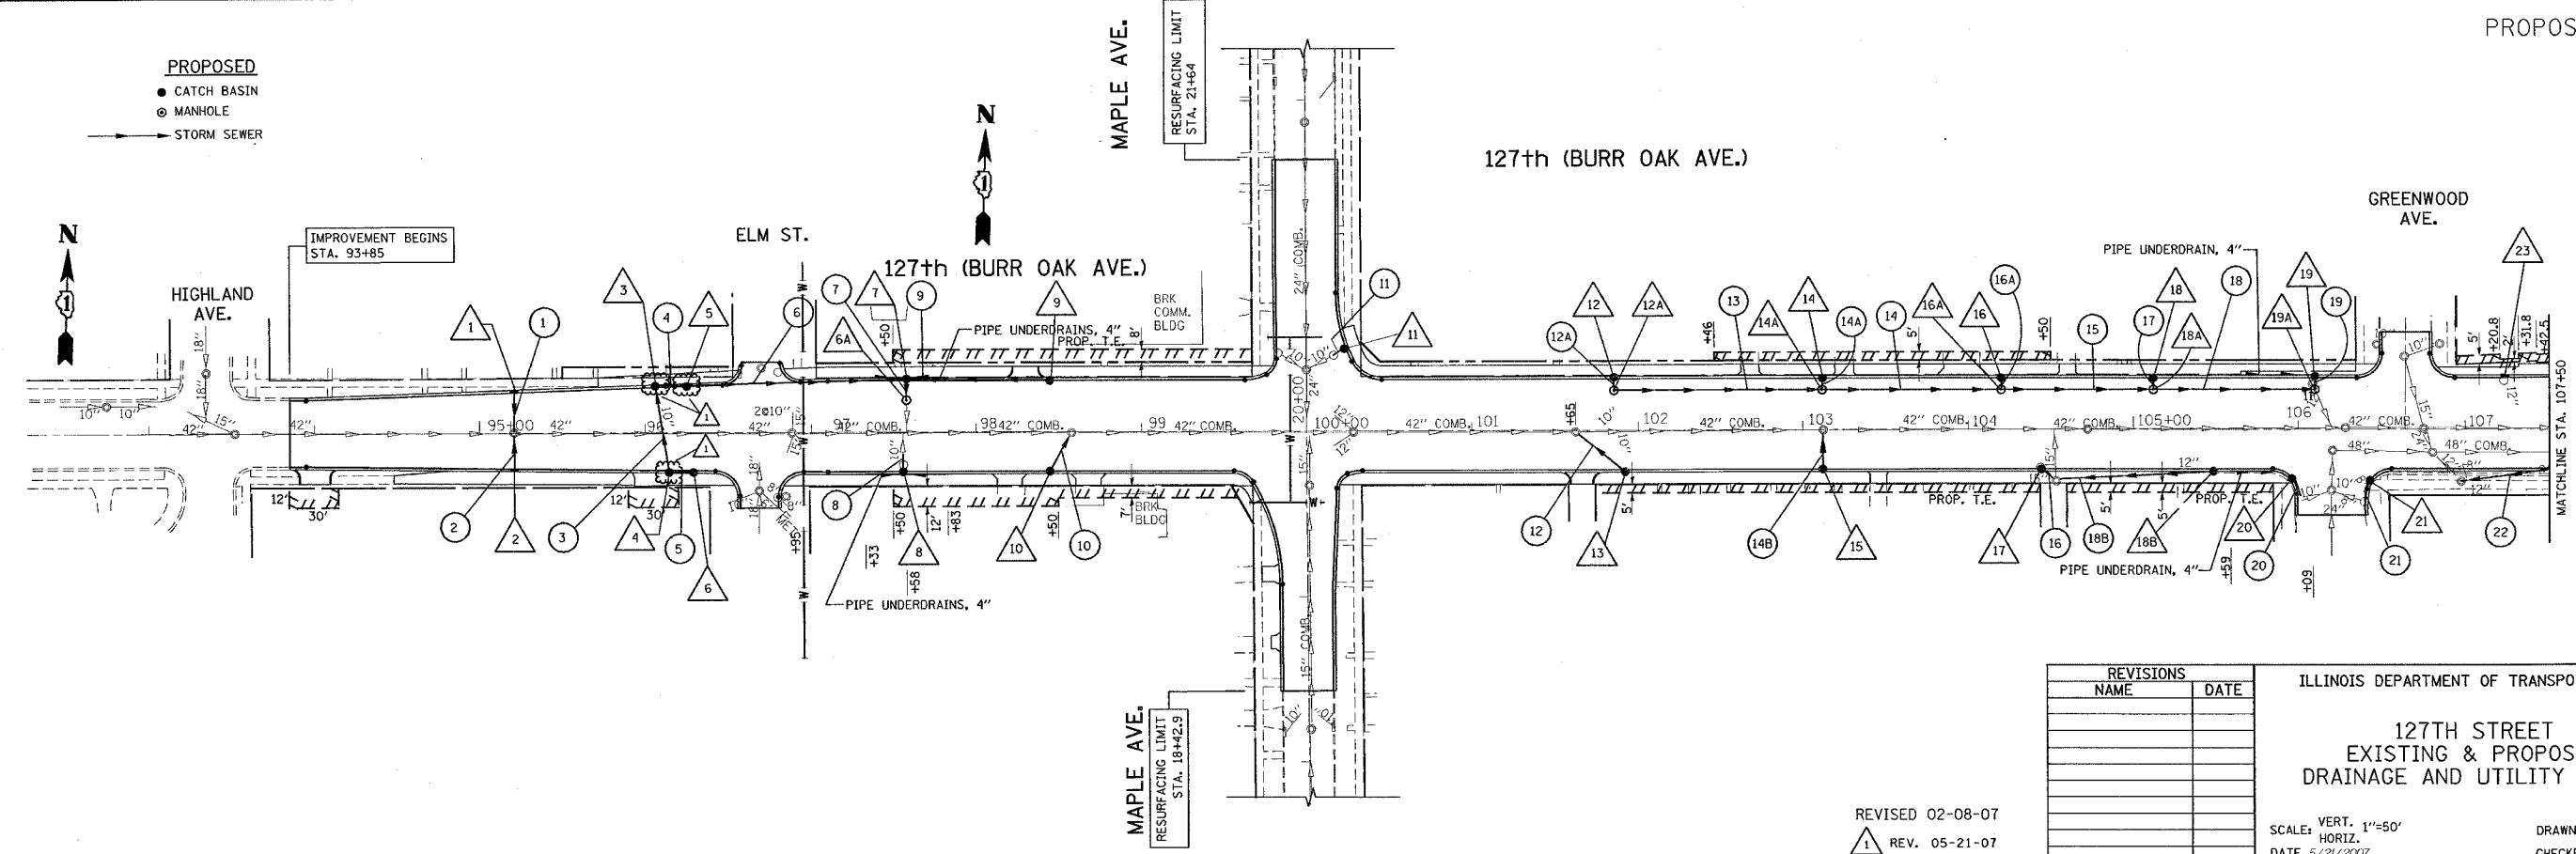

PROPOSED

| REVISIONS | |
|-----------|------|
| NAME | DATE |
| | |
| | |
ILLINOIS DEPARTMENT OF TRANSPORTATION

127TH STREET
EXISTING & PROPOSED
DRAINAGE AND UTILITY PLANS

SCALE: VERT. 1"=50'
HORIZ. DATE 5/21/2007

DRAWN BY
CHECKED BY

REVISED 02-08-07
△ REV. 05-21-07

PLOT DATE = 5/21/2007
FILE NAME = K:\100405\127th.drain.dgn
PLOT SCALE = 50.0000 / IN.
USER NAME = jays