


\*REF-drain07  
\*REF-drain07-1

CONTRACT NO. 62719

| F.A.P. RTE.         | SECTION | COUNTY                    | TOTAL SHEETS | SHEET NO. |
|---------------------|---------|---------------------------|--------------|-----------|
| 344                 | 3034N-1 | COOK                      | 71           | 17        |
| STA.                |         | TO STA.                   |              |           |
| FED. ROAD DIST. NO. |         | ILLINOIS FED. AID PROJECT |              |           |

**EXISTING**


- [R] STRUCTURE TO BE REMOVED
- [AB] STORM SEWER TO BE PLUGGED AND ABANDONED
- [ADJ] STRUCTURE TO BE ADJUSTED
- [REL] RELOCATE STORM SEWER

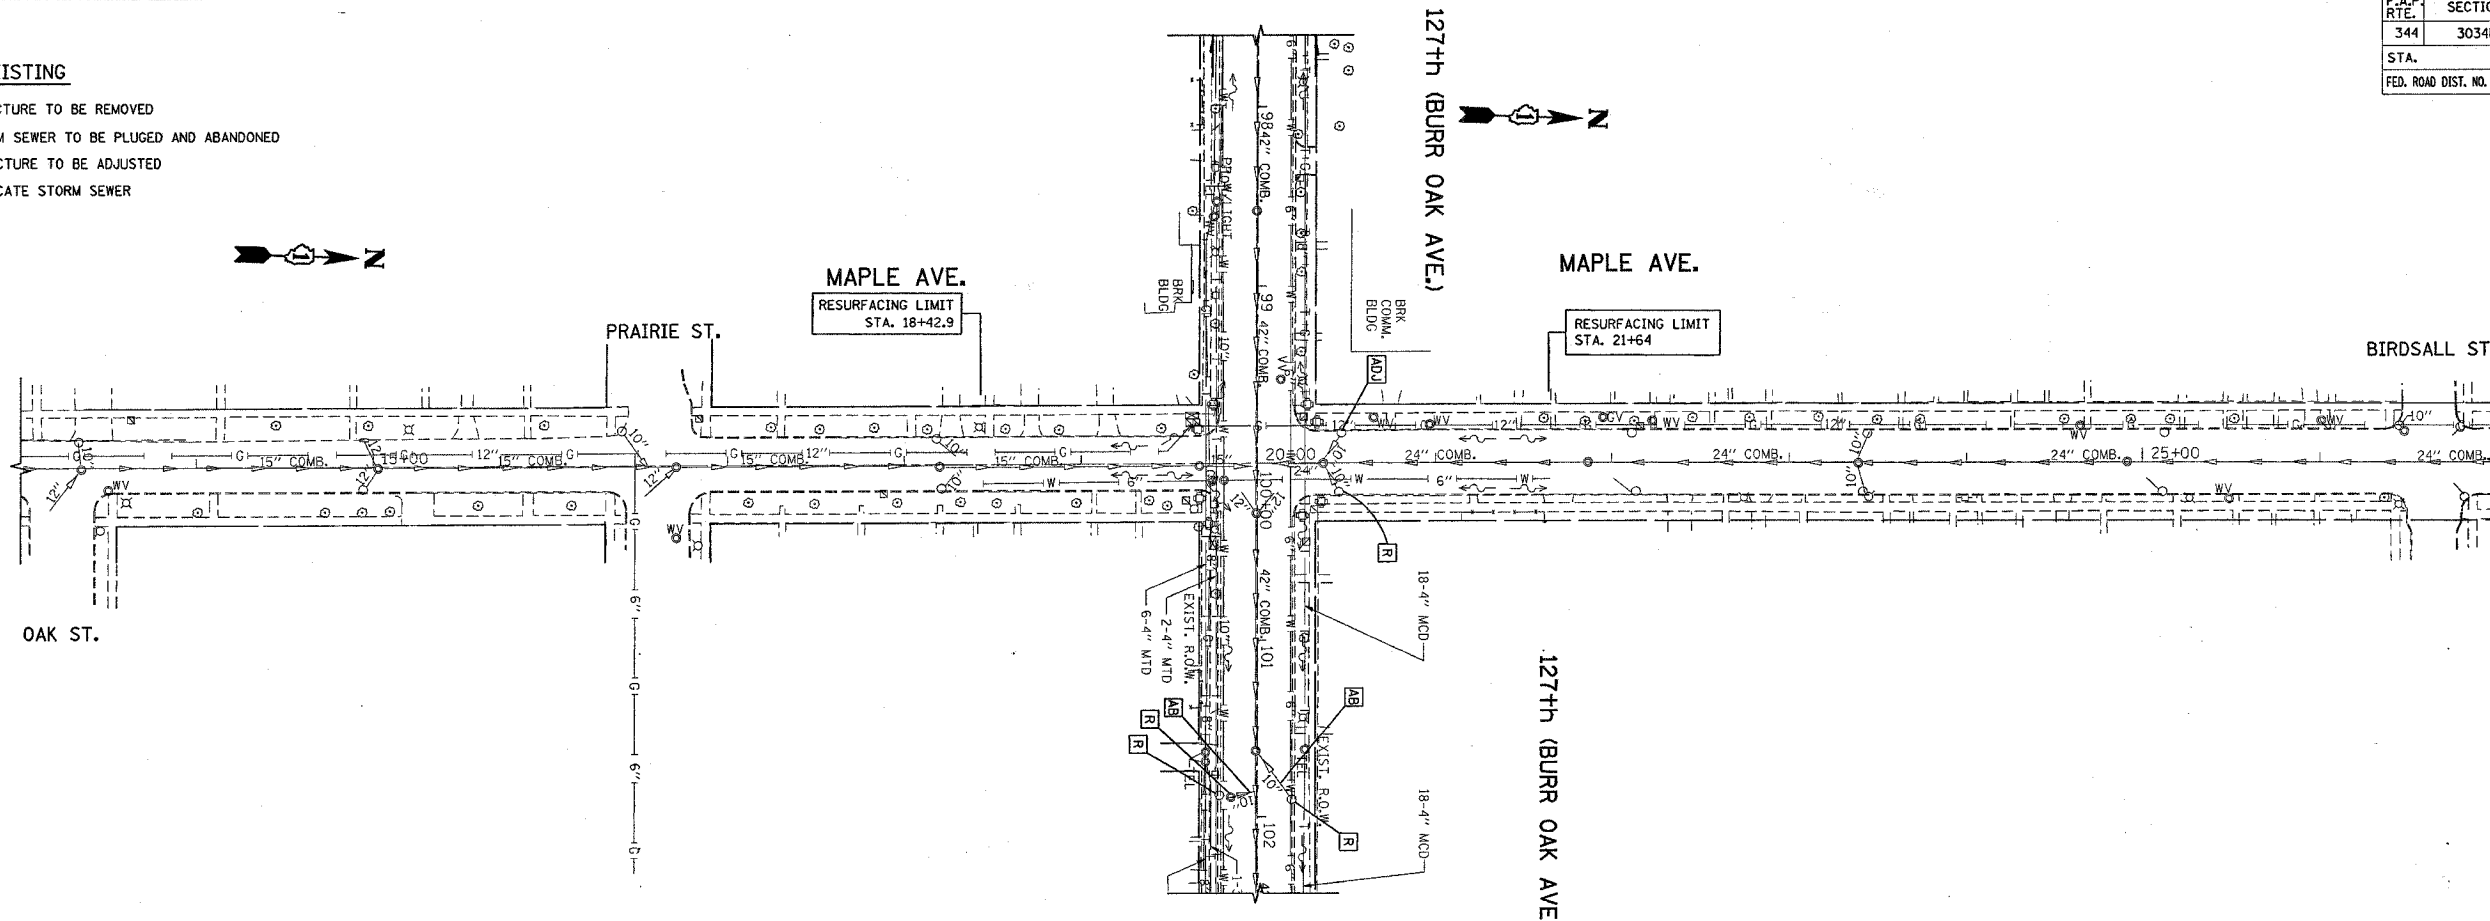

EXISTING

**PROPOSED**

- CATCH BASIN
- MANHOLE
- STORM SEWER

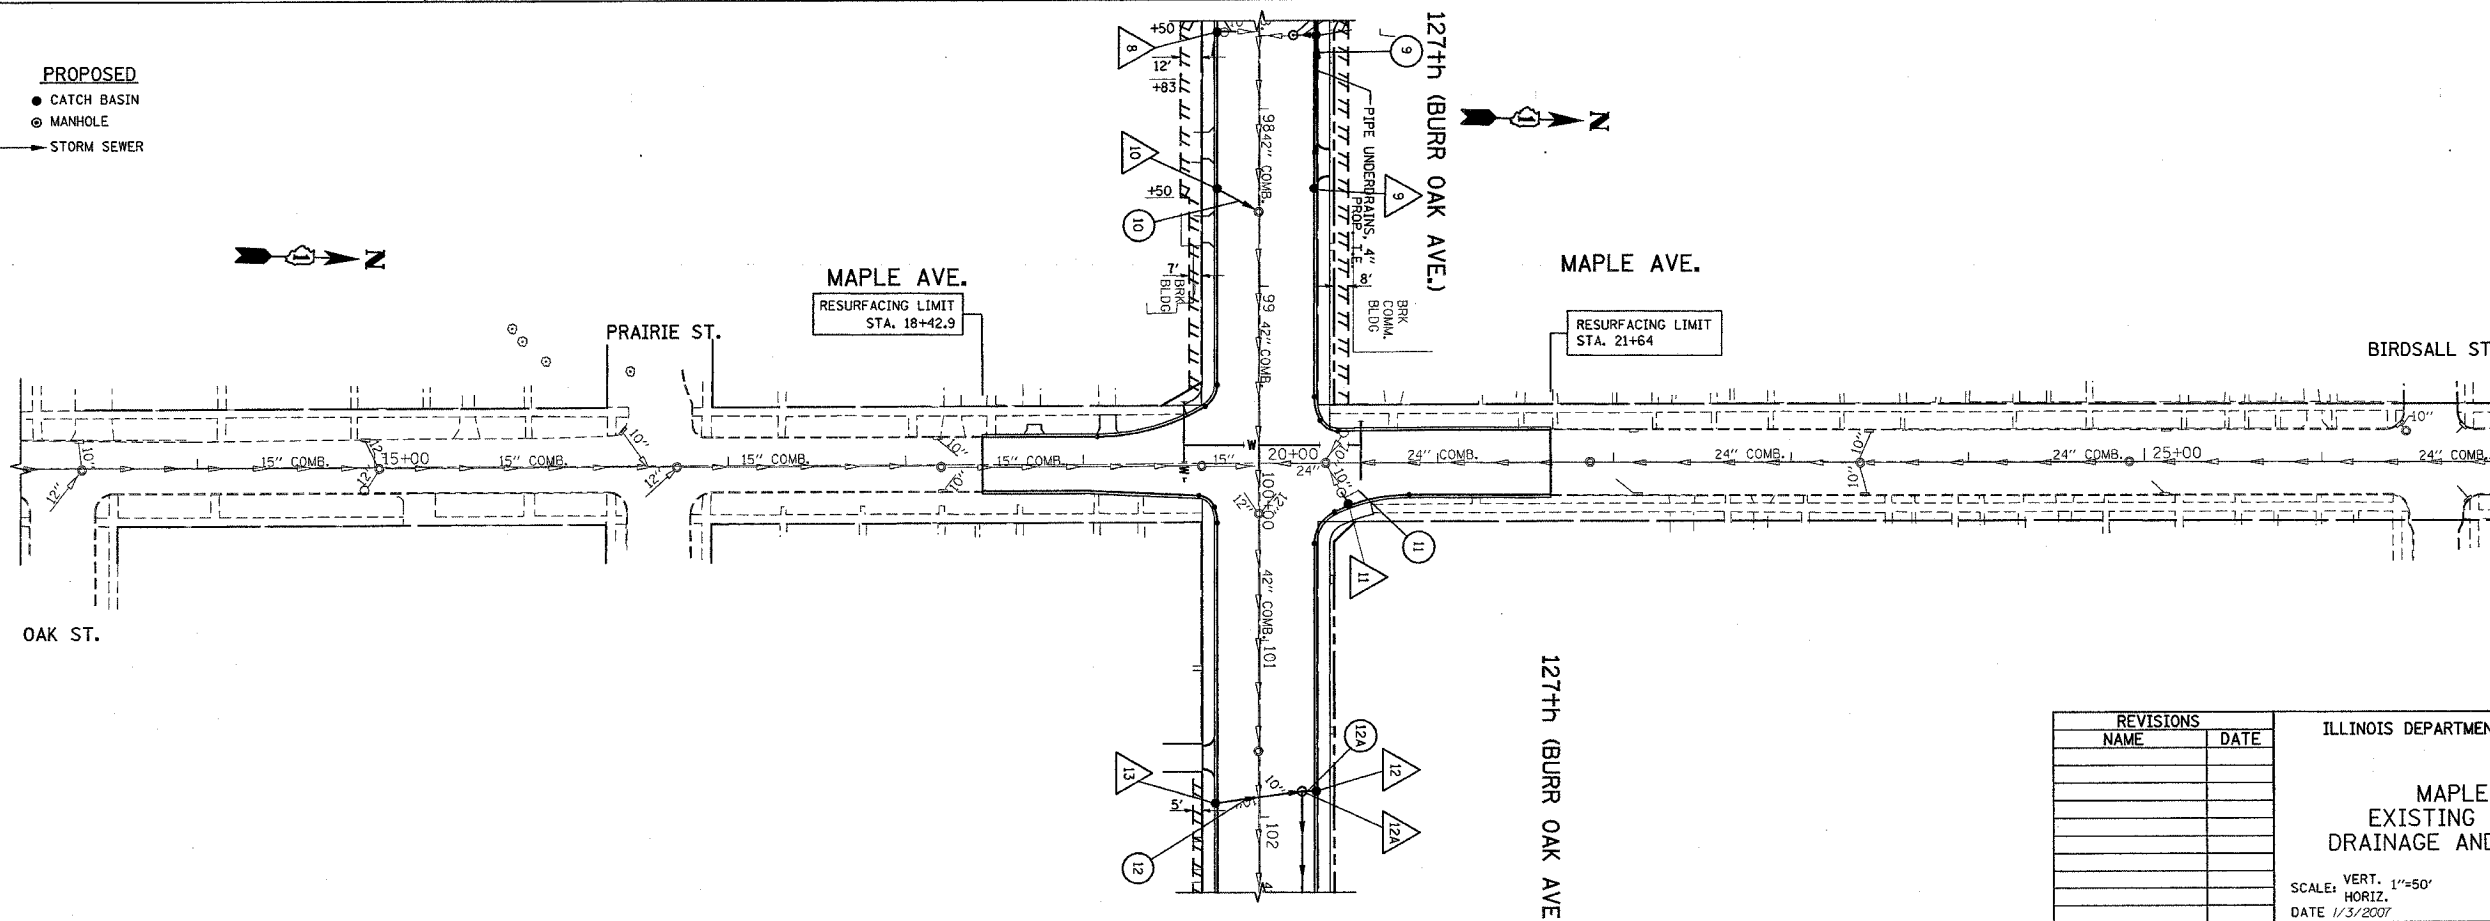

PROPOSED

| REVISIONS |      |
|-----------|------|
| NAME      | DATE |
|           |      |
|           |      |
ILLINOIS DEPARTMENT OF TRANSPORTATION

**MAPLE AVENUE  
EXISTING & PROPOSED  
DRAINAGE AND UTILITY PLAN**

SCALE: VERT. 1"=50'  
HORIZ. 1"=50'  
DATE 1/3/2007

DRAWN BY  
CHECKED BY

PLOT DATE = 1/3/2007  
FILE NAME = c:\projects\62719\62719.dwg  
PLOT SCALE = 1"=50'  
USER NAME = drwkskgn