
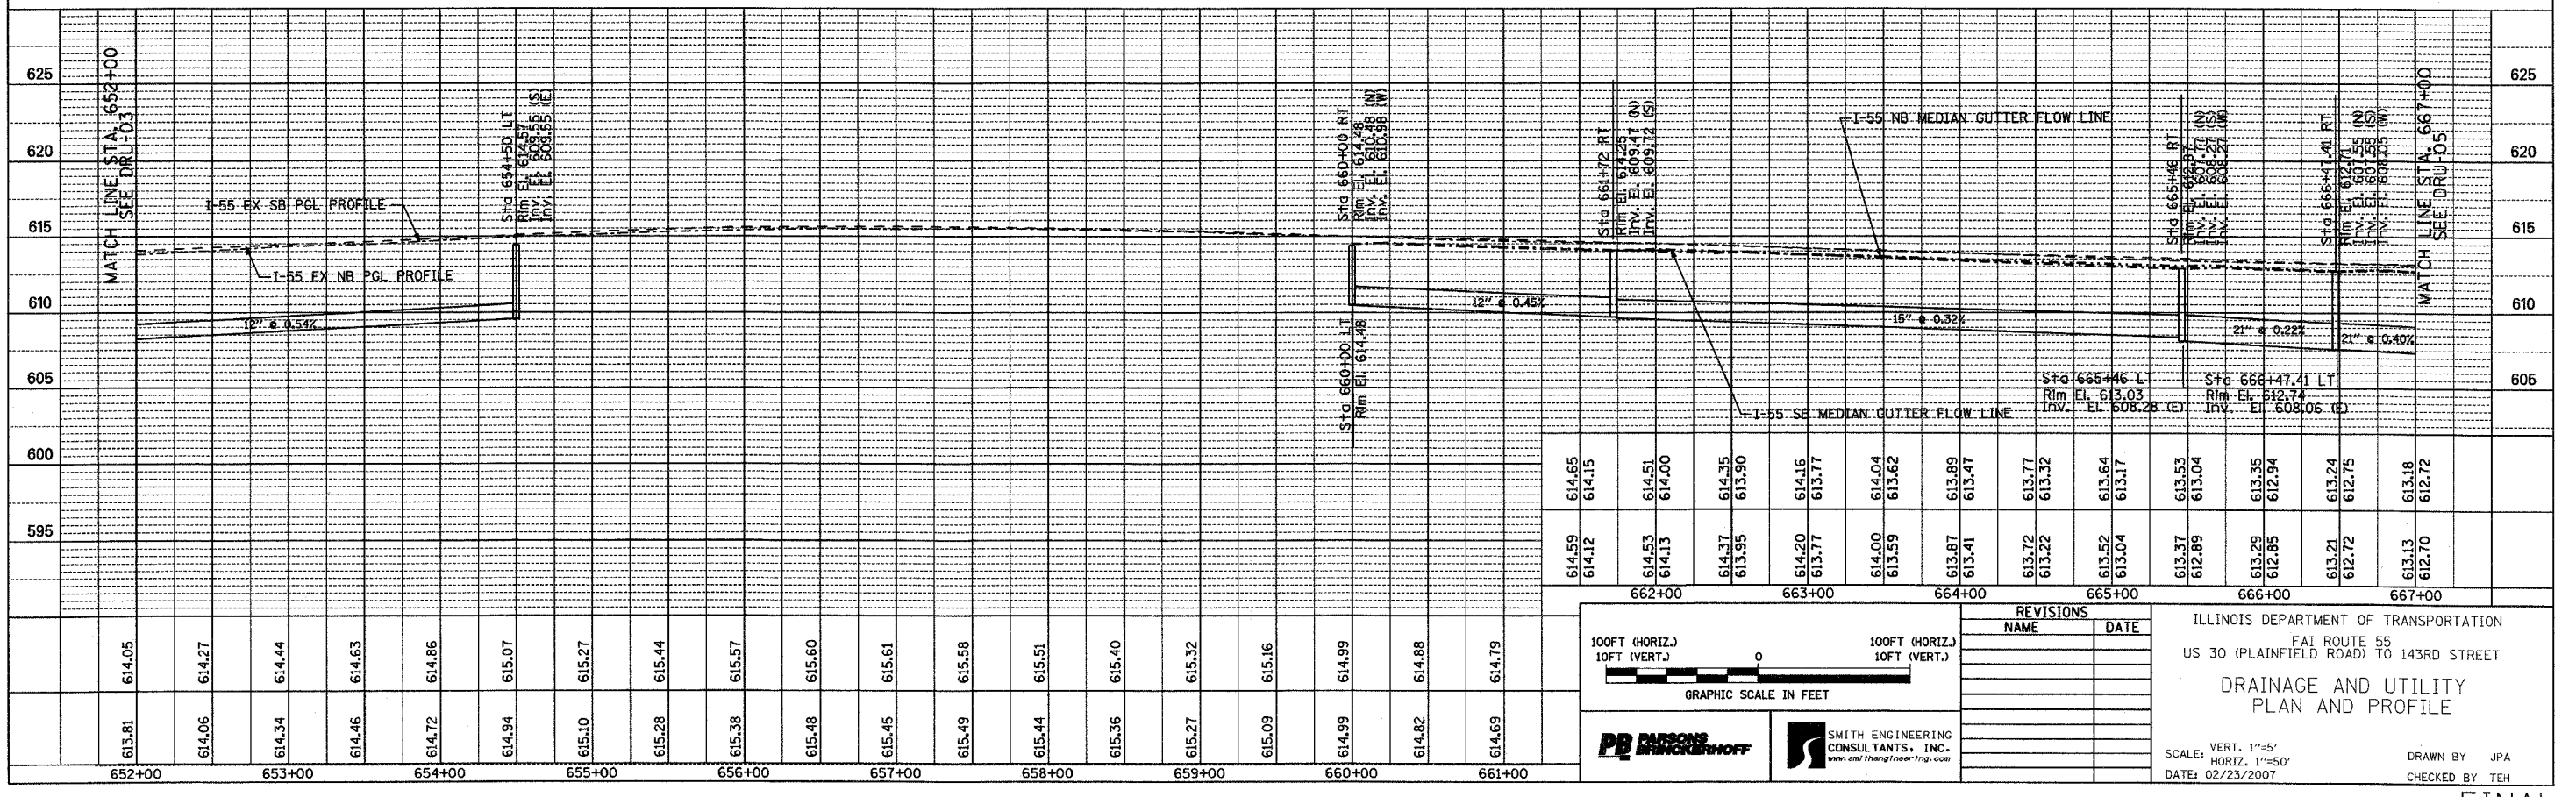


CONTRACT NO. 62896				
F.A. RTE.	SECTION	COUNTY	TOTAL SHEETS	SHEET NO.
55	99 (I&2) WRS-1	WILL	227	89
STA. 652+00		TO STA. 667+00		
FED. ROAD DIST. NO.		ILLINOIS FED. AID PROJECT		
DRU-04 OF 10				

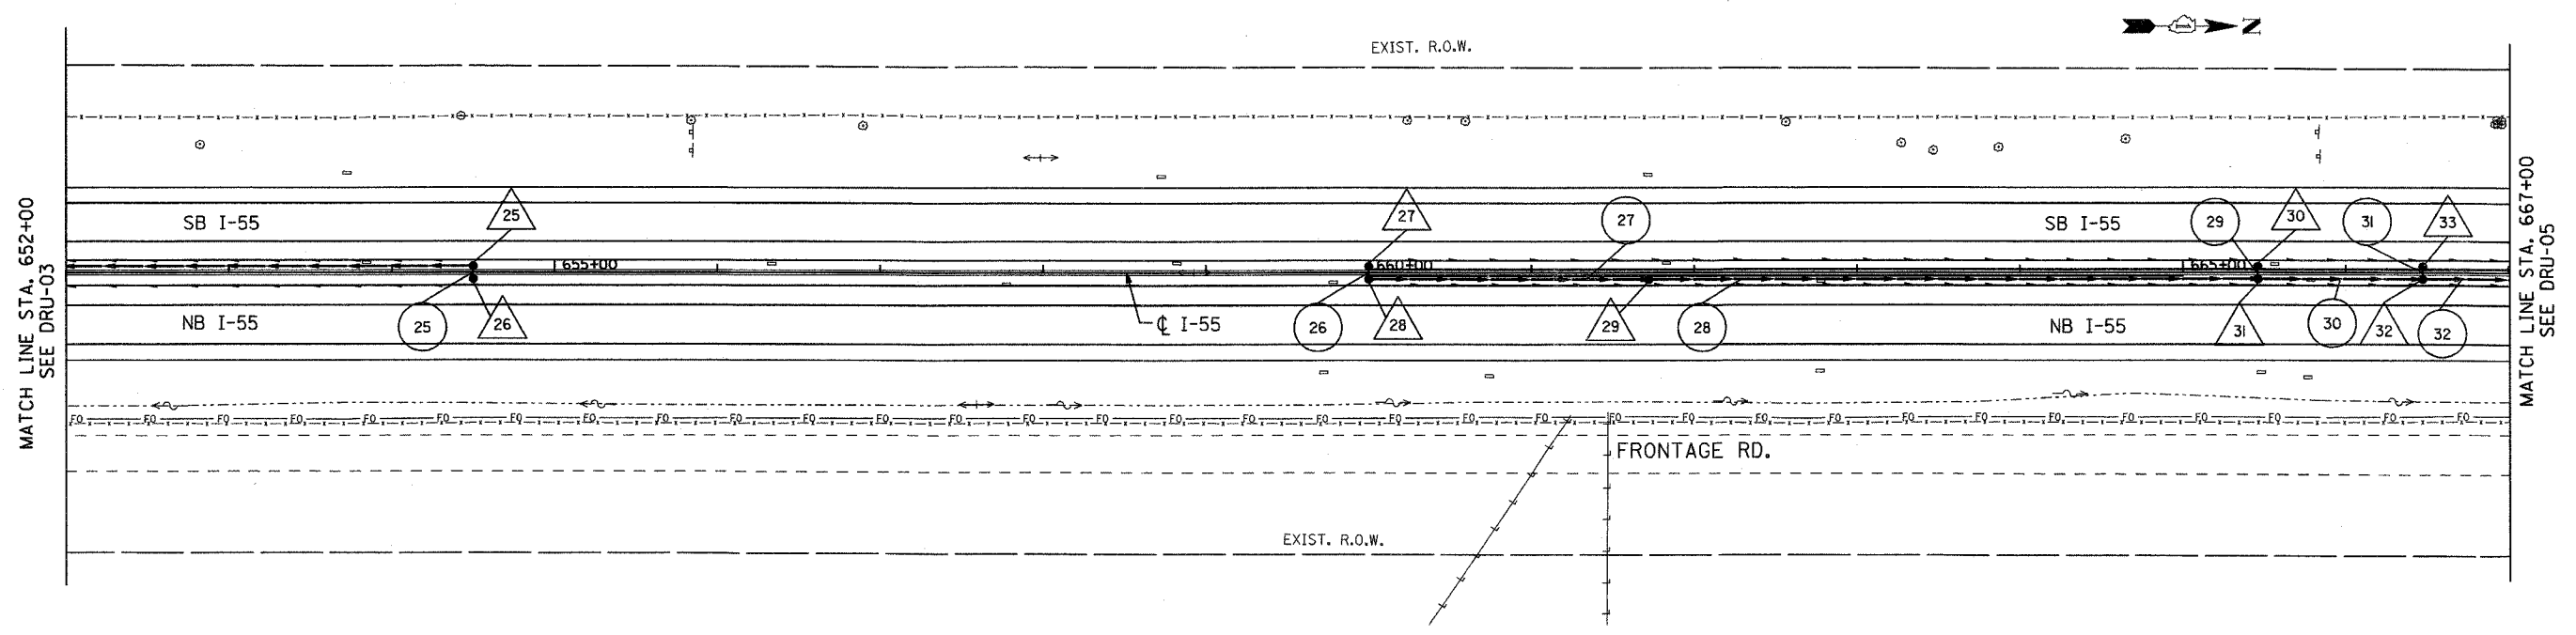

100FT (HORIZ.)
10FT (VERT.)

GRAPHIC SCALE IN FEET

REVISIONS

NAME	DATE

ILLINOIS DEPARTMENT OF TRANSPORTATION
FAI ROUTE 55
US 30 (PLAINFIELD ROAD) TO 143RD STREET
DRAINAGE AND UTILITY
PLAN AND PROFILE

SCALE: VERT. 1"=5'
HORIZ. 1"=50'
DATE: 02/23/2007

SMITH ENGINEERING CONSULTANTS, INC.
www.smithengr.com

DRAWN BY: JPA
CHECKED BY: TEH

FINAL