

93437

ROUTE	PSBA PROJECT NO.	SECTION	COUNTY	SHEET NO.	TOTAL SHEETS
FAS-1600	R-01-023	05-00012-00-RS	HANCOCK	1	43

INDEX OF SHEETS

NUMBER	DESCRIPTION
1	COVER SHEET
2	GENERAL NOTES
3	SUMMARY OF QUANTITIES
4-8	TYPICAL CROSS SECTIONS
9-12	DETAIL DRAWINGS
13-15	QUANTITY TABULATIONS
16-35	PLAN AND PROFILE SHEETS
36-43	CROSS SECTIONS

HIGHWAY STANDARDS

424001-04	701001-01
	701006-02
601001-01	701011-01
601101	701201-02
602301-01	701301-02
602306-01	701306-01
604006-02	701311-02
604036-01	701501-03
606001-03	701801-03
606101-02	702001-06
606201-01	780001-01
606206-02	

 
UTILITY COMPANIES

- MEDIACOM (CABLE TV)
TEL: 319-524-1186
- AMEREN / CIPS (ELECTRICITY)
TEL: 217-323-6438
- FRONTIER (TELEPHONE)
TEL: 217-854-2222
- NICOR (GAS)
TEL: 630-388-2362
- CITY OF WARSAW (WATER / SEWER)
TEL: 217-256-4512

J.U.L.I.E.
JOINT UTILITY LOCATION INFORMATION FOR EXCAVATION
1-800-892-0123

2017 (MID-LIFE) ADT: 3,169 VPD
DESIGN SPEEDS:
STATION 0+22.79 - 41+50: 30 M.P.H.
STATION 41+50 - 45+10: 45 M.P.H.
STATION 45+10 - 109+48.56: 55 M.P.H.

GRAPHIC SCALE IN FEET FOR PLANS SHEETS 16 - 35
SCALE: 1" = 40' FOR HALF-SIZE (11x17) DRAWINGS



PSBA
POEPPING, STONE, BACH & ASSOCIATES, INC.
ARCHITECTS ENGINEERS PLANNERS SURVEYORS

3525 MAIN ST., P.O. BOX 817 • NEDUNK, IA 52632 • 319/524-8730
100 SOUTH 5th, P.O. BOX 709 • QUINCY, IL 62306 • 217/223-4605
801 BROADWAY, P.O. BOX 190 • HANNIBAL, MO 63401 • 573/406-0941

STATE OF ILLINOIS
DEPARTMENT OF TRANSPORTATION
DIVISION OF HIGHWAYS

PROPOSED HIGHWAY PLANS


SURFACE TRANSPORTATION PROGRAM
HIGH PRIORITY PROJECT WITH TARP
CITY OF WARSAW, HANCOCK COUNTY, ILLINOIS

FAS ROUTE: 1600
SECTION NUMBER: 05-00012-00-RS
PROJECT NUMBER: HPP-0115(061)
JOB NUMBER: C-96-219-07


PROJECT LOCATION

END 109+48.56
START 0+22.79

T-4-N, R-9-W, 4TH P.M.

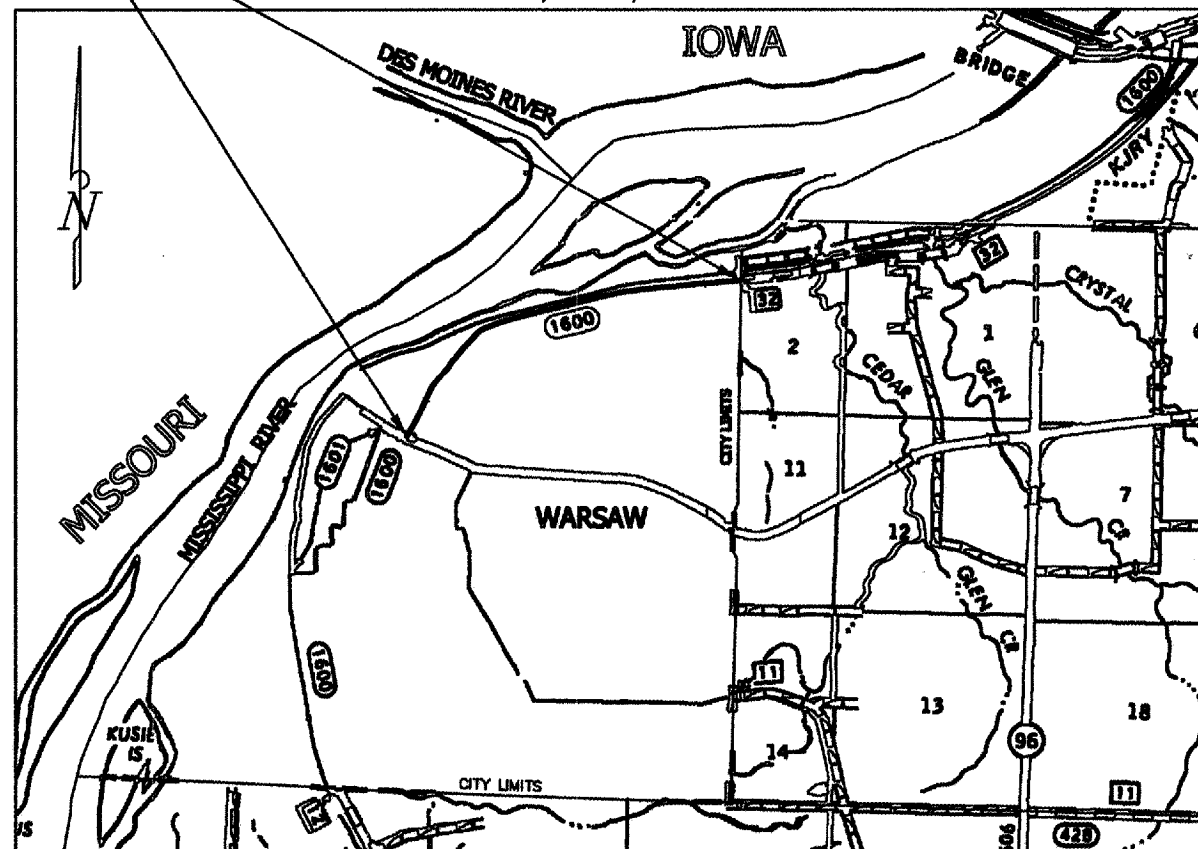


LOCATION MAP

 

TOTAL LENGTH OF PROJECT = 10,925.77 FEET = 2.069 MILES
NET LENGTH OF PROJECT = 10,925.77 FEET = 2.069 MILES
ROADWAY CLASSIFICATION: MAJOR COLLECTOR
3R GUIDELINES: DESIGN TRAFFIC = 3015 (2007)

CONTRACT NO. 93437

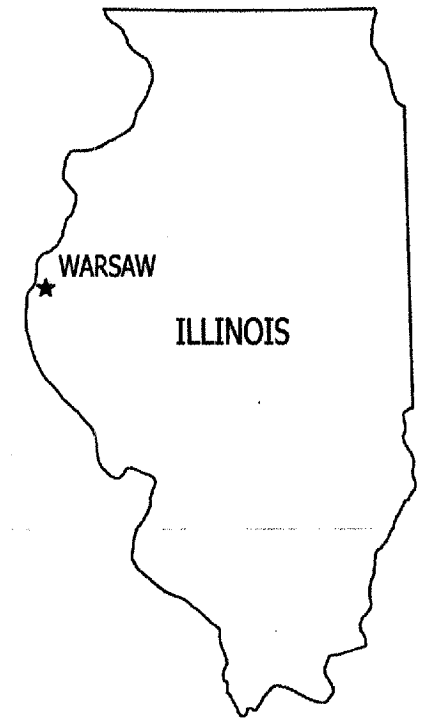


APPROVED 3-12 20 07
Robert Frank
CITY OF WARSAW - MAYOR

PASSED MARCH 19 20 07
Tommy F...
DISTRICT SIX ENGINEER OF LOCAL ROADS AND STREETS

PASSED MARCH 20th 20 07
John...
DISTRICT CONSTRUCTION ENGINEER

Releasing For Bid Based on Limited Review
MARCH 19 20 07
Christine M Reed
REGION FOUR ENGINEER DEPUTY DIRECTOR OF HIGHWAYS
STATE OF ILLINOIS
DEPARTMENT OF TRANSPORTATION

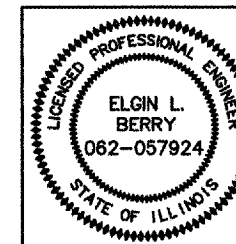

I HEREBY CERTIFY THAT THIS ENGINEERING DOCUMENT WAS PREPARED BY ME OR UNDER MY DIRECT PERSONAL SUPERVISION AND THAT I AM A DULY LICENSED PROFESSIONAL ENGINEER UNDER THE LAWS OF THE STATE OF ILLINOIS.

Elgin Berry 3/9/07

ELGIN L. BERRY P.E. 082-057924 DATE

MY LICENSE RENEWAL DATE IS NOVEMBER 30, 2007

CITY OF WARSAW