


F.A.P. RTE.	SECTION	COUNTY	TOTAL SHEETS	SHEET NO.
95	*	EFFINGHAM	409	33
FED. ROAD DIST. NO. 7 ILLINOIS FED. AID PROJECT				
* (6,7)Y, RS-1, 6B-1, 7B-1, 7BR-2				
CONTRACT NO. 94356				

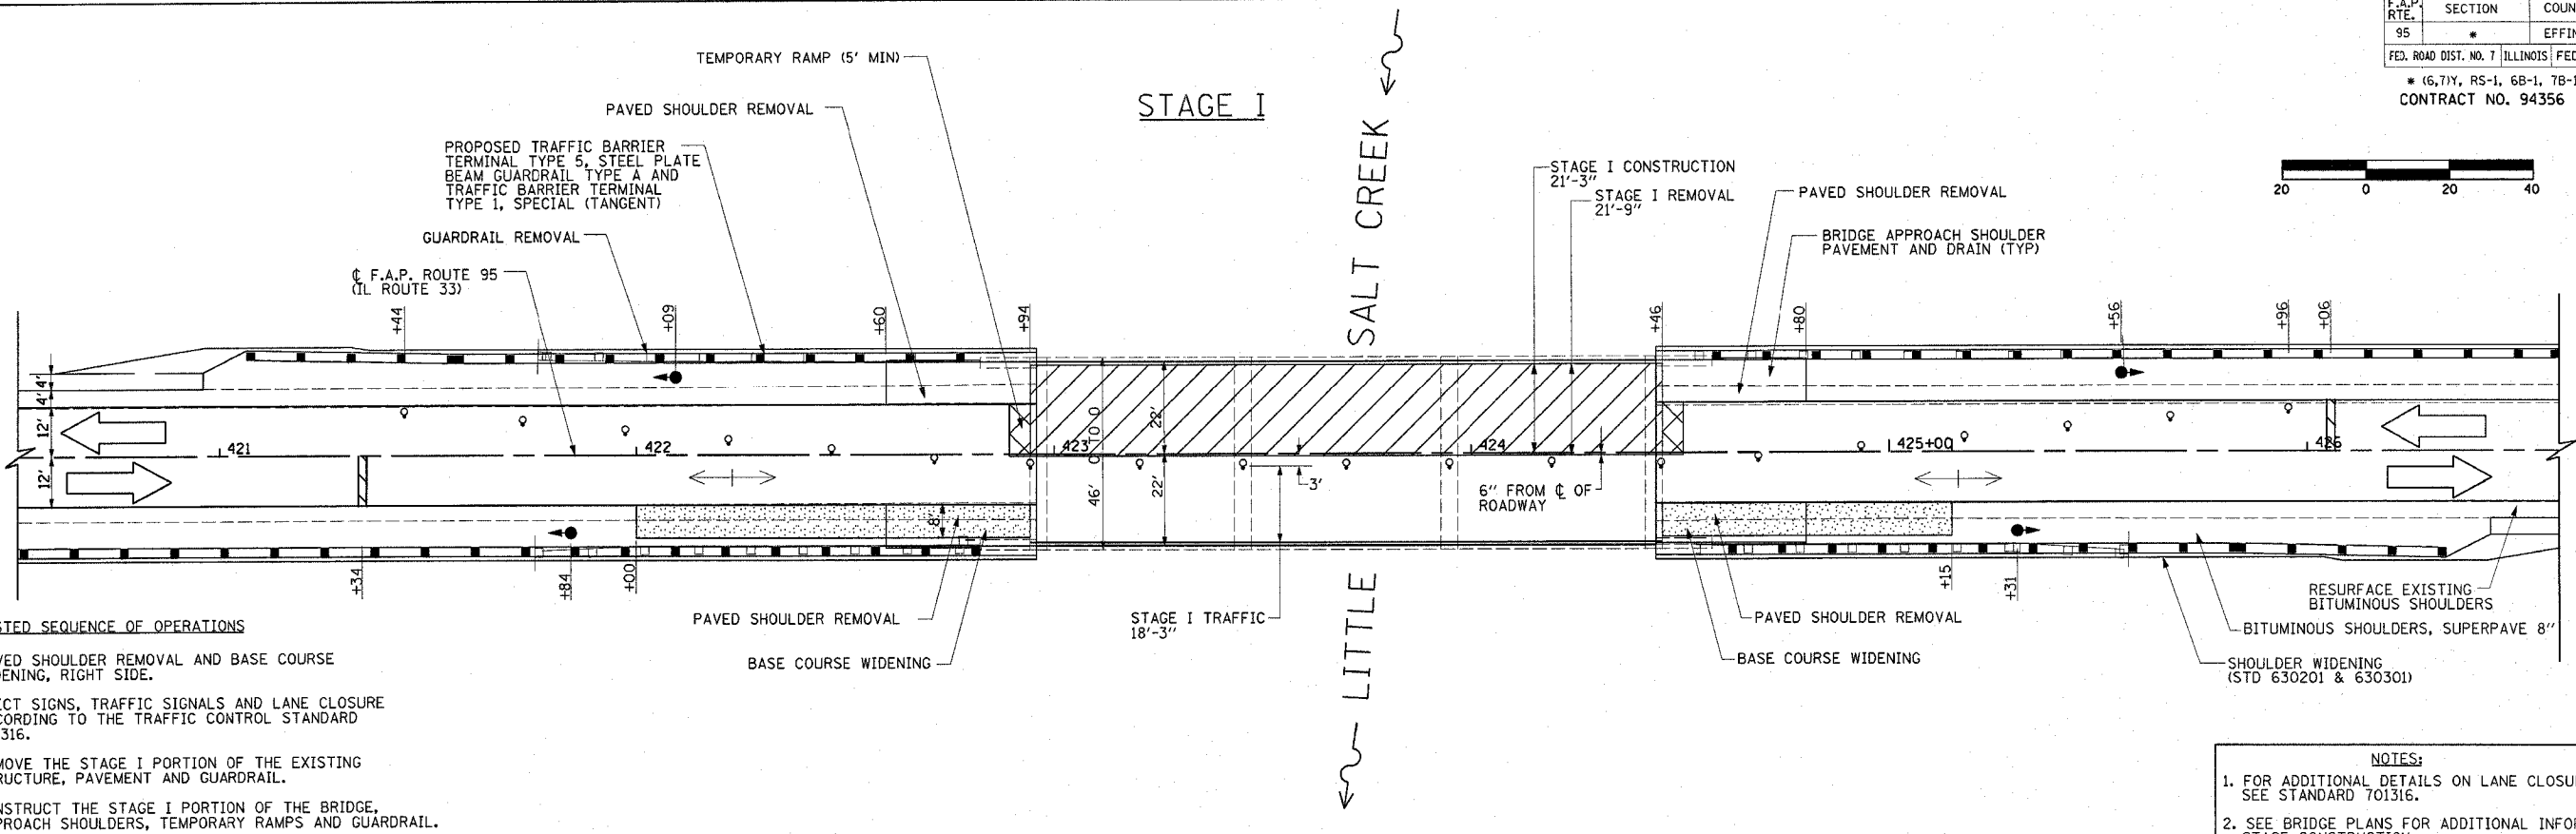


SUGGESTED SEQUENCE OF OPERATIONS

1. PAVED SHOULDER REMOVAL AND BASE COURSE WIDENING, RIGHT SIDE.
2. ERECT SIGNS, TRAFFIC SIGNALS AND LANE CLOSURE ACCORDING TO THE TRAFFIC CONTROL STANDARD 701316.
3. REMOVE THE STAGE I PORTION OF THE EXISTING STRUCTURE, PAVEMENT AND GUARDRAIL.
4. CONSTRUCT THE STAGE I PORTION OF THE BRIDGE, APPROACH SHOULDERS, TEMPORARY RAMPS AND GUARDRAIL.

- NOTES:**
1. FOR ADDITIONAL DETAILS ON LANE CLOSURE, SEE STANDARD 701316.
 2. SEE BRIDGE PLANS FOR ADDITIONAL INFORMATION ON STAGE CONSTRUCTION.
 3. TRAFFIC CONTROL ITEMS SHALL BE PLACED IN ACCORDANCE WITH TRAFFIC CONTROL STANDARD 701316. THIS WORK WILL BE MEASURED AND PAID FOR AT THE CONTRACT UNIT PRICE EACH FOR TRAFFIC CONTROL AND PROTECTION STANDARD 701316, LOCATION 1. THIS PRICE SHALL INCLUDE ALL NECESSARY TRAFFIC CONTROL WORK FOR STAGE 1 AND STAGE II.

SUGGESTED SEQUENCE OF OPERATIONS

1. RELOCATE SIGNS, TRAFFIC SIGNALS AND STAGE II LANE CLOSURE ACCORDING TO THE TRAFFIC CONTROL STANDARD 701316.
2. REMOVE THE STAGE II PORTION OF THE EXISTING STRUCTURE, BASE COURSE WIDENING AND GUARDRAIL.
3. CONSTRUCT THE STAGE II PORTION OF THE NEW BRIDGE, PAVEMENT, APPROACH SHOULDERS, TEMPORARY RAMPS AND GUARDRAIL.
4. REMOVE ALL STAGE CONSTRUCTION TRAFFIC CONTROL ITEMS.

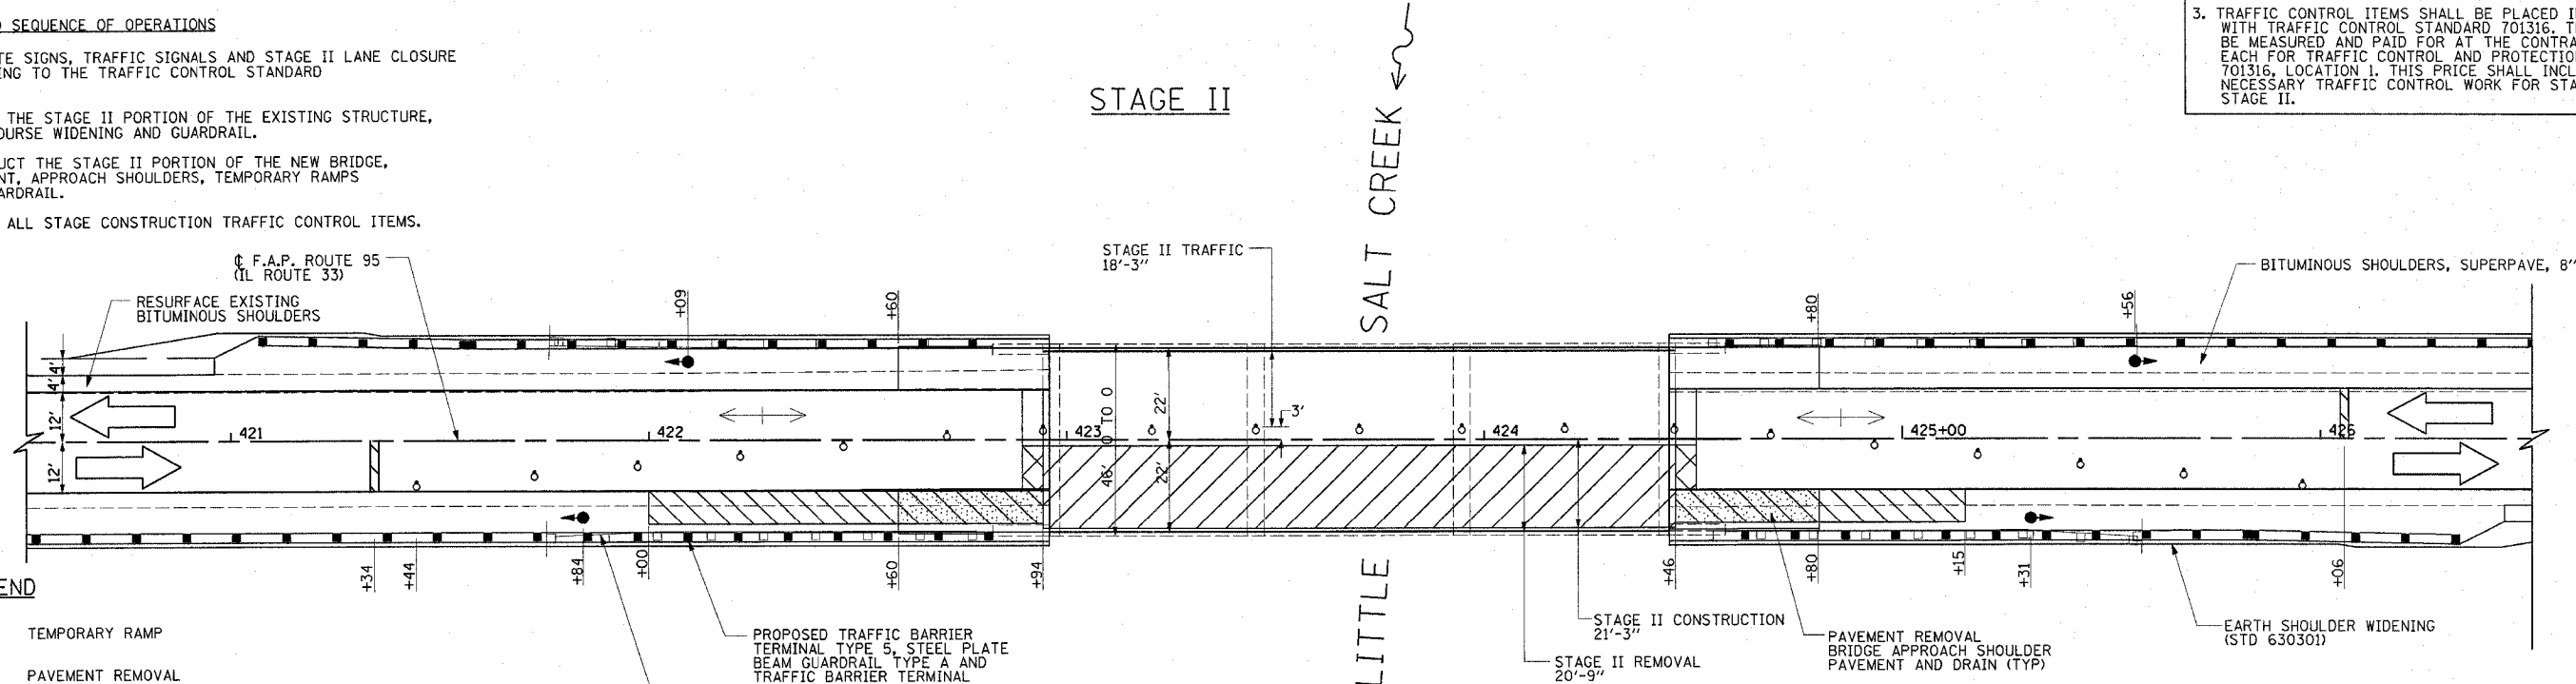

LEGEND

- TEMPORARY RAMP
- PAVEMENT REMOVAL
- WORK AREA
- BASE COURSE WIDENING
- BARRICADE OR DRUM WITH MONODIRECTIONAL STEADY BURNING LIGHT
- STOP BAR
- TRAFFIC SIGNALS
- PROPOSED TRAFFIC BARRIER TERMINAL TYPE 5, STEEL PLATE BEAM GUARDRAIL TYPE A AND TRAFFIC BARRIER TERMINAL TYPE 1, SPECIAL (TANGENT)
- GUARDRAIL REMOVAL

REVISIONS	
NAME	DATE

ILLINOIS DEPARTMENT OF TRANSPORTATION

STAGE CONSTRUCTION
 IL RTE 33 OVER LITTLE SALT CREEK
 STRUCTURE NO. 025-0082
 STA. 423+70.00

DATE 10/01

DRAWN BY MLO
 CHECKED BY TGC