
 


ROUTE NO.	SECTION	COUNTY	TOTAL SHEETS	SHEET NO.
FAU-8906	08-00208-02-BR	MADISON	61	38
FED. ROAD DIST. NO.	PROJECT			

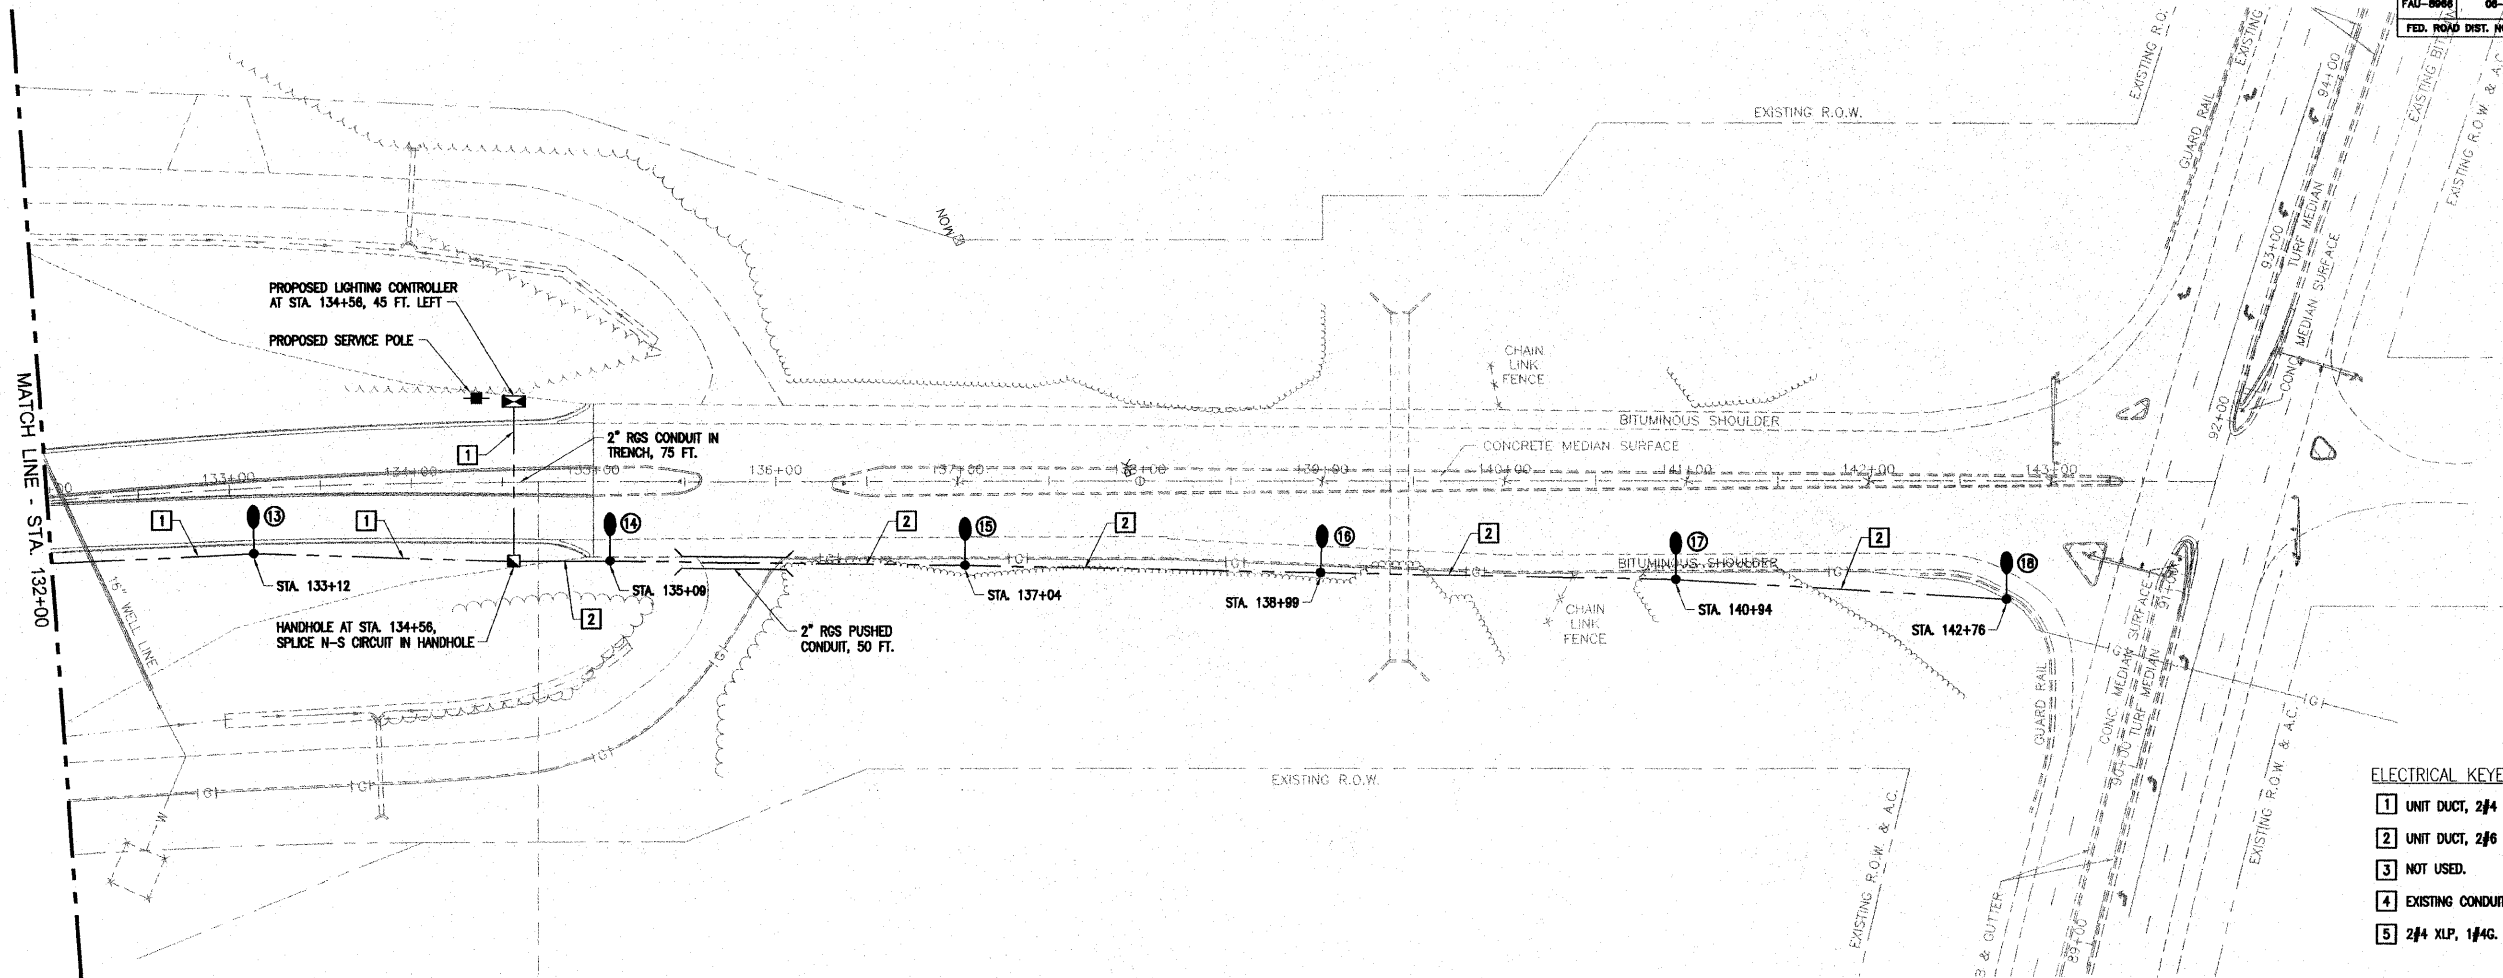

- ELECTRICAL KEYED NOTES:**
- 1 UNIT DUCT, 2#4 XLP, 1#4G. XLP, 1" IN TRENCH.
 - 2 UNIT DUCT, 2#6 XLP, 1#6G. XLP, 1" IN TRENCH.
 - 3 NOT USED.
 - 4 EXISTING CONDUIT EMBEDDED IN STRUCTURE, 2".
 - 5 2#4 XLP, 1#4G. XLP, EXISTING CONDUIT

LIGHTING PLAN



THE LOCATION, SIZE AND TYPE OF MATERIAL OF EXISTING UNDERGROUND UTILITIES INDICATED ON THE PLANS IS NOT REPRESENTED AS BEING ACCURATE, SUFFICIENT OR COMPLETE. IT SHALL BE THE CONTRACTOR'S RESPONSIBILITY TO DETERMINE THE ACTUAL LOCATION OF ALL SUCH FACILITIES, INCLUDING THE SERVICE CONNECTIONS TO UNDERGROUND UTILITIES. PRIOR TO CONSTRUCTION THE CONTRACTOR SHALL NOTIFY THE UTILITY COMPANIES OF HIS OPERATIONAL PLANS AND SHALL OBTAIN FROM THE RESPECTIVE UTILITY COMPANIES DETAILED INFORMATION AND ASSISTANCE RELATIVE TO THE LOCATION OF THEIR FACILITIES AND THE WORKING SCHEDULE OF THE COMPANIES FOR REMOVAL OR ADJUSTMENT WHERE REQUIRED. IN THE EVENT AN UNEXPECTED UTILITY INTERFERENCE IS ENCOUNTERED DURING CONSTRUCTION, THE CONTRACTOR SHALL IMMEDIATELY NOTIFY THE UTILITY COMPANY OF JURISDICTION. THE ENGINEER SHALL ALSO BE IMMEDIATELY NOTIFIED. ANY SUCH MAINS AND SERVICES SHALL BE RESTORED TO SERVICE AT ONCE AND PAID FOR BY THE CONTRACTOR AT NO ADDITIONAL COST TO THE CONTRACT.

INDIANA AVENUE EXTENSION
CITY OF ALTON, IL
ROADWAY LIGHTING
PLAN

LAYOUT	PJT	<p>HANSON Copyright Hanson Professional Services Inc. 2005 Hanson Professional Services Inc. 1525 South Sixth Street Springfield, Illinois 62703-2886 ILLINOIS LICENSED PROFESSIONAL SERVICES CORPORATION #184-001064</p>	JOB NO.	95510081
DRAWN	ANC		DATE	08-16-06
REVIEWED	PJT			

L-3