



F.A.U. RTE.	SECTION	COUNTY	TOTAL SHEETS	SHEET NO.
9024	05-00187-01-RP	MADISON	79	25
FED. ROAD DIST. NO.	ILLINOIS	FED. AID PROJECT		
CONTRACT NO. 07298				

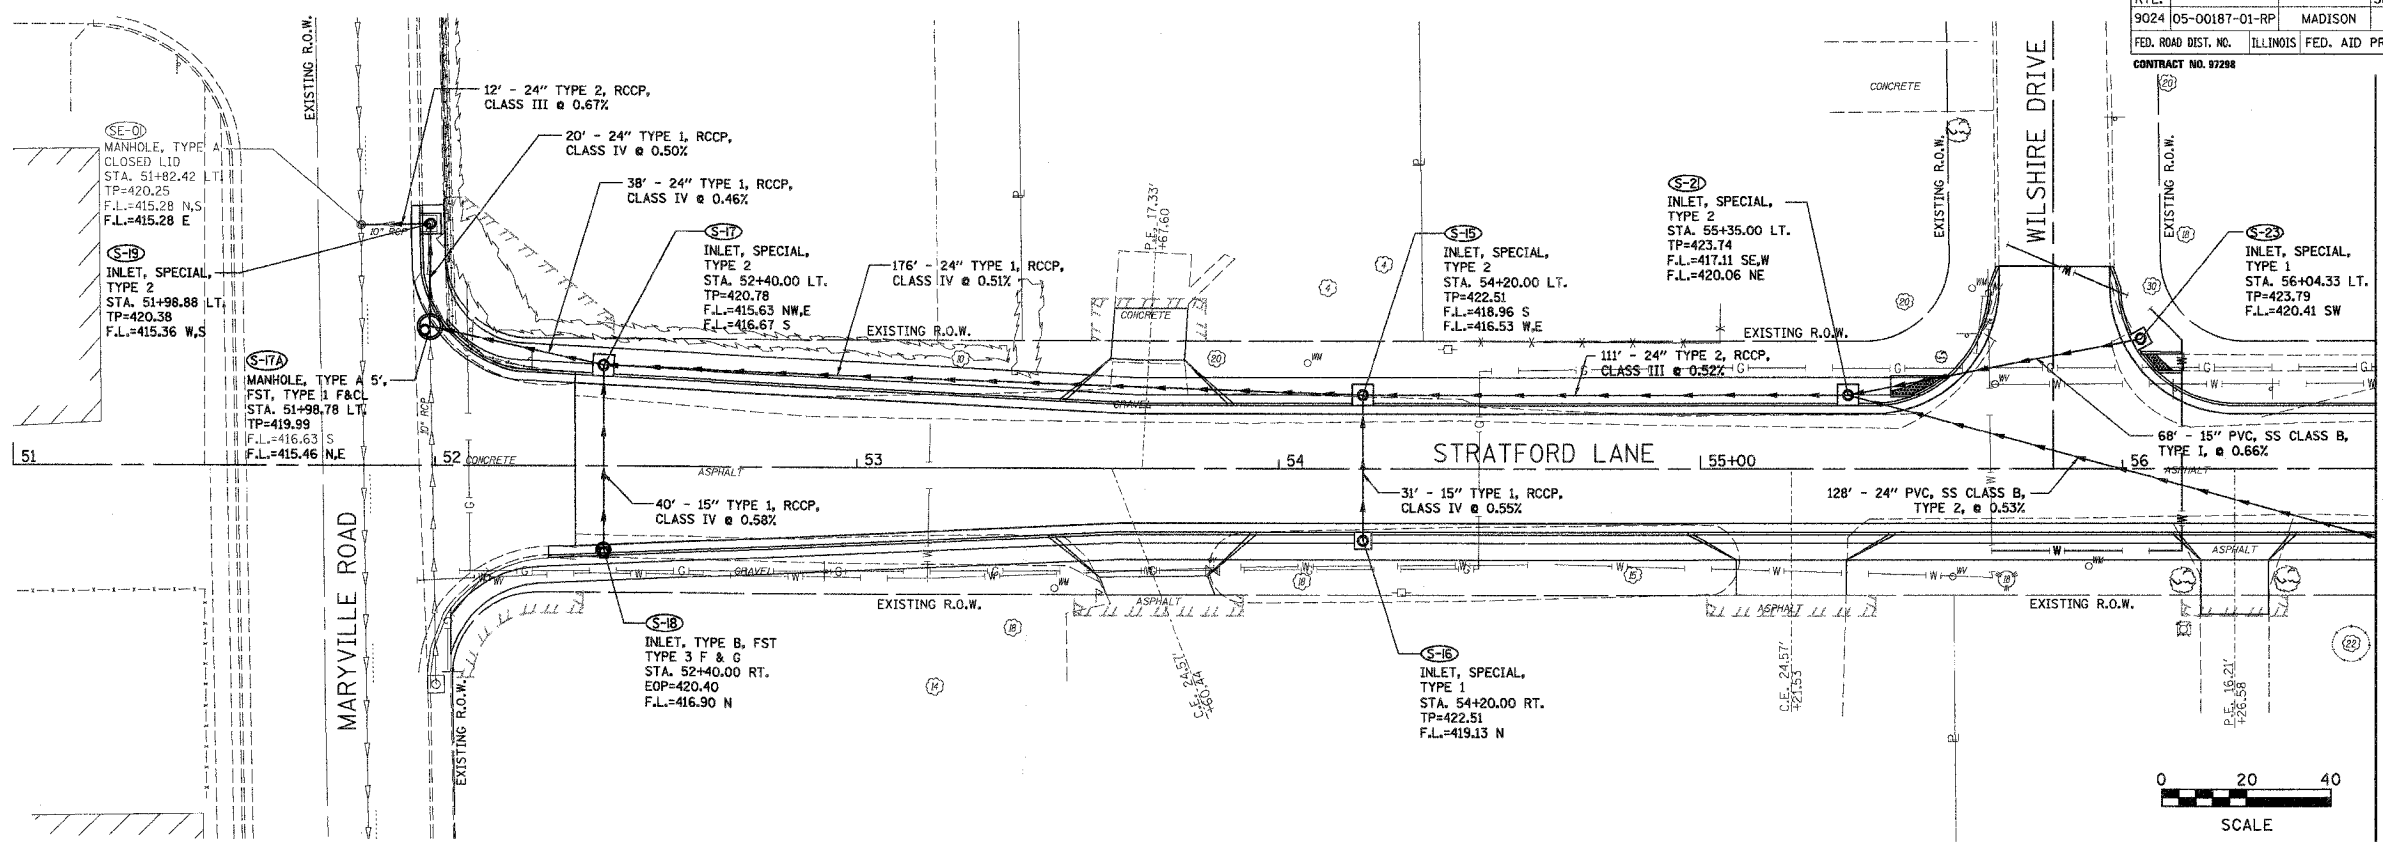

FINAL SURVEY	DATE
SURVEY PLOTTED	
NOTE BOOK TEMPLATE	
NO.	
AREAS CHECKED	

ORIGINAL SURVEY	DATE
SURVEY PLOTTED	
NOTE BOOK TEMPLATE	
NO.	
AREAS CHECKED	

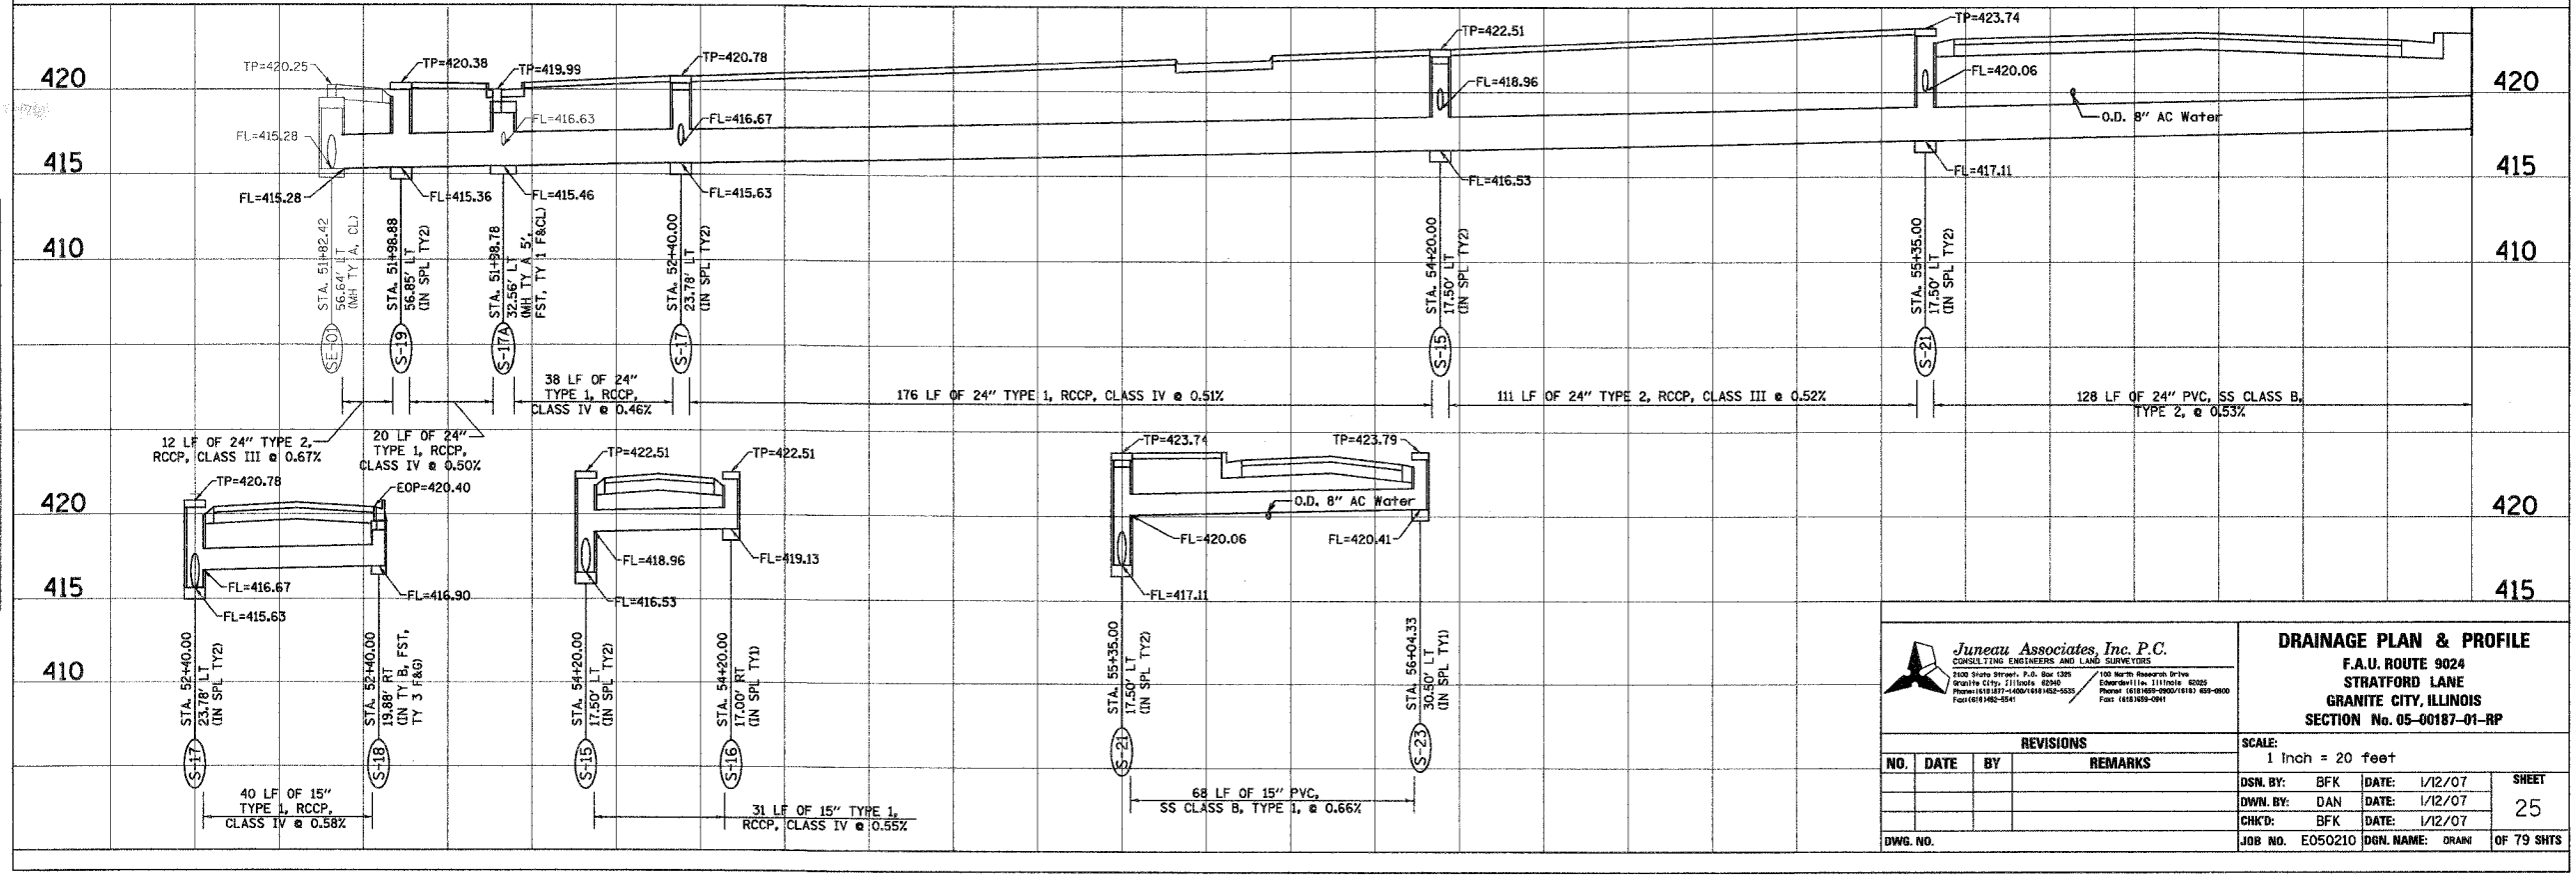

Juneau Associates, Inc. P.C.
CONSULTING ENGINEERS AND LAND SURVEYORS
2100 State Street, P.O. Box 1205
Granite City, Illinois 62040
Phone: (618) 237-4000 / (618) 462-5235
Fax: (618) 238-0261

DRAINAGE PLAN & PROFILE
F.A.U. ROUTE 9024
STRATFORD LANE
GRANITE CITY, ILLINOIS
SECTION No. 05-00187-01-RP

REVISIONS			
NO.	DATE	BY	REMARKS

SCALE: 1 inch = 20 feet			
DSN. BY: BFK	DATE: 1/12/07	SHEET	
DWN. BY: DAN	DATE: 1/12/07	25	
CHK'D: BFK	DATE: 1/12/07		
DWG. NO.	JOB NO. E050210	DGN. NAME: DRANI	OF 79 SHTS