
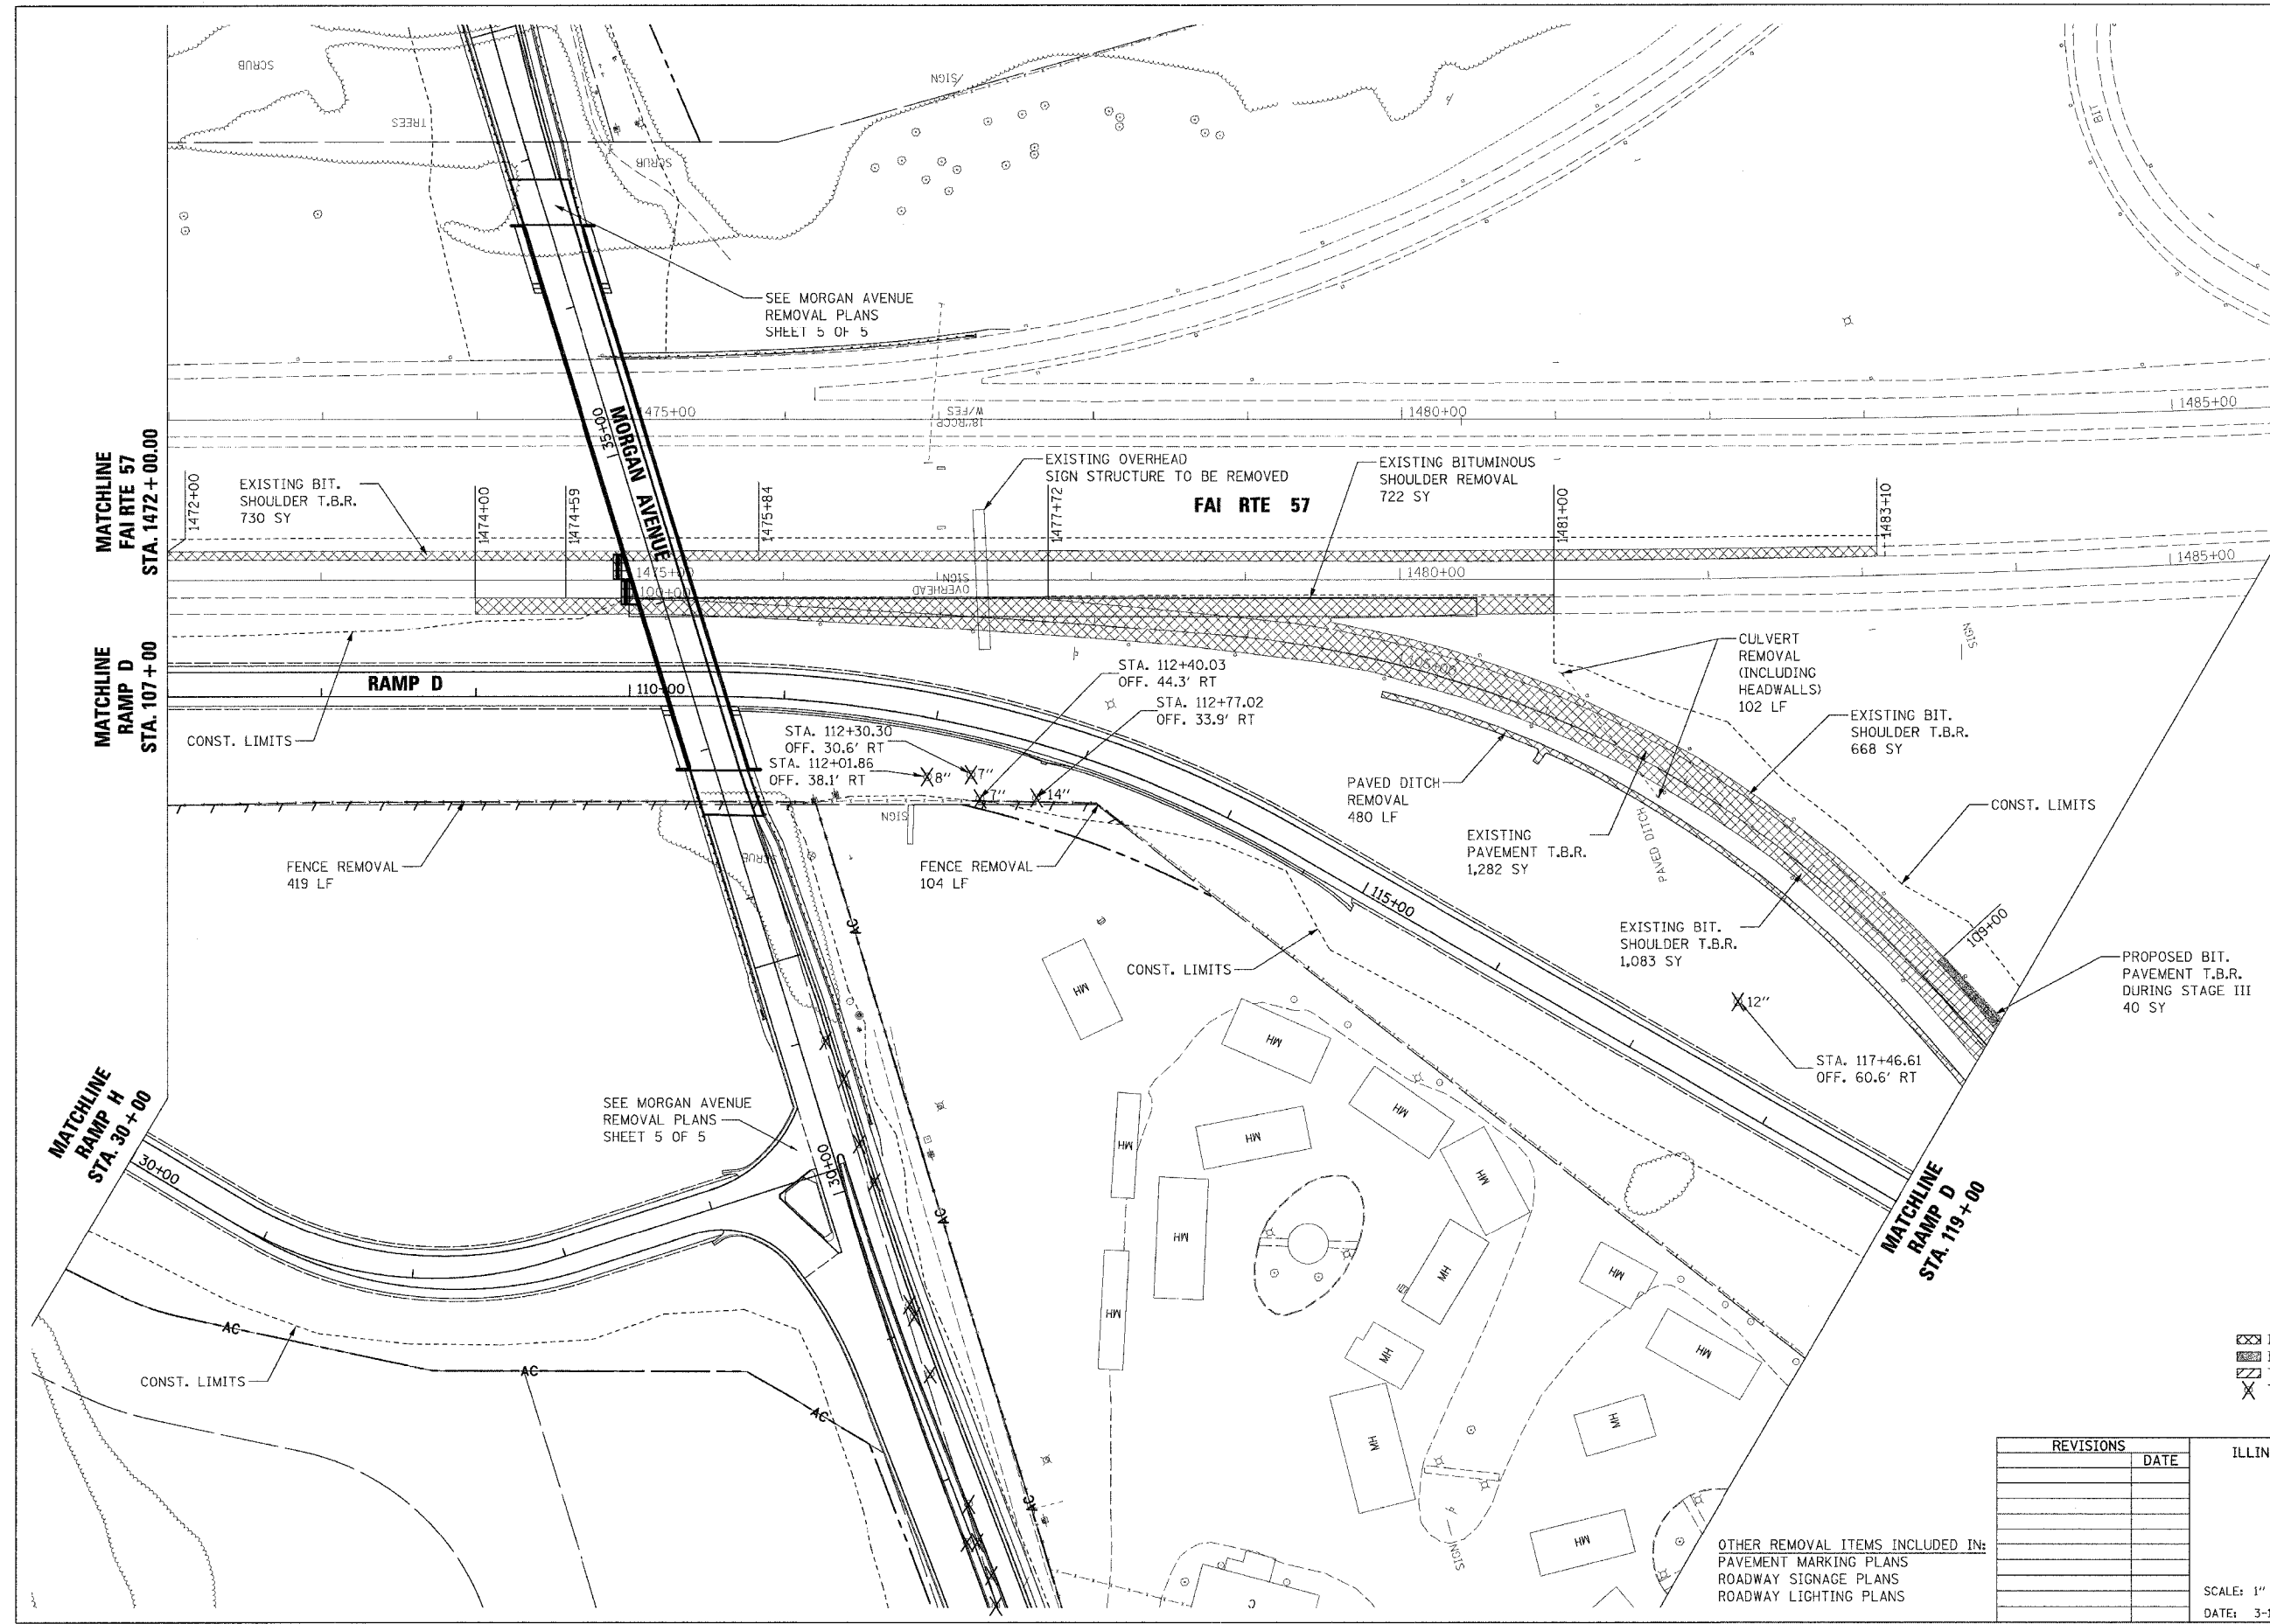


F.A.I. RTE.	SECTION	COUNTY	TOTAL SHEETS	SHEET NO.
57	0X1-6-2HBK	WILLIAMSON	272	45
STA. 107+00		TO STA. 119+00		
FED. ROAD DIST. NO. 9		ILLINOIS	FED. AID PROJECT	

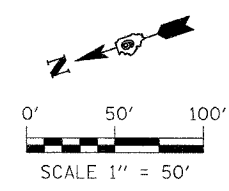

LEGEND

- ITEM TO BE REMOVED
- ITEM TO BE REMOVED (STAGE III ONLY)
- TREE REMOVAL (ACRES)
- TREE REMOVAL (UNITS)

REVISIONS	DATE

ILLINOIS DEPARTMENT OF TRANSPORTATION

REMOVAL PLAN
 MORGAN AVENUE INTERCHANGE
 FAI ROUTE 57 WITH FAI ROUTE 9718
 WILLIAMSON COUNTY

3 OF 5

SCALE: 1" = 50'
 DATE: 3-19-2007

DRAWN BY: MJ
 CHECKED BY: RD

OTHER REMOVAL ITEMS INCLUDED IN:
 PAVEMENT MARKING PLANS
 ROADWAY SIGNAGE PLANS
 ROADWAY LIGHTING PLANS

PLOT DATE = 3/19/2007
 FILE NAME = P:\2465698\09\09\03\01\01\01.dgn
 PLOT SCALE = 50.00000 / IN.
 USER NAME = dharman