


F.A.I. RTE.	SECTION	COUNTY	TOTAL SHEETS	SHEET NO.
57	(X1-6-2)HBK	WILLIAMSON	272	46
STA. 119+00		TO STA. END		
FED. ROAD DIST. NO. 9		ILLINOIS		FED. AID PROJECT


MATCHLINE
RAMP D
STA. 119 + 00

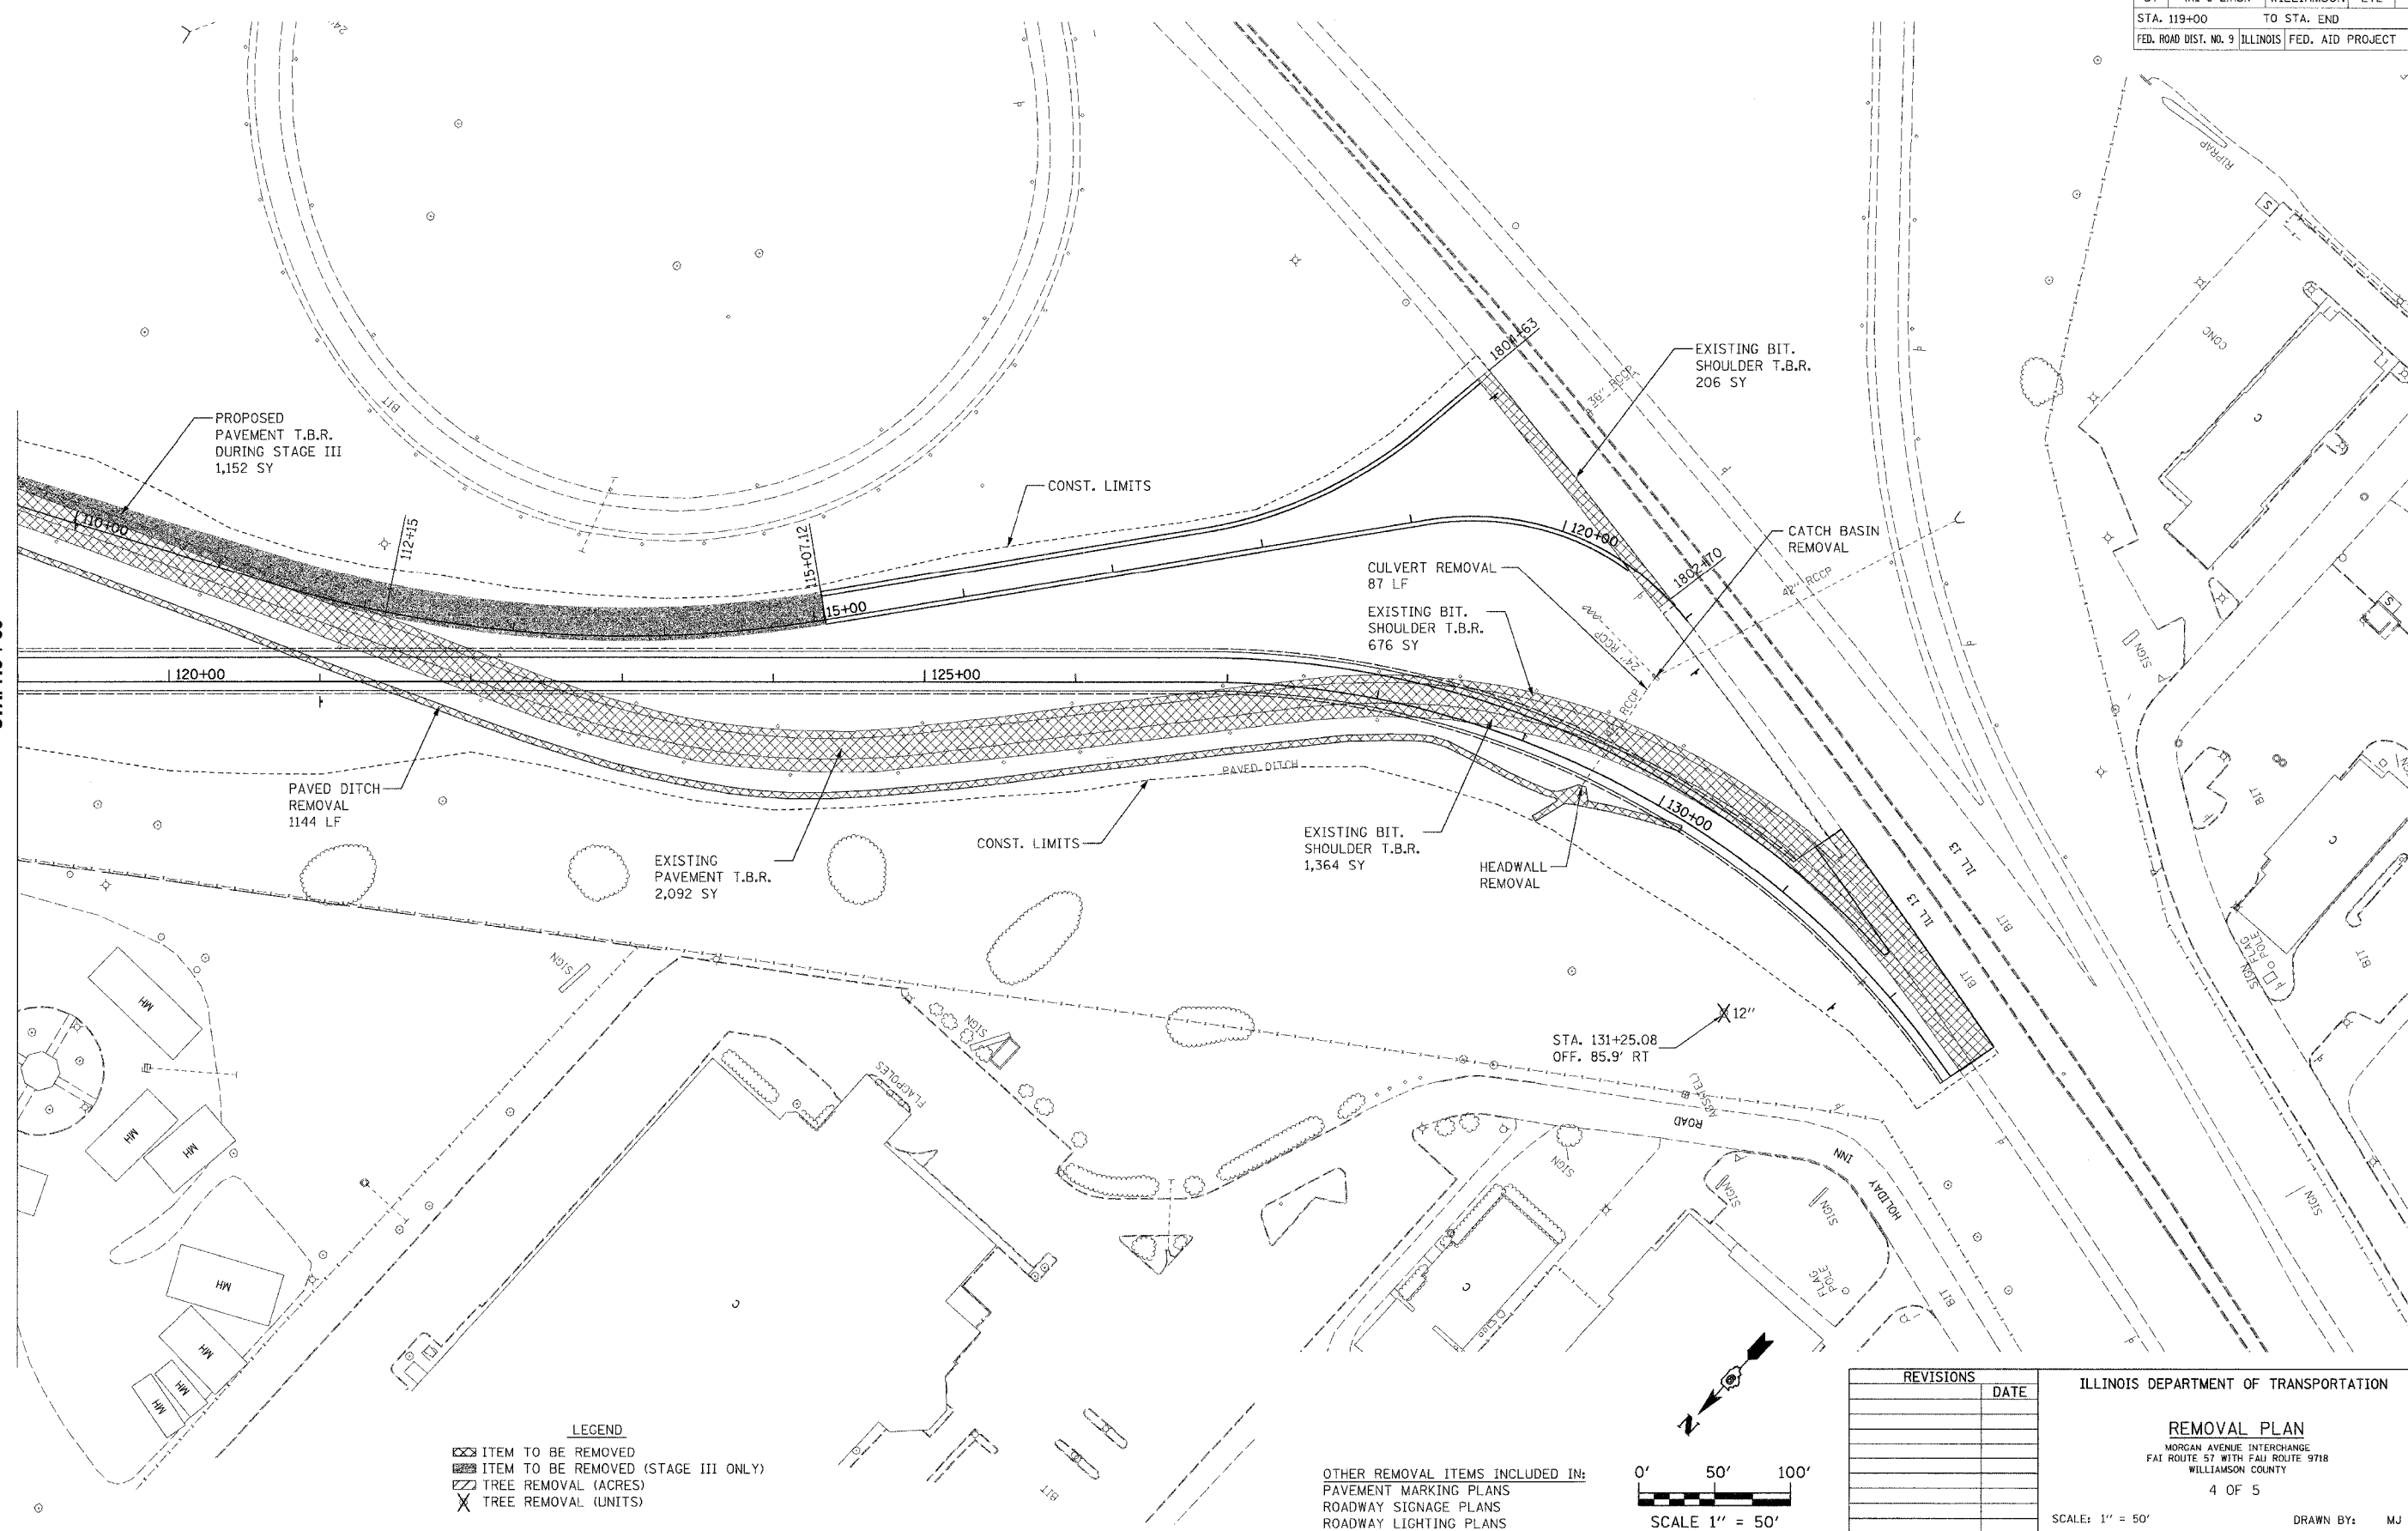

LEGEND

	ITEM TO BE REMOVED
	ITEM TO BE REMOVED (STAGE III ONLY)
	TREE REMOVAL (ACRES)
	TREE REMOVAL (UNITS)

OTHER REMOVAL ITEMS INCLUDED IN:
PAVEMENT MARKING PLANS
ROADWAY SIGNAGE PLANS
ROADWAY LIGHTING PLANS

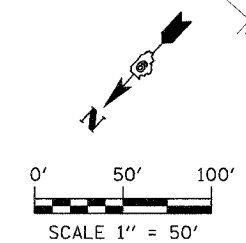

REVISIONS	DATE

ILLINOIS DEPARTMENT OF TRANSPORTATION

REMOVAL PLAN
MORGAN AVENUE INTERCHANGE
FAT ROUTE 57 WITH FAJ ROUTE 9718
WILLIAMSON COUNTY

4 OF 5

SCALE: 1" = 50'
DATE: 3-19-2007

DRAWN BY: MJ
CHECKED BY: RD

PLOT DATE = 3/19/2007
 FILE NAME = D:\98994\98994.dwg
 PLOT SCALE = 1/8" = 1' / IN.
 USER NAME = dhaerem