
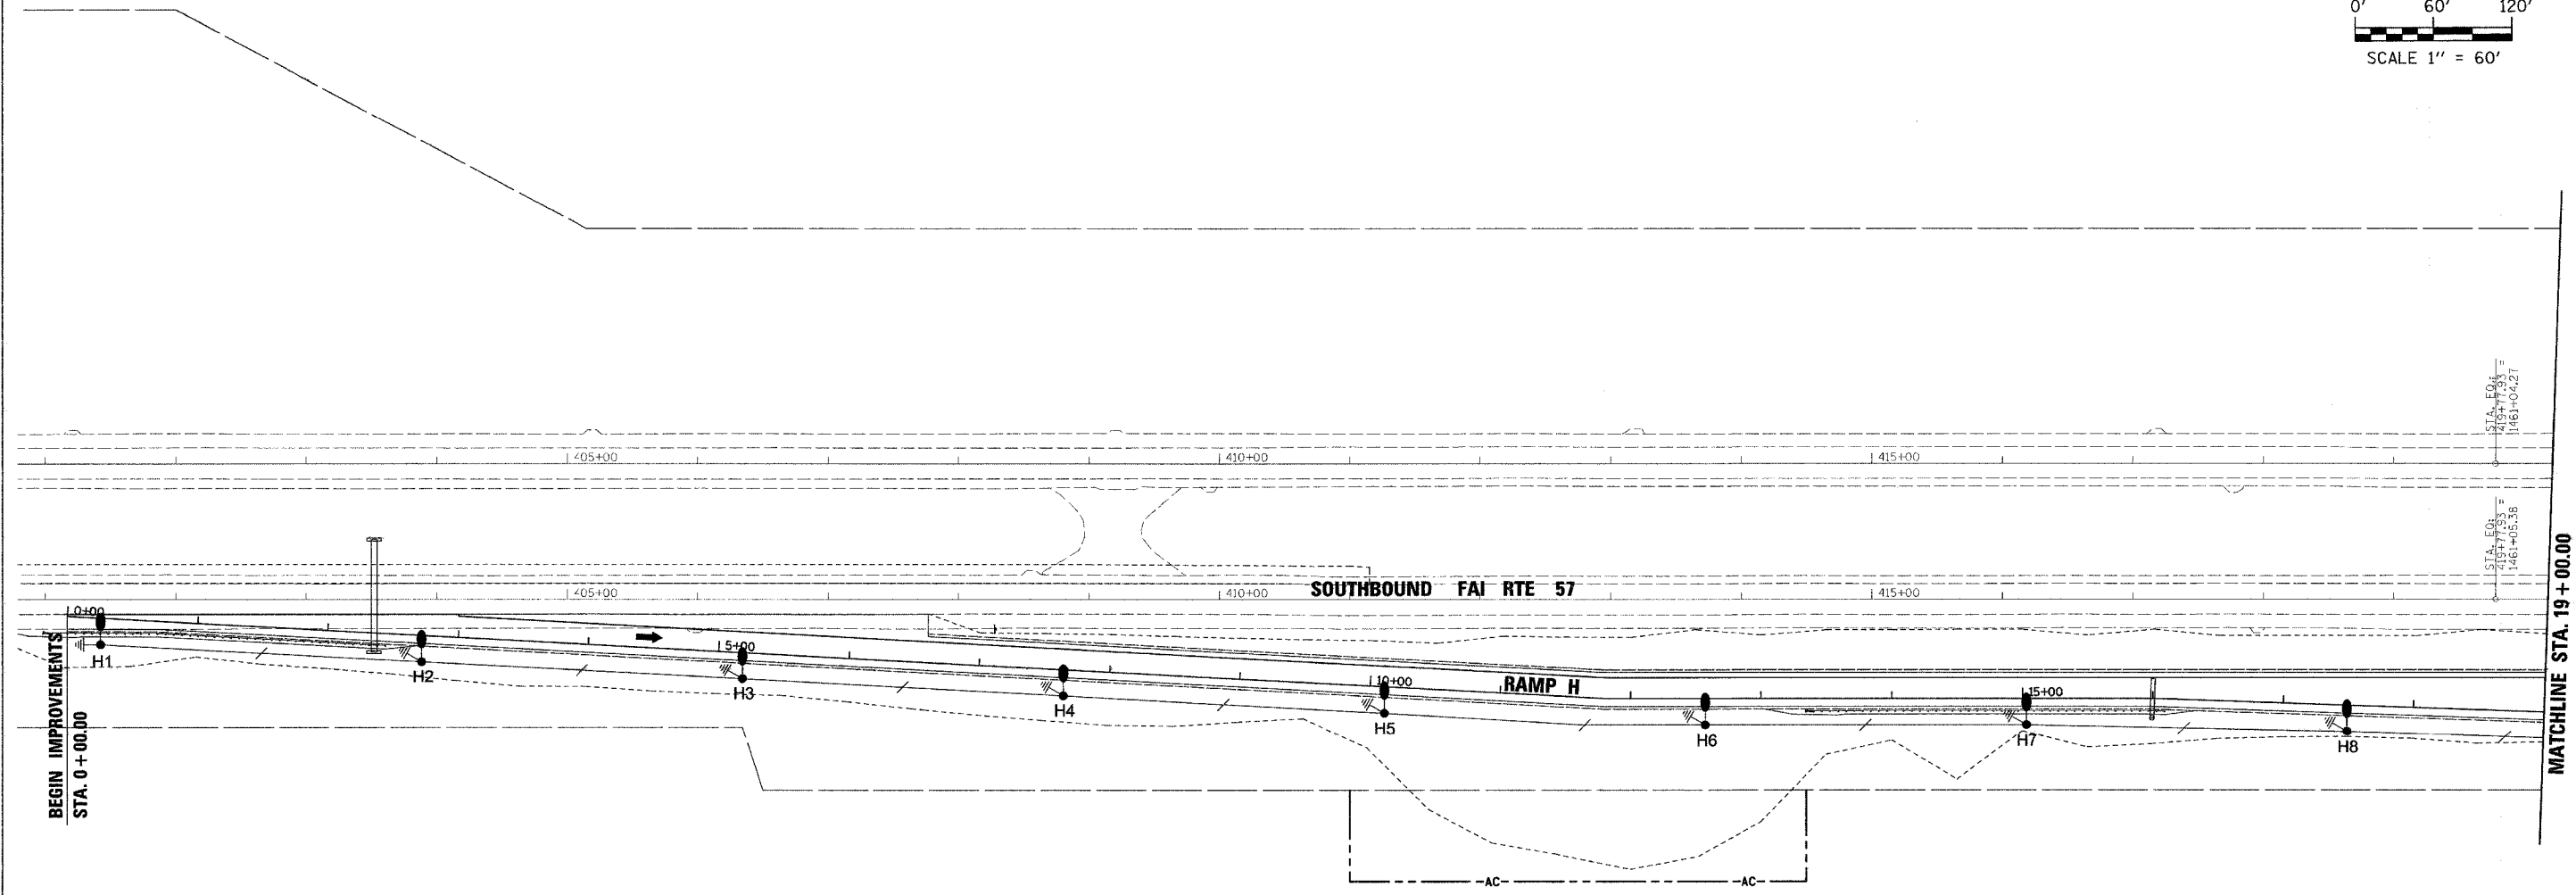


F.A.I. RTE.	SECTION	COUNTY	TOTAL SHEETS	SHEET NO.
57	04-0009700BR	WILLIAMSON	272	76
STA.	TO STA.			
FED. ROAD DIST. NO. 9	ILLINOIS	FED. AID PROJECT		

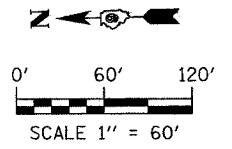

PLOT DATE = 3/19/2007
 FILE NAME = F:\04-0009700BR\0406001.tbl.dgn
 PLOT SCALE = 60.0000 / IN.
 USER NAME = chester

LEGEND

- ELECTRIC SERVICE INSTALLATION
- LIGHTING CONTROLLER
- 400W RPS LUMINAIRE & 50' MH POLE WITH 15' MA
- ⊥ GROUND ELECTRODE
- UNIT DUCT, 2*6XLP & 1*6G
- UNIT DUCT, 2*8XLP & 1*8G

REVISIONS	
NAME	DATE

ILLINOIS DEPARTMENT OF TRANSPORTATION

LIGHTING PLAN
 MORGAN AVENUE INTERCHANGE
 FAP ROUTE 57 WITH FAU ROUTE 9718
 WILLIAMSON COUNTY

1 OF 9

SCALE: N/A
 DATE: 3-19-2007

DRAWN BY: BLR
 CHECKED BY: RSD