



MAY 09, 2007 2:12 PM MLH
F:\AIRPORTS\QUINCY\82407XYD\AIRPORT\SHEETS\R-141ELE.DWG - 145+00 TO 151+00

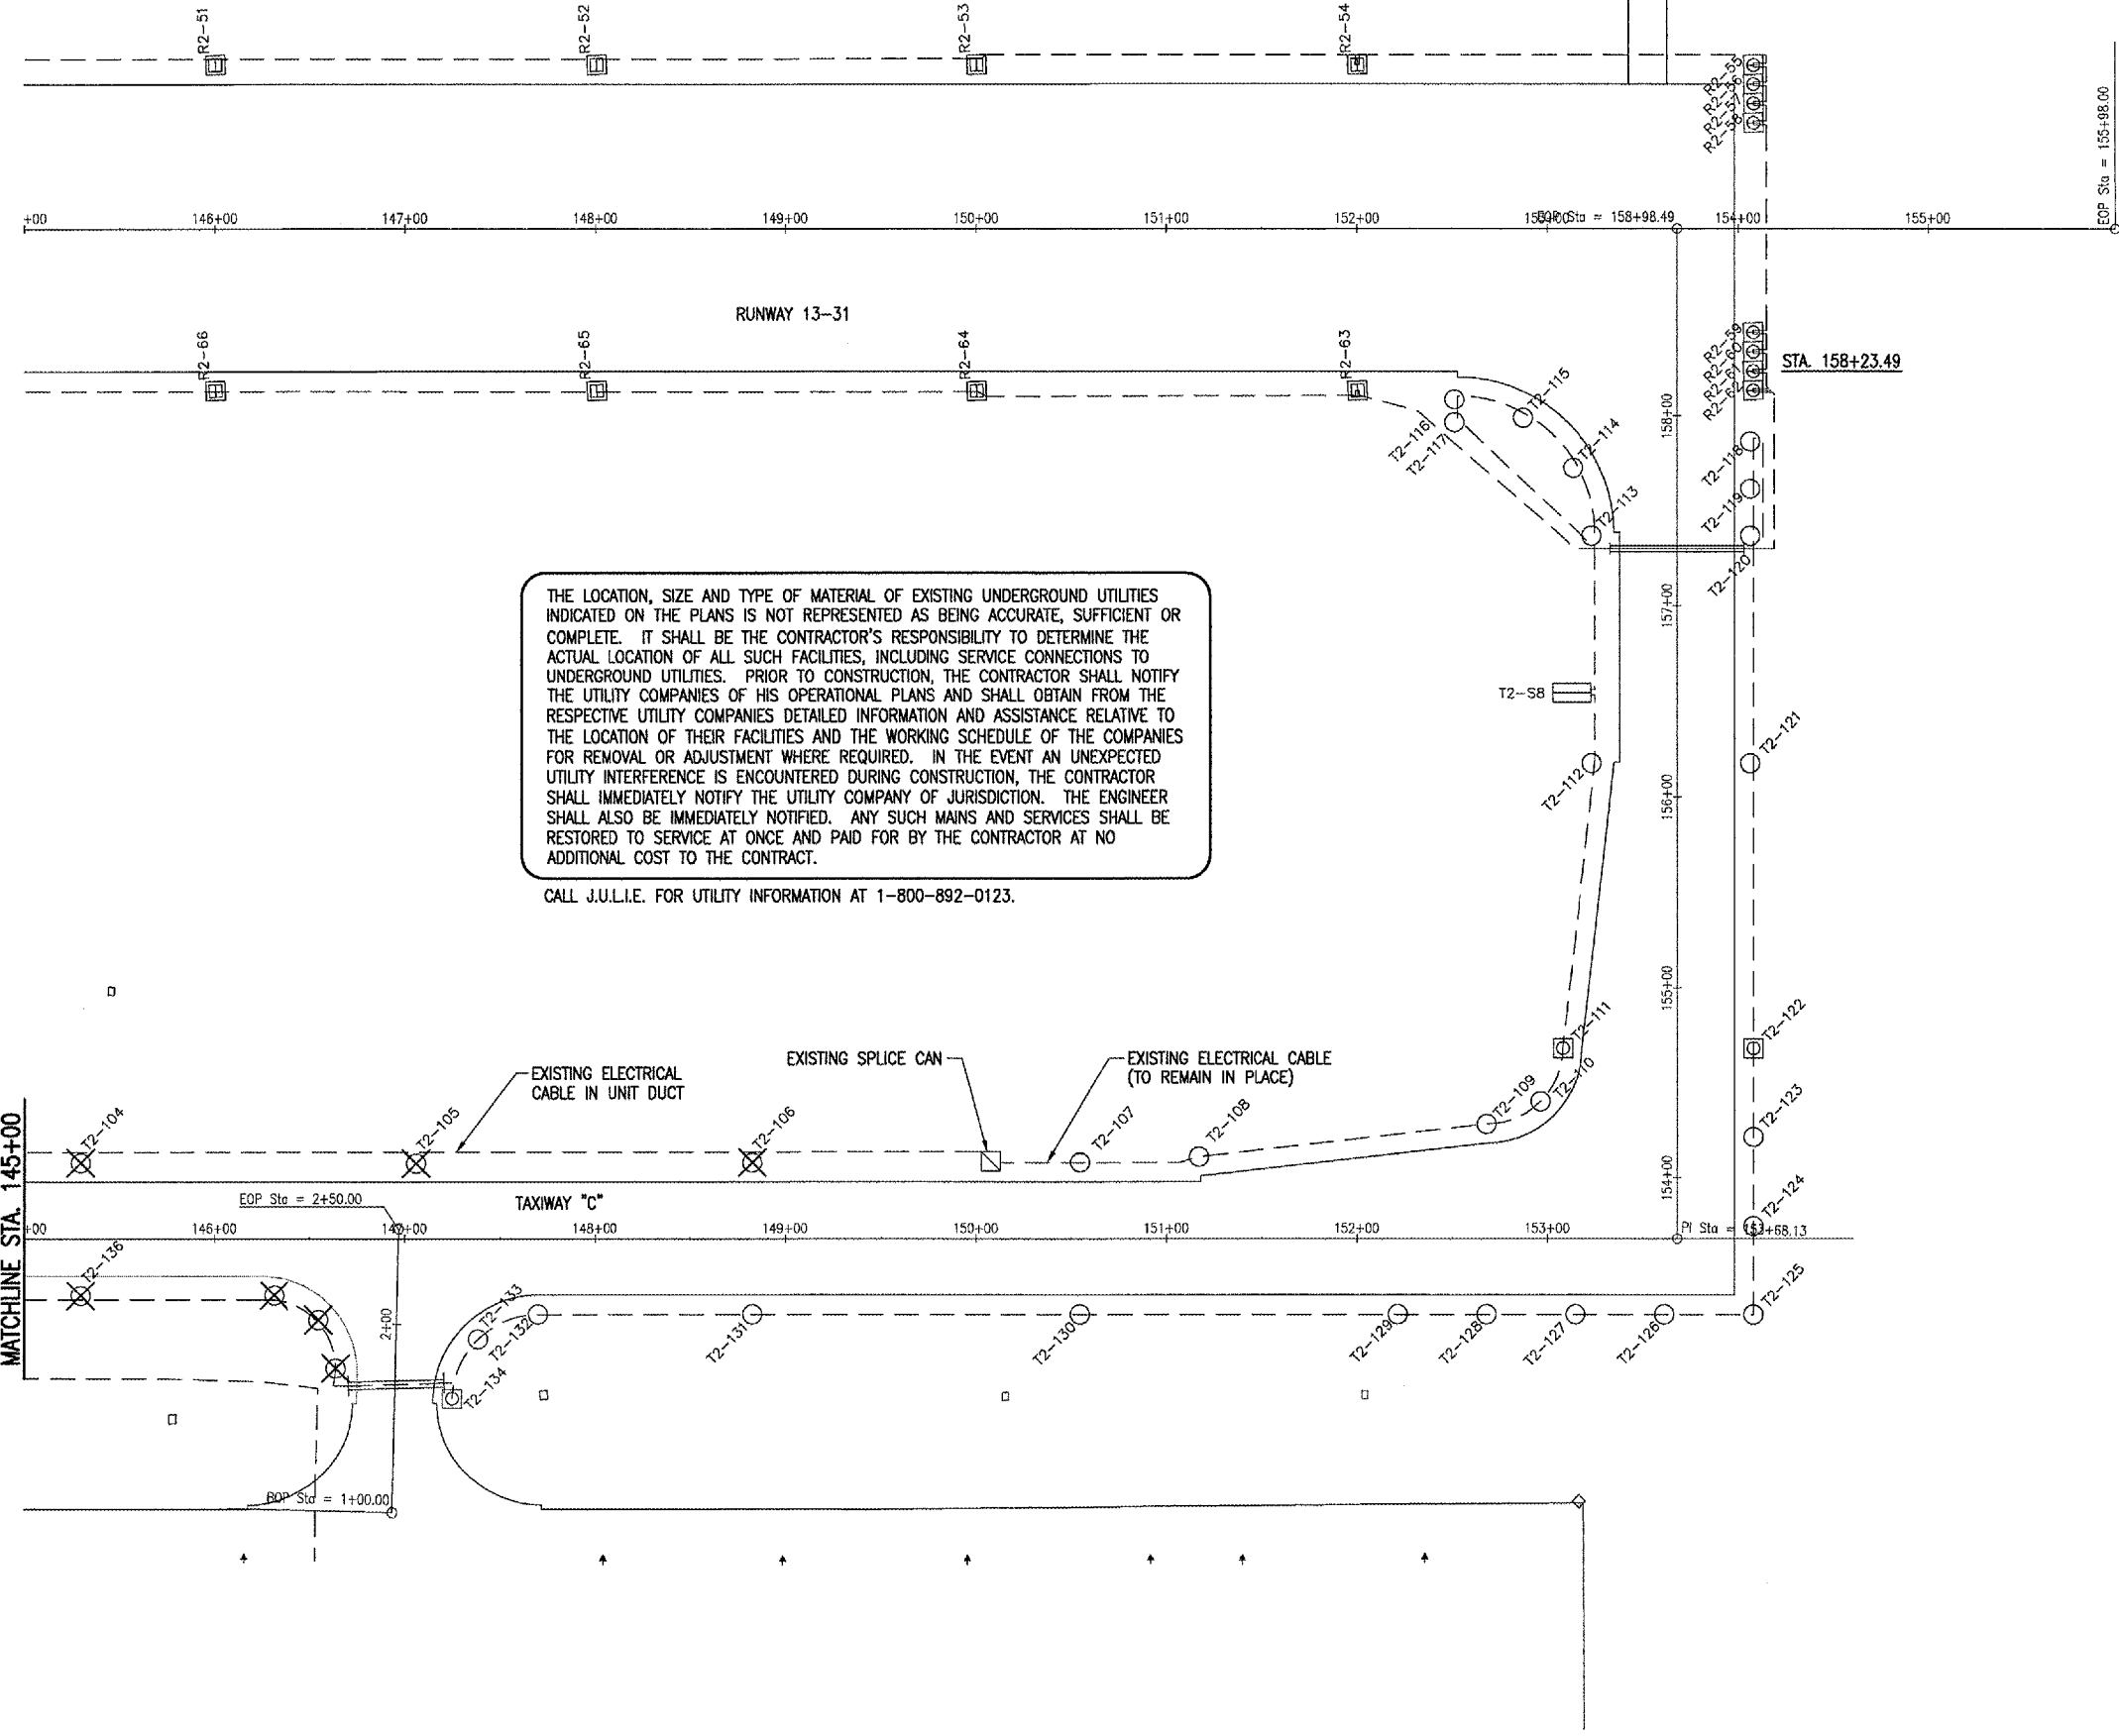

THE LOCATION, SIZE AND TYPE OF MATERIAL OF EXISTING UNDERGROUND UTILITIES INDICATED ON THE PLANS IS NOT REPRESENTED AS BEING ACCURATE, SUFFICIENT OR COMPLETE. IT SHALL BE THE CONTRACTOR'S RESPONSIBILITY TO DETERMINE THE ACTUAL LOCATION OF ALL SUCH FACILITIES, INCLUDING SERVICE CONNECTIONS TO UNDERGROUND UTILITIES. PRIOR TO CONSTRUCTION, THE CONTRACTOR SHALL NOTIFY THE UTILITY COMPANIES OF HIS OPERATIONAL PLANS AND SHALL OBTAIN FROM THE RESPECTIVE UTILITY COMPANIES DETAILED INFORMATION AND ASSISTANCE RELATIVE TO THE LOCATION OF THEIR FACILITIES AND THE WORKING SCHEDULE OF THE COMPANIES FOR REMOVAL OR ADJUSTMENT WHERE REQUIRED. IN THE EVENT AN UNEXPECTED UTILITY INTERFERENCE IS ENCOUNTERED DURING CONSTRUCTION, THE CONTRACTOR SHALL IMMEDIATELY NOTIFY THE UTILITY COMPANY OF JURISDICTION. THE ENGINEER SHALL ALSO BE IMMEDIATELY NOTIFIED. ANY SUCH MAINS AND SERVICES SHALL BE RESTORED TO SERVICE AT ONCE AND PAID FOR BY THE CONTRACTOR AT NO ADDITIONAL COST TO THE CONTRACT.

CALL J.U.L.I.E. FOR UTILITY INFORMATION AT 1-800-892-0123.

- LEGEND**
- EXISTING PAVEMENT
 - EXISTING ELECTRICAL DUCT
 - EXISTING ELECTRICAL CABLE (TO REMAIN IN PLACE)
 - EXISTING STAKE MOUNTED TAXIWAY LIGHT
 - EXISTING BASE MOUNTED RUNWAY LIGHT
 - EXISTING BASE MOUNTED THRESHOLD LIGHT
 - EXISTING TAXI GUIDANCE SIGN
 - EXISTING STAKE MOUNTED TAXIWAY LIGHT (TO BE REMOVED)
 - EXISTING BASE MOUNTED TAXIWAY LIGHT (TO BE REMOVED)

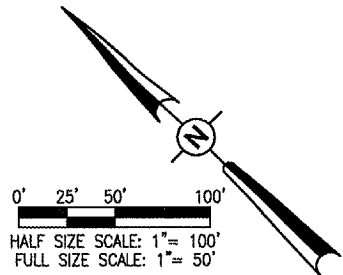

DATE	REVISION	BY	
<p>QUINCY REGIONAL AIRPORT BALDWIN FIELD ADAMS COUNTY, ILLINOIS</p>			
IEL Project No. 82407XYD_0100 Filename: R-141ELE.DWG Scale: 1" = 50' Date: 03/14/07		LAYOUT: DAK 03/14/07 DRAWN: MLH 03/14/07 REVIEWED: JDW 03/19/07	
<p>Hanson Professional Services Inc. 1626 South Sixth Street Springfield, Illinois 62703-2886 Offices Nationwide</p>			
<p>REALIGN, WIDEN AND REHABILITATE TAXIWAY "C" - PHASE 2 EXISTING ELECTRICAL PLAN STA. 145+00 TO STA. 153+68.13</p>			
14			
14 of 29 sheets			