



**TYPICAL SPLICE DETAIL**

N.T.S.

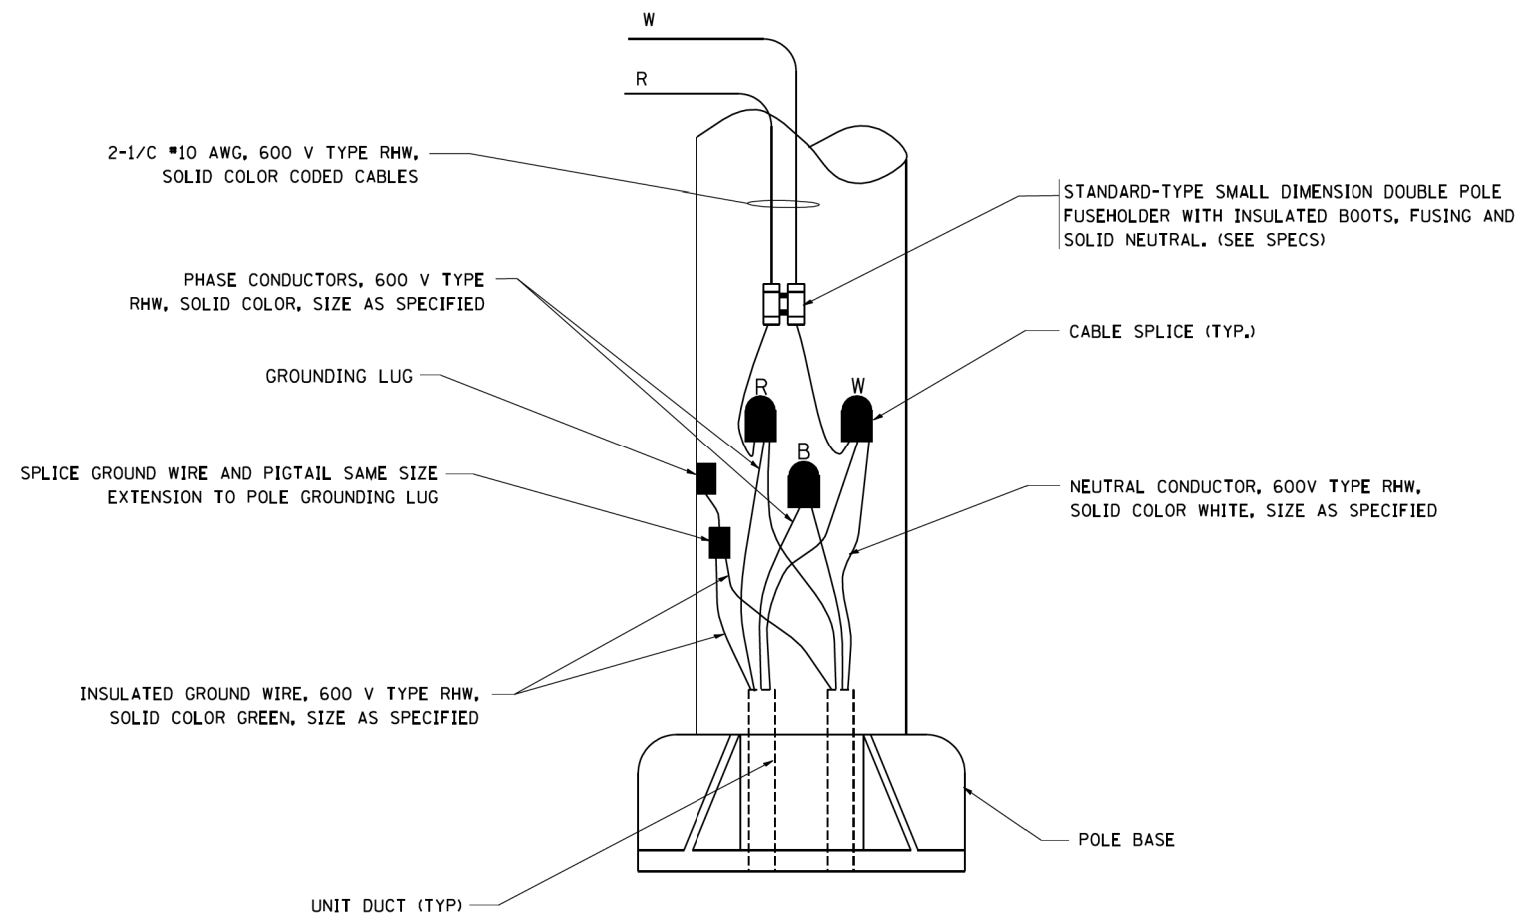

**POLE WIRING DETAIL**

N.T.S.

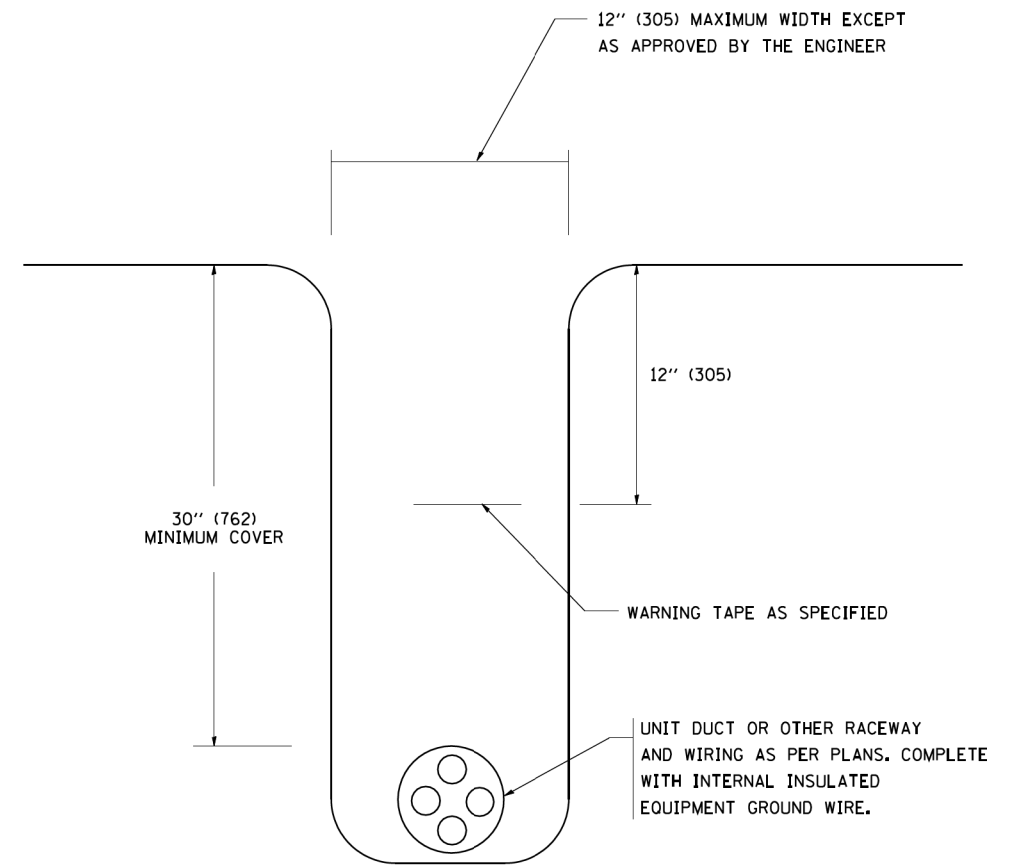

**TYPICAL WIRING IN TRENCH DETAIL**

N.T.S.

FILE NAME = W:\distad\22x34\be702.dgn

USER NAME = geglano

DESIGNED - REVISED - 08-08-03

DRAWN - REVISED -

PLOT SCALE = 50.000' / IN.

CHECKED - REVISED -

PLOT DATE = 1/4/2008

DATE - REVISED -

**STATE OF ILLINOIS  
DEPARTMENT OF TRANSPORTATION**

**MISC. ELECTRICAL DETAILS  
SHEET A**

SCALE: NONE SHEET NO. 1 OF 1 SHEETS STA. TO STA.

F.A. RTE.	SECTION	COUNTY	TOTAL SHEETS	SHEET NO.
0003	18A-2	MCHENRY	825	328
<b>BE-702</b>		<b>CONTRACT NO. 60F72</b>		
FED. ROAD DIST. NO. 1 ILLINOIS FED. AID PROJECT				