



TYPICAL SPLICE DETAIL
N.T.S.

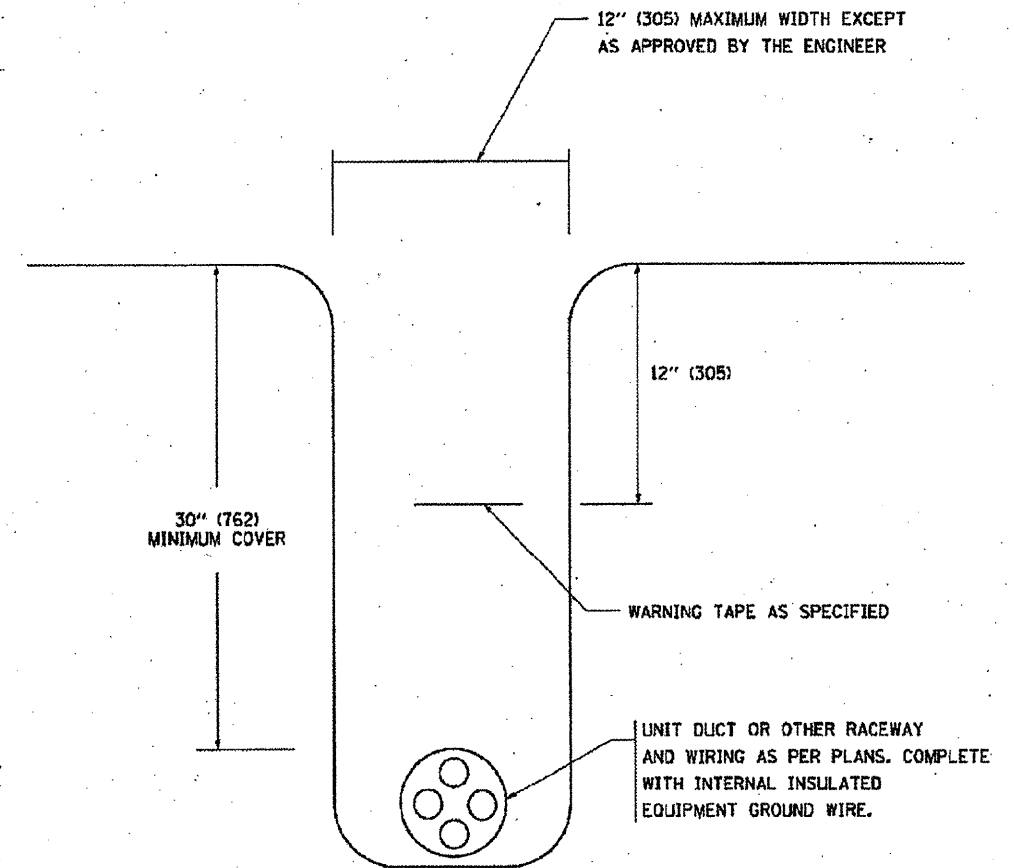

TYPICAL WIRING IN TRENCH DETAIL
N.T.S.

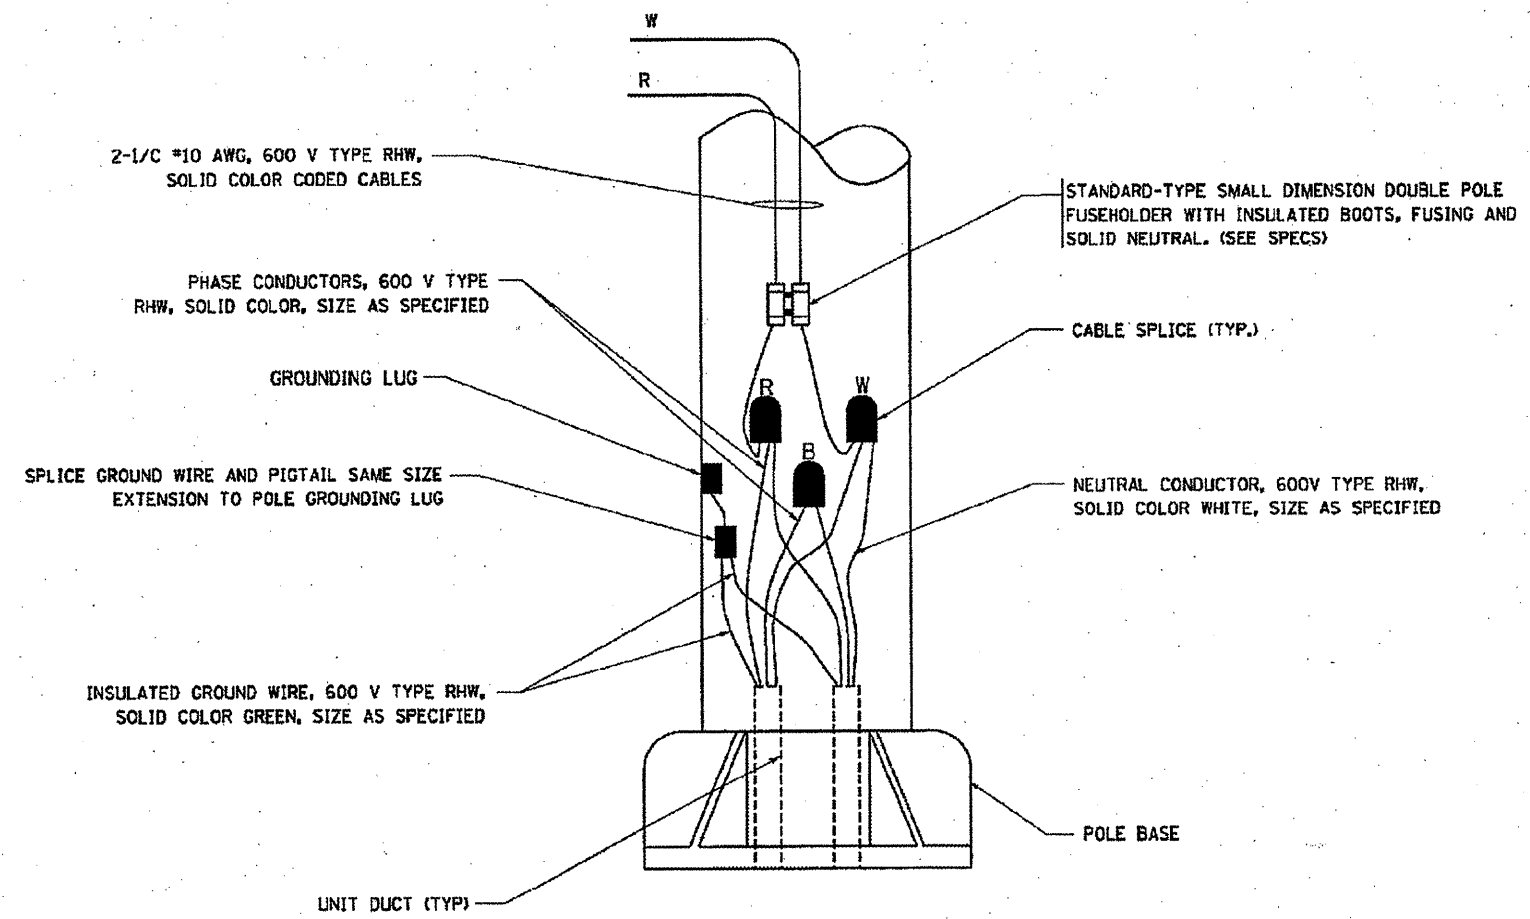

POLE WIRING DETAIL
N.T.S.

FILE NAME = W:\dist\td\22-34\bo702.dgn	USER NAME = geg10n0bt	DESIGNED -	REVISED - 08-08-03	STATE OF ILLINOIS DEPARTMENT OF TRANSPORTATION	MISC. ELECTRICAL DETAILS SHEET A			F.A.P. RTE. 350	SECTION 2010-050-1	COUNTY COOK	TOTAL SHEETS 44	SHEET NO. 25
	PLOT SCALE = 68,000' / IN.	CHECKED -	REVISED -					BE-702	CONTRACT NO. 60L26			
	PLOT DATE = 1/4/2009	DATE -	REVISED -		SCALE: NONE	SHEET NO. 1 OF 1 SHEETS	STA. TO STA.	FED. ROAD DIST. NO. 1 ILLINOIS FED. AID PROJECT				