




- 200 STA 3958+53.2, 58.3 LT MANHOLE TYPE A, 5' DIA. TYPE 1 FRAME, CLOSED LID RIM EL 697.78 INV EL 692.54 (NW) 30" INV EL 692.54± (S) 30"
- 201 STA 3958+76.2, 75.9 LT MANHOLE TYPE A, 5' DIA. TYPE 1 FRAME, CLOSED LID RIM EL 697.37 INV EL 692.61 (N) 36" INV EL 692.61 (SE) 30"
- 202 STA 3963+04.7, 65.0 LT MANHOLE TYPE A, 5' DIA. TYPE 1 FRAME, CLOSED LID RIM EL 699.98 INV EL 693.84 (NW) 36" INV EL 693.84 (S) 36"
- 203 STA 3963+37.0, 89.5 LT MANHOLE TYPE A, 5' DIA. TYPE 1 FRAME, CLOSED LID RIM EL 700.81 INV EL 693.94 (N) 36" INV EL 693.94 (SE) 36"
- 204 STA 3963+76.5, 34.1 LT MANHOLE TYPE A, 7' DIA. TYPE 1 FRAME, OPEN LID RIM EL 685.26 INV EL 676.03 (N) 42" INV EL 676.03 (W) 36"
- 205 STA 3964+07.7, 34.0 LT MANHOLE TYPE A, 7' DIA. TYPE 1 FRAME, OPEN LID RIM EL 684.95 INV EL 680.80± (N) 18" INV EL 676.08 (S) 36" INV EL 677.41± (E) 36" INV EL 677.41± (W) 36"
- 206 STA 3964+20.2, 35.1 LT EXISTING MANHOLE RIM EL 684.90 INV EL 680.10 (N) 18" INV EL 680.10 (S) 18"

- 201 24' - 30" SS CLASS B TYPE 2 @ 0.29%
- 202 420' - 36" SS CLASS A TYPE 2 @ 0.29%
- 203 36' - 36" SS CLASS A TYPE 2 @ 0.29%
- 203A 19' - 36" SS CLASS A TYPE 2 @ 0.29%
- 204 16' - 42" SS CLASS A TYPE 2 @ 0.20%
- 205 24' - 36" SS CLASS A TYPE 2 @ 0.20%
- 206 7' - 18" SS CLASS B TYPE 2 @ 0.12±%

STORM SEWER REMOVAL - 36"  
 STA 3964+07.9 TO 3964+07.9 - 8'  
 STORM SEWER REMOVAL - 18"  
 STA 3964+07.9 TO 3964+20.2 - 10'  
 STORM SEWER REMOVAL - 12"  
 STA 3963+68.1 TO 3963+80.6 - 10'

PLUG EXISTING STORM SEWERS  
 STA 3963+68.1, 35.1 LT  
 REMOVING MANHOLES  
 STA 3963+80.6, 35.1 LT

- LEGEND
- [R] REMOVING MANHOLES
  - [F] FILLING MANHOLES
  - /// STORM SEWER REMOVAL
  - [X] CLASS C PATCHES, TYPE IV, 10 INCH
  - [■] COMB CURB GUTTER REM REPLACE WITH COMB CC&G TB6.18

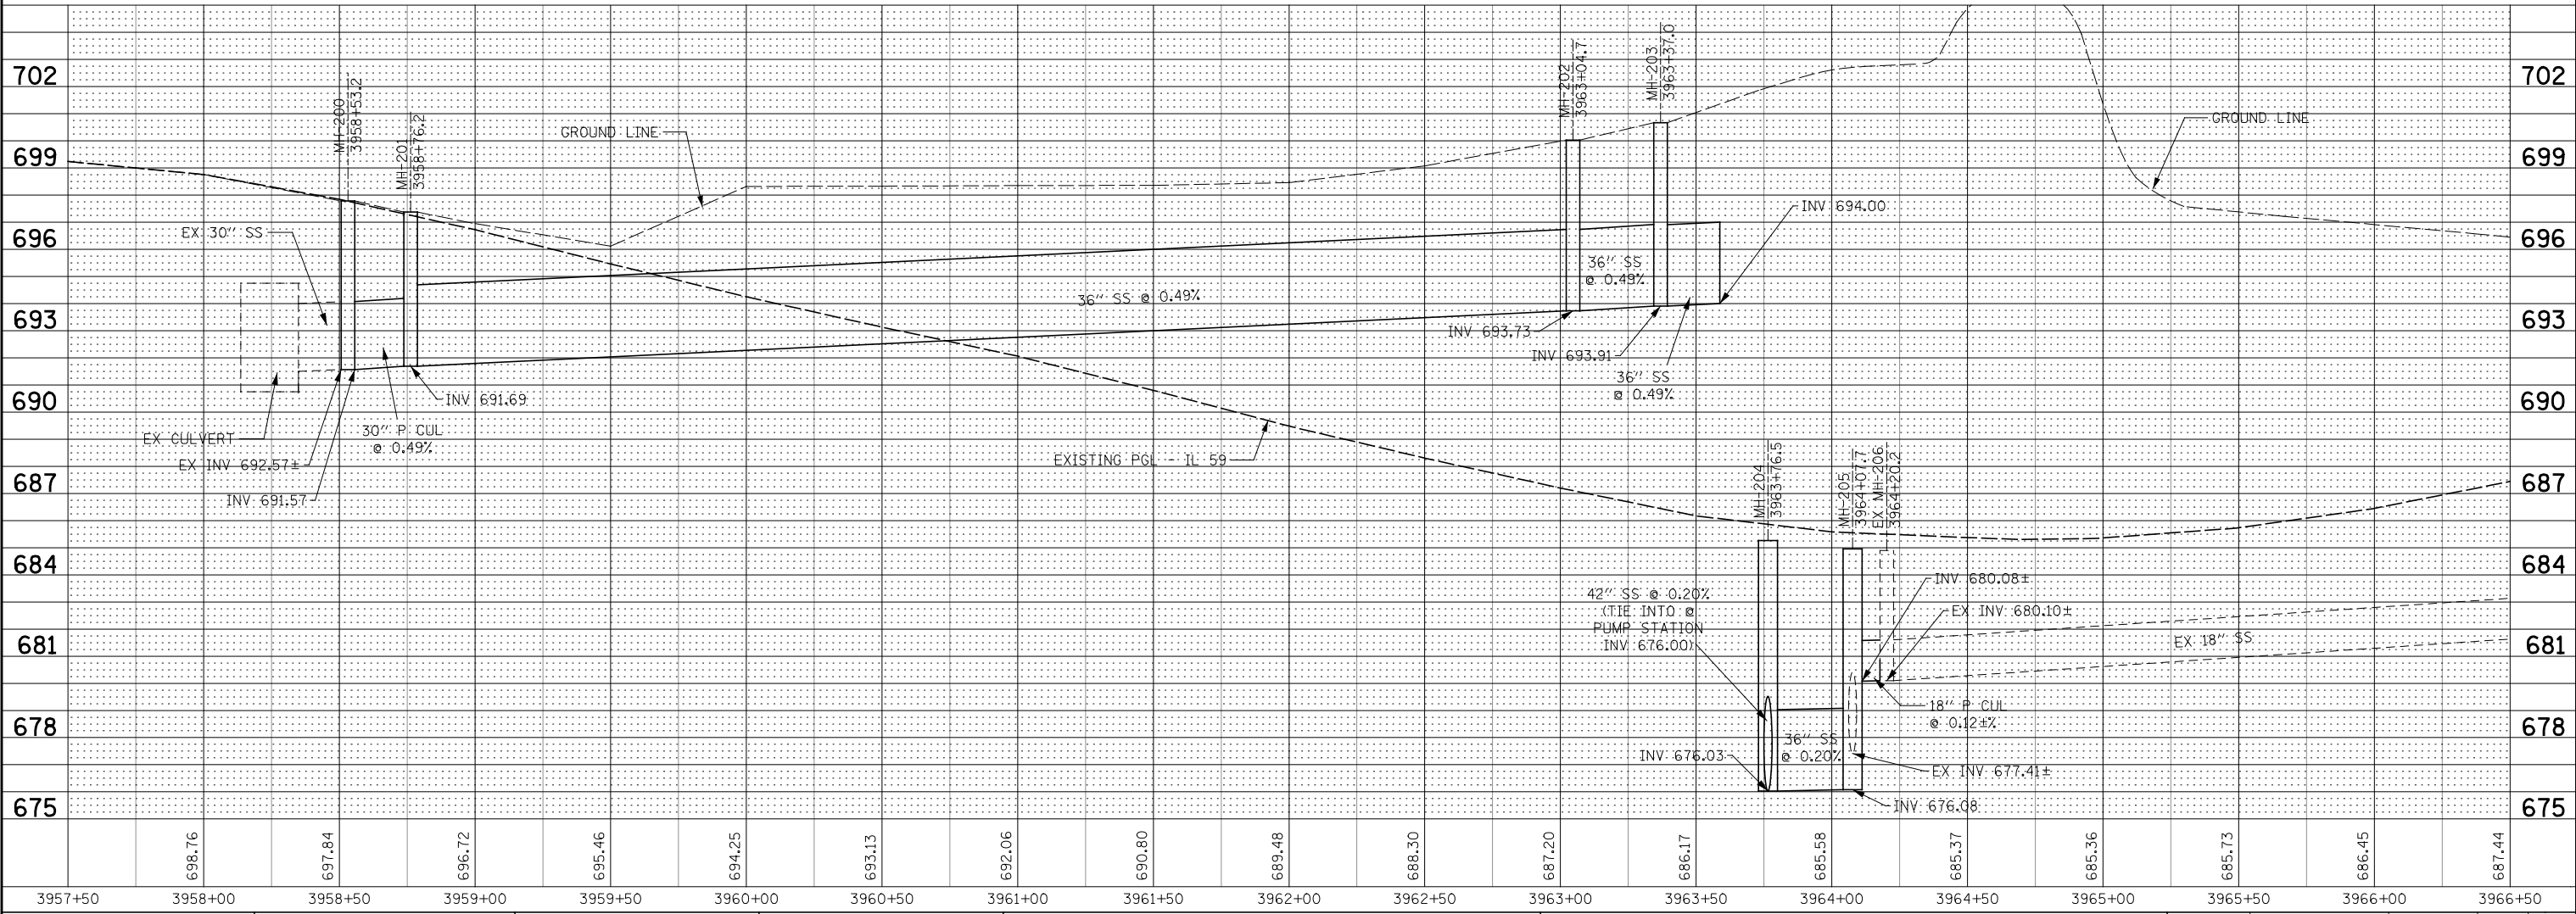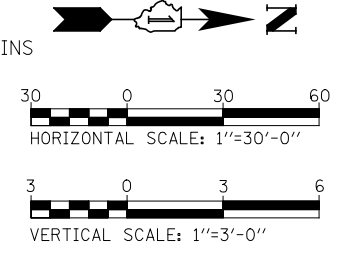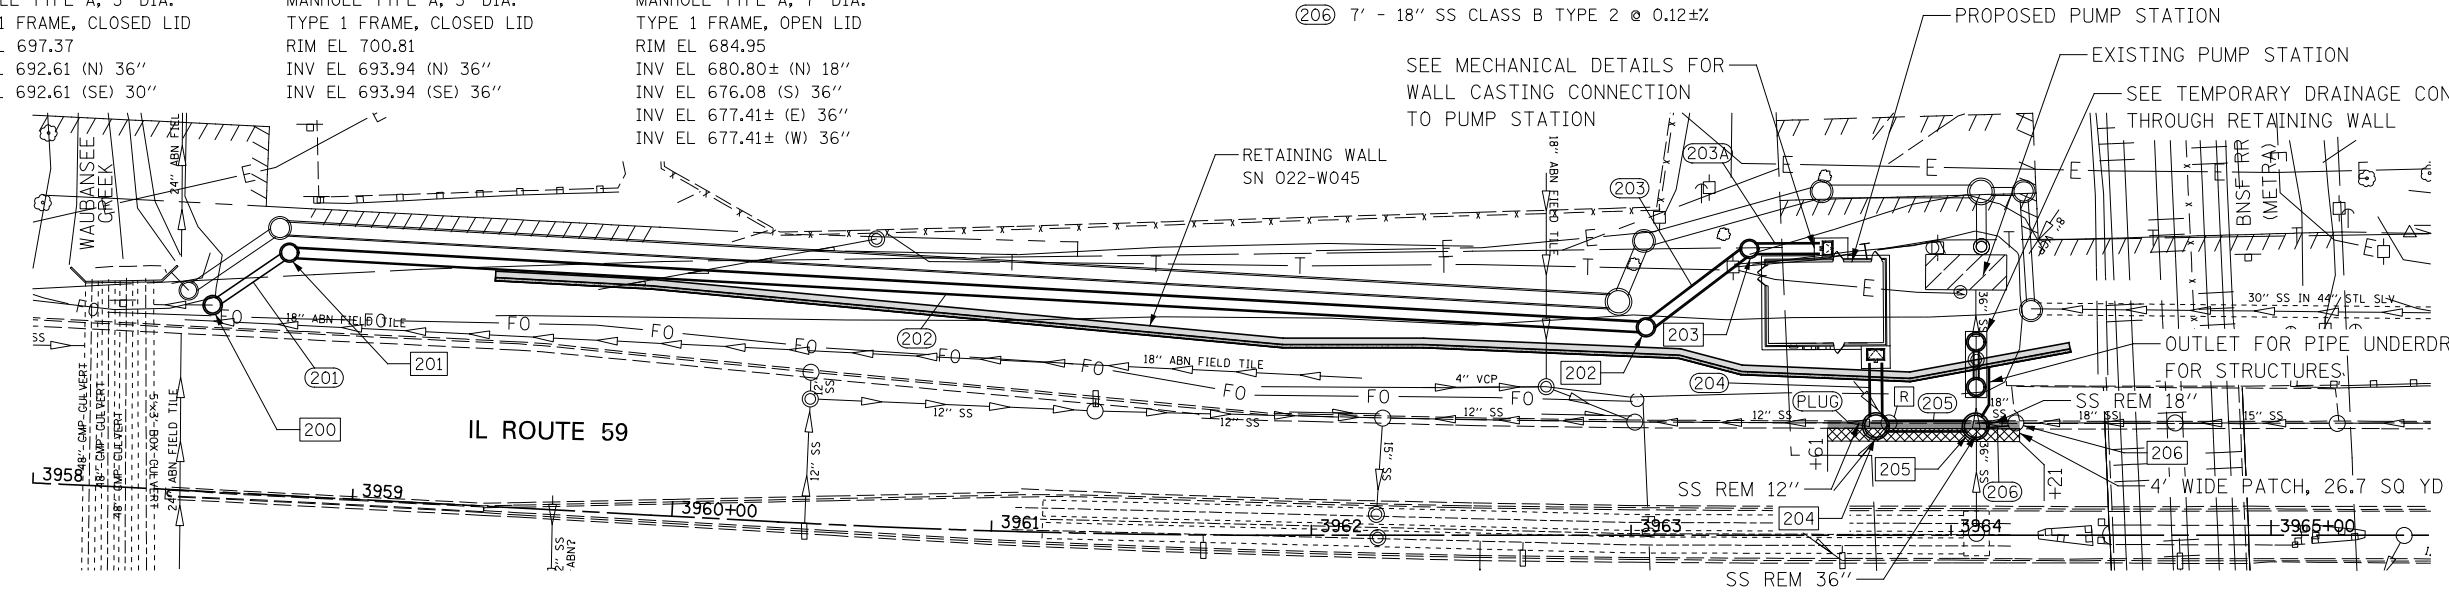

PLAN	SURVEYED	BY	DATE
	PLOTTED		
	ALIGNED		
	CHECKED		
	FILED		
	NO.		

PROFILE	SURVEYED	BY	DATE
	PLOTTED		
	GRADES CHECKED		
	STRUCTURE NOTATIONS CHECKED		
	NO.		

FILE NAME =	USER NAME = #USER#	DESIGNED - DMS	REVISED -	F.A.P. RTE.	SECTION	COUNTY	TOTAL SHEETS	SHEET NO.
*FILE#		DRAWN - KEA	REVISED -	338/IL 59	2011-035-I	DUPAGE	181	22
	PLOT SCALE = #SCALE#	CHECKED - PJO	REVISED -	CONTRACT NO. 60P41				
	PLOT DATE = #DATE#	DATE - 12-14-11	REVISED -	ILLINOIS FED. AID PROJECT				

STATE OF ILLINOIS  
 DEPARTMENT OF TRANSPORTATION

DRAINAGE PLAN / PROFILE - STAGE 2

SCALE: AS SHOWN SHEET NO. OF SHEETS STA. 3958+00 TO STA. 3965+50