




**1 ROOF PLAN**  
SCALE: 1/4" = 1'-0"

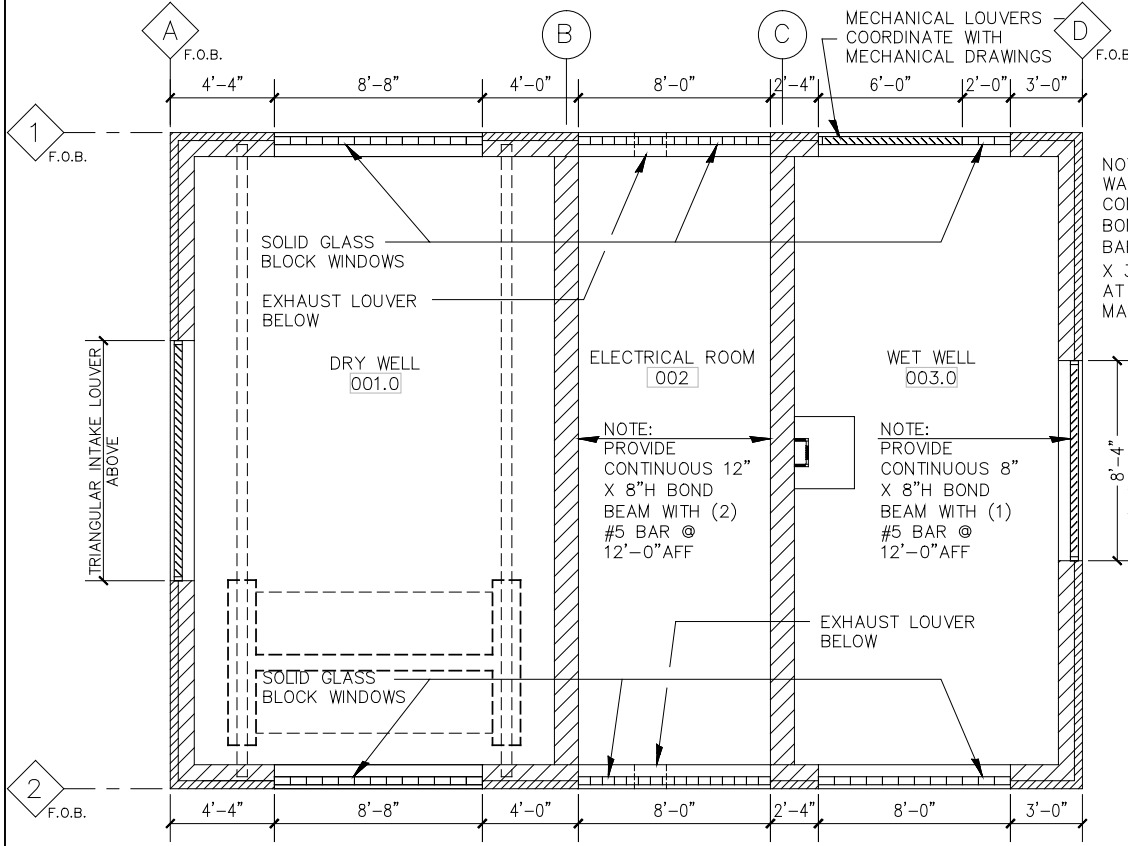


**2 CLERESTORY PLAN**  
SCALE: 1/4" = 1'-0"

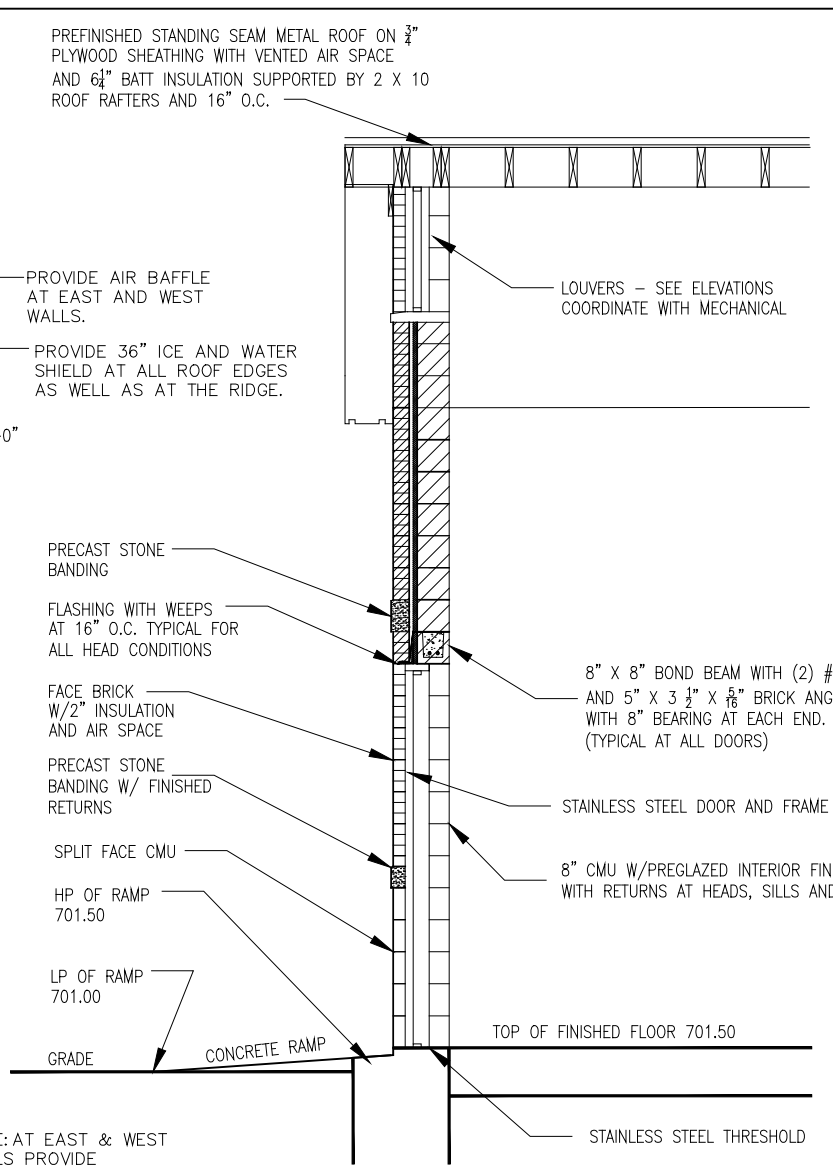


**3 WALL SECTION**  
SCALE: 1/2" = 1'-0"

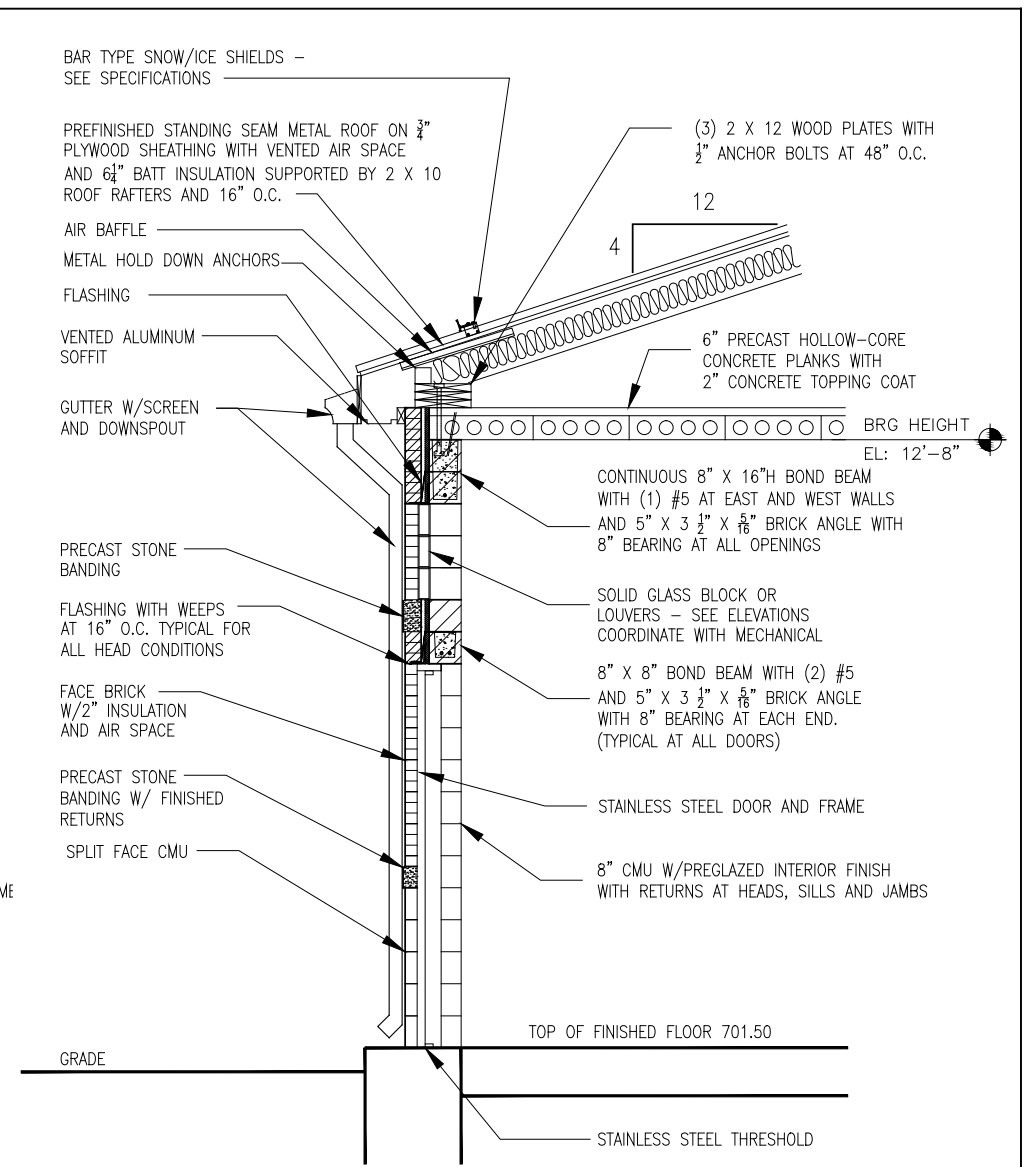


**4 WALL SECTION**  
SCALE: 1/2" = 1'-0"

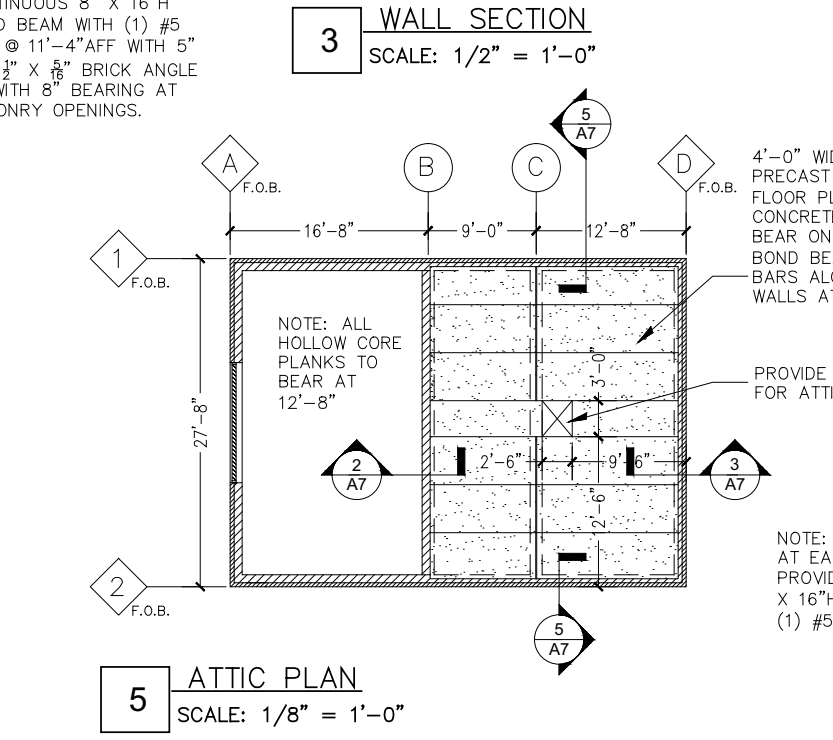

**5 ATTIC PLAN**  
SCALE: 1/8" = 1'-0"

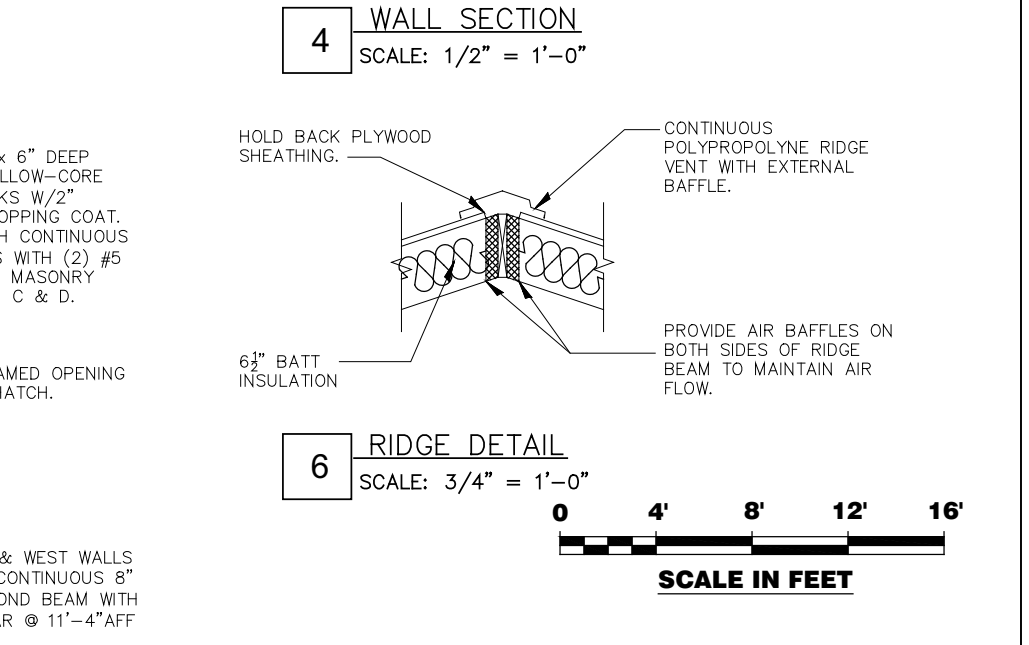

 **6 RIDGE DETAIL**  
SCALE: 3/4" = 1'-0"



**KNIGHT**  
Engineers & Architects

DESIGNED RMK  
CHECKED RMK  
DRAWN NMP  
DATE 03-22-2012

REVISED -  
REVISED -  
REVISED -  
REVISED -

**STATE OF ILLINOIS**  
**DEPARTMENT OF TRANSPORTATION**

**ROOF PLAN**  
**PUMP STATION 47**  
SHEET NO. A3 OF 12 SHEETS

F.A.P. RTE.	SECTION	COUNTY	TOTAL SHEETS	SHEET NO.
338/IL 59	2011-035-1	DUPAGE	181	66
CONTRACT NO. 60P41				
ILLINOIS FED. AID PROJECT				