


**1 PUMP STATION SECTION**  
SCALE: 1/4" = 1'-0"

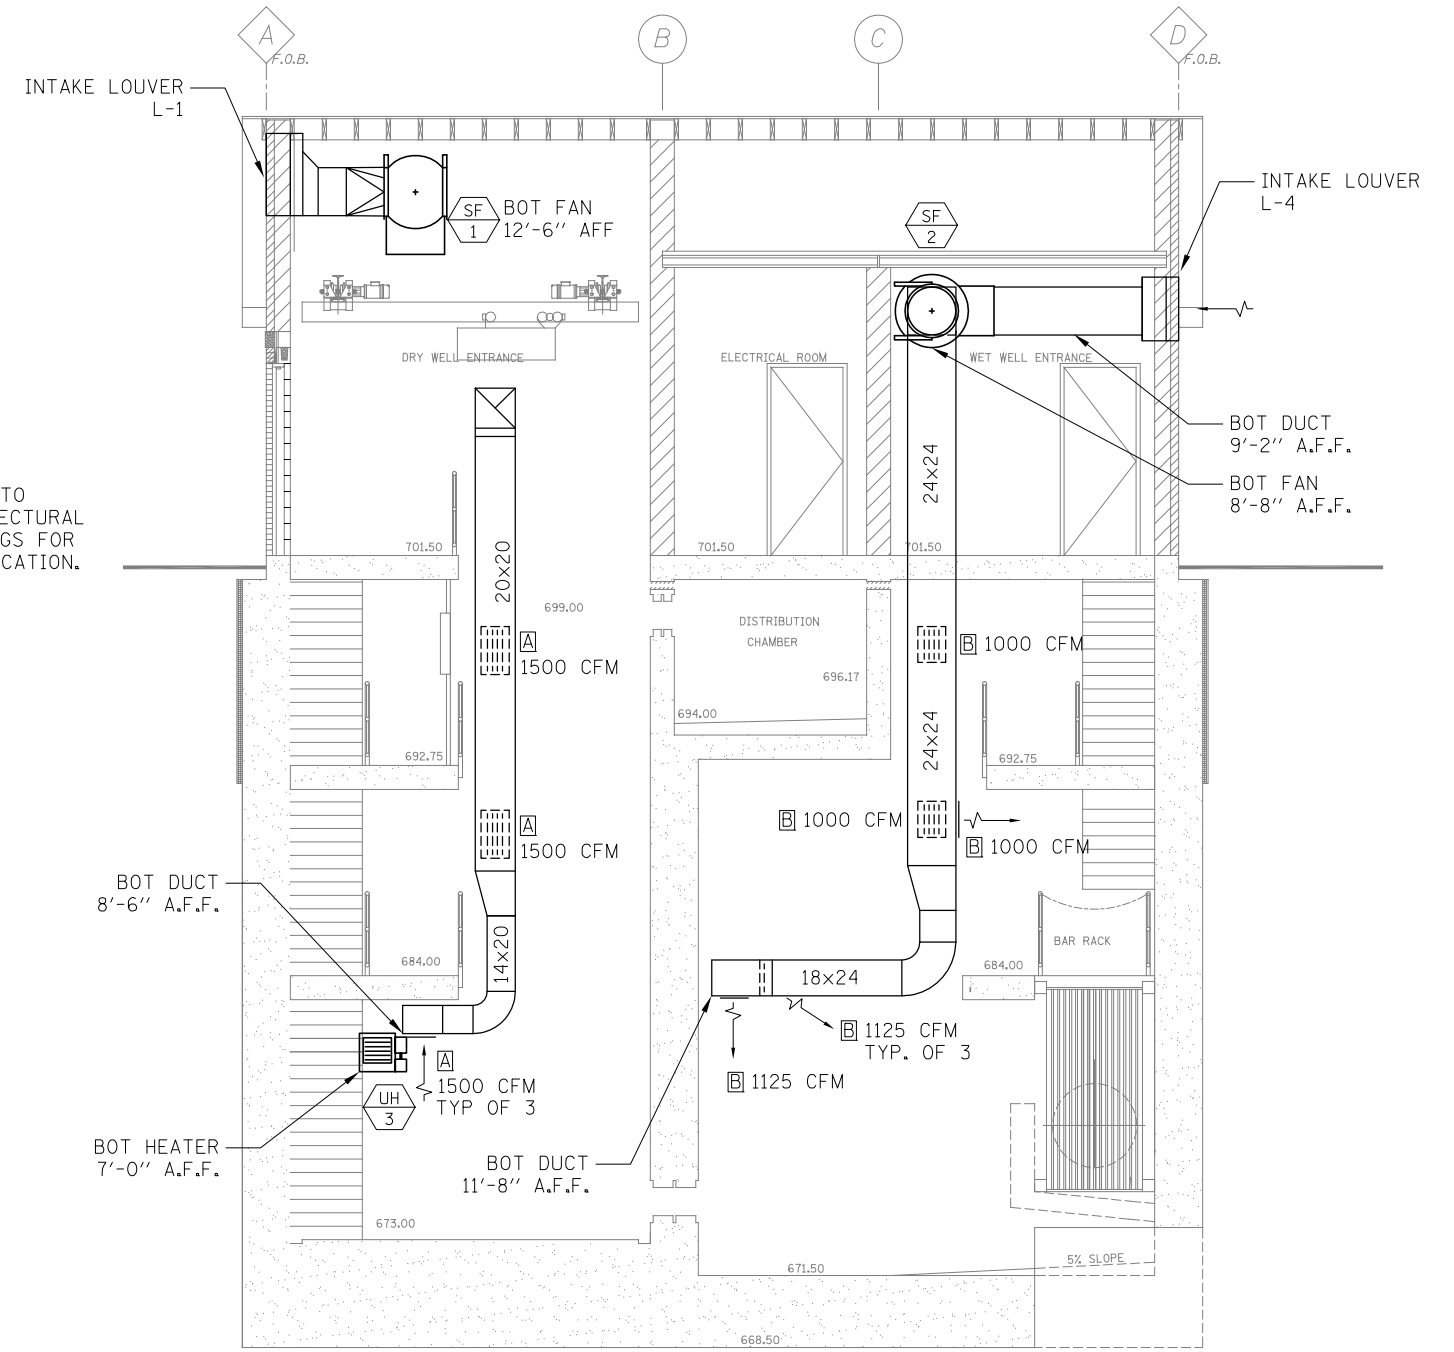

**2 PUMP STATION SECTION**  
SCALE: 1/4" = 1'-0"



**McDonough Associates Inc.**  
Engineers/Architects  
130 East Randolph Street, Suite 1000  
Chicago, Illinois 60601 Phone (312) 946-8600

DESIGNED	WMC	REVISED	-
CHECKED	RS	REVISED	-
SCALE	WMC	REVISED	-
DATE	03/22/2012	REVISED	-

**STATE OF ILLINOIS**  
**DEPARTMENT OF TRANSPORTATION**

**HEATING AND VENTILATION PLANS**  
**PUMP STATION 47**  
SHEET NO. HV3 OF 5 SHEETS

F.A.P. RTE.	SECTION	COUNTY	TOTAL SHEETS	SHEET NO.
338/IL 59	2011-035-I	DUPAGE	181	121
CONTRACT NO. 60P41			ILLINOIS FED. AID PROJECT	

HV3