


**1** PUMP STATION SECTION  
SCALE: 1/4" = 1'-0"

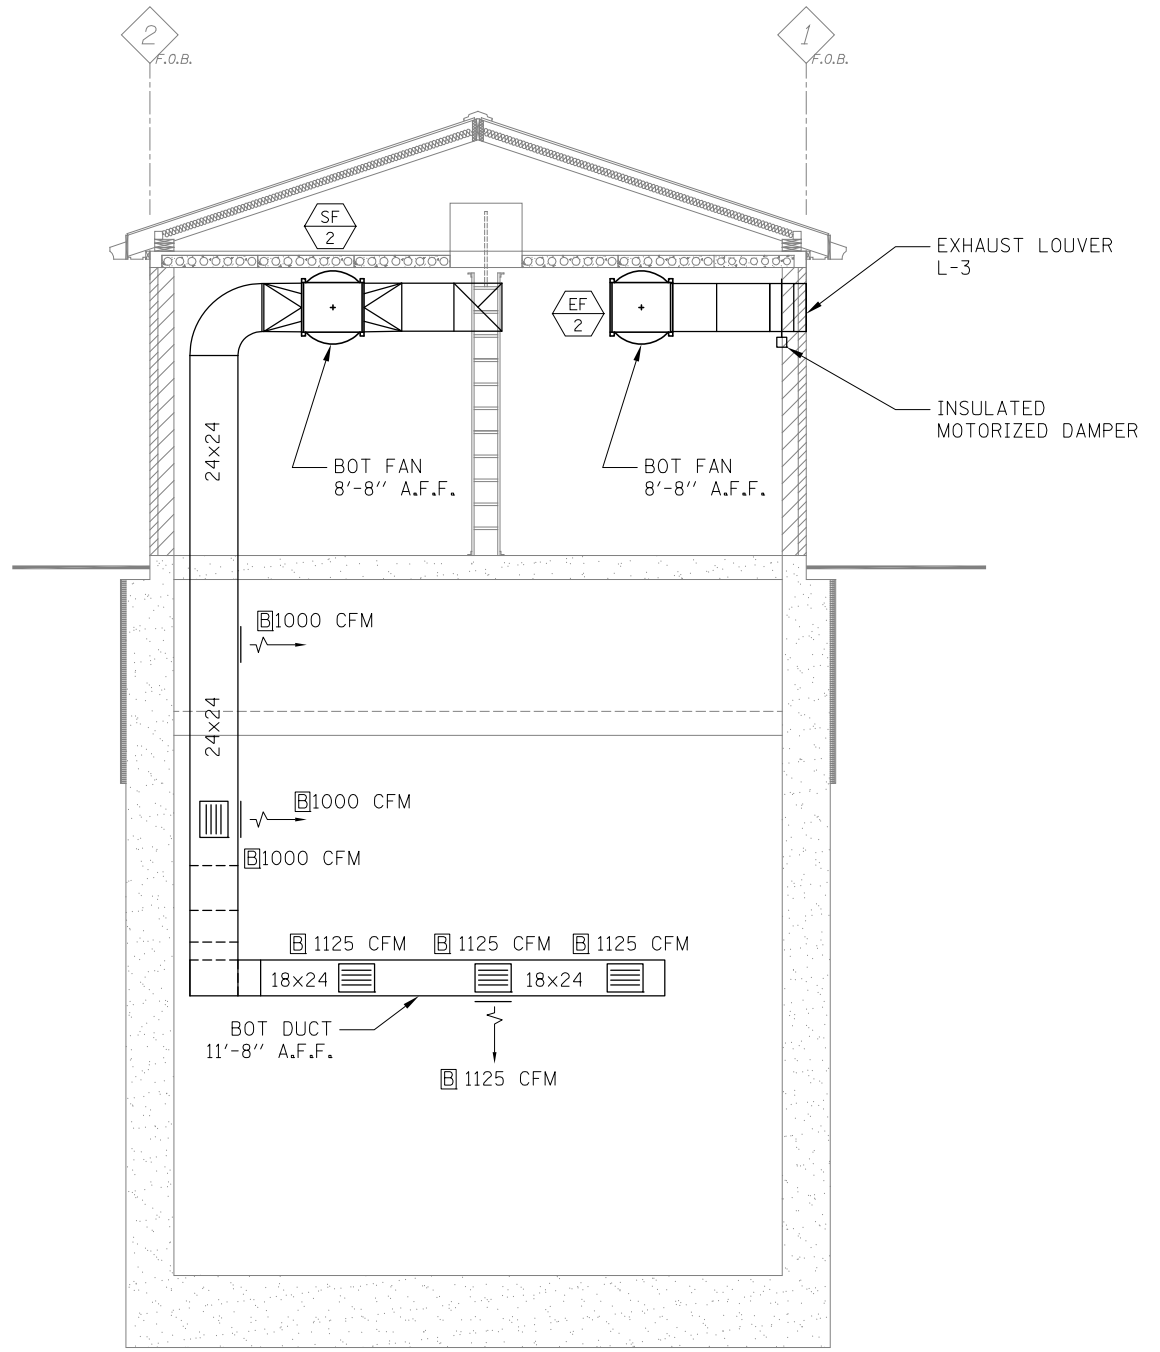

**2** PUMP STATION SECTION  
SCALE: 1/4" = 1'-0"



**McDonough Associates Inc.**  
Engineers/Architects  
130 East Randolph Street, Suite 1000  
Chicago, Illinois 60601 Phone (312) 546-8600

DESIGNED	WMC	REVISED	-
CHECKED	RS	REVISED	-
DRAWN	WMC	REVISED	-
CHECKED	RS	REVISED	-
DATE	03/22/2012		

**STATE OF ILLINOIS**  
**DEPARTMENT OF TRANSPORTATION**

**HEATING AND VENTILATION PLANS**  
**PUMP STATION 47**

SHEET NO. HV4 OF 5 SHEETS

F.A.P. RTE.	SECTION	COUNTY	TOTAL SHEETS	SHEET NO.
338/IL 59	2011-035-I	DUPAGE	181	122
CONTRACT NO. 60P41			ILLINOIS FED. AID PROJECT	

HV4