


F.A.P. RTE.	SECTION	COUNTY	TOTAL SHEETS	SHEET NO.
75	84-12; 11-3	•	729	452
STA.	TO STA.			
FED. ROAD DIST. NO. 5	ILLINOIS FED. AID PROJECT			
• SANGAMON AND CHRISTIAN				


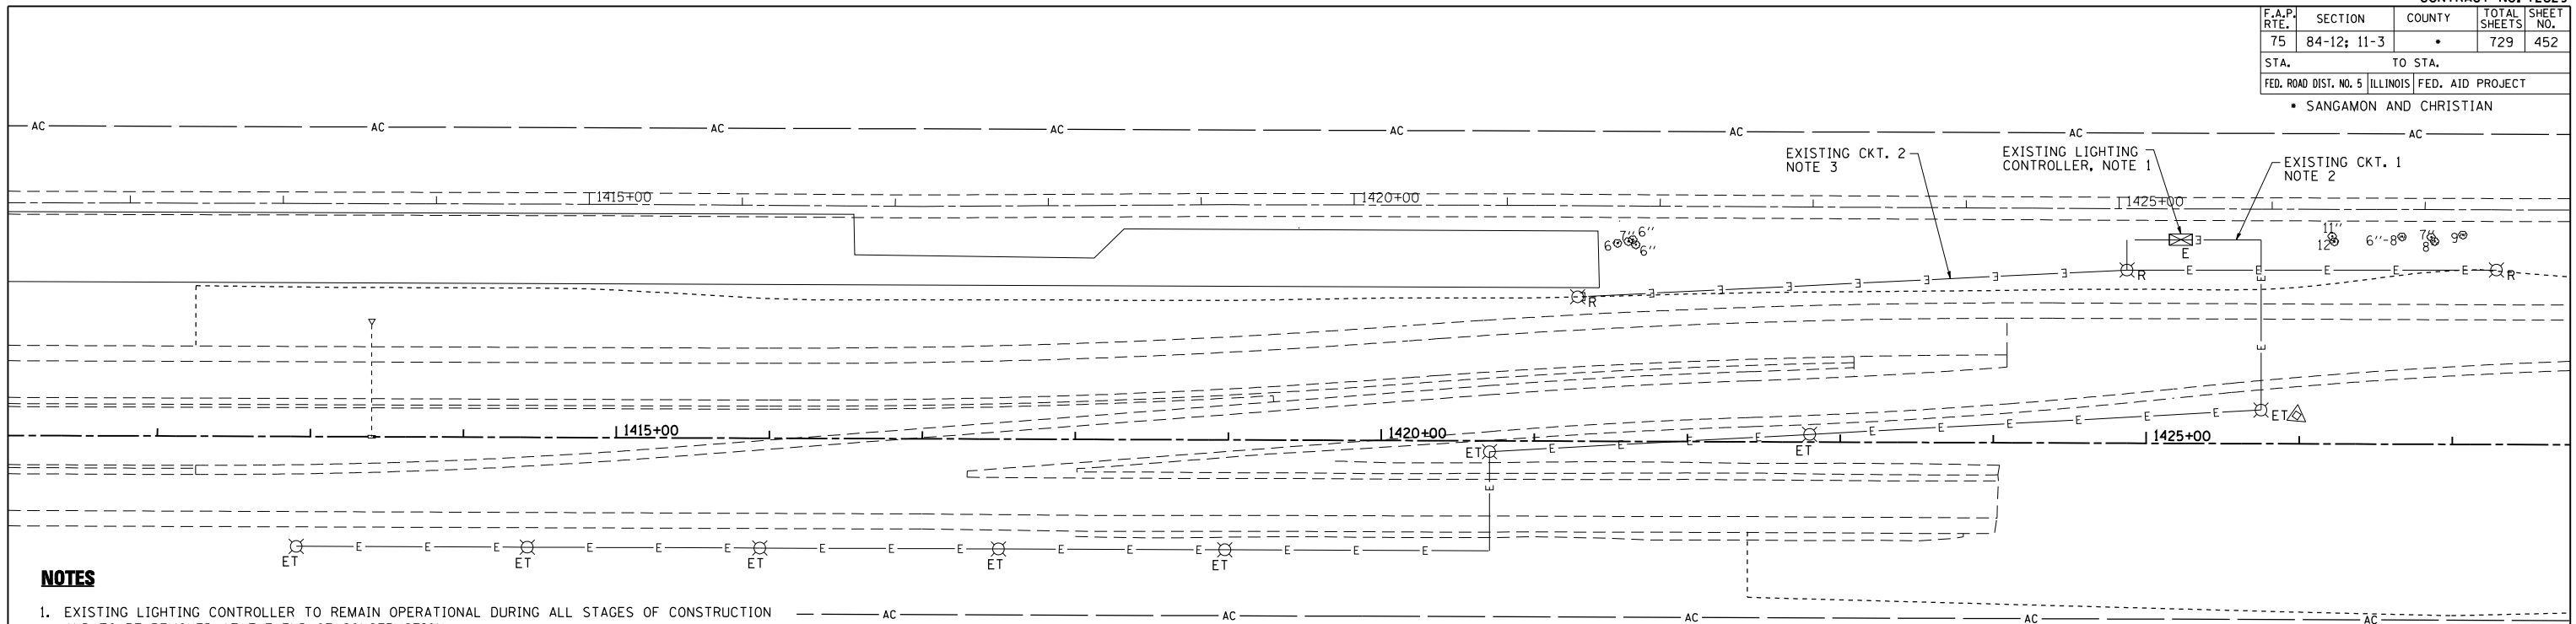


**NOTES**

- EXISTING LIGHTING CONTROLLER TO REMAIN OPERATIONAL DURING ALL STAGES OF CONSTRUCTION AND TO BE REMOVED AT THE END OF CONSTRUCTION.
- EXISTING CKT. NO. 1 TO REMAIN ENERGIZED DURING MOT STAGES 1 & 2 AND TO BE MODIFIED AS SHOWN ON TEMPORARY LIGHTING PLANS AT THE BEGINNING OF STAGE 3.
- EXISTING CKT. NO. 2 TO REMAIN ENERGIZED DURING MOT STAGES 1 & 2 AND TO BE REMOVED AT THE BEGINNING OF STAGE 3.
- THE LOCATIONS OF EXISTING LIGHT POLES AND EXISTING UNIT DUCT AS SHOWN ON THE PLANS ARE APPROXIMATE. THE CONTRACTOR SHALL VERIFY THE EXACT LOCATIONS IN THE FIELD PRIOR TO CONSTRUCTION.

**LEGEND**

- EXISTING LIGHTING UNIT TO BE REMOVED
- EXISTING LIGHTING UNIT USED AS TEMPORARY, AND THEN REMOVED
- EXISTING LIGHTING CONTROLLER

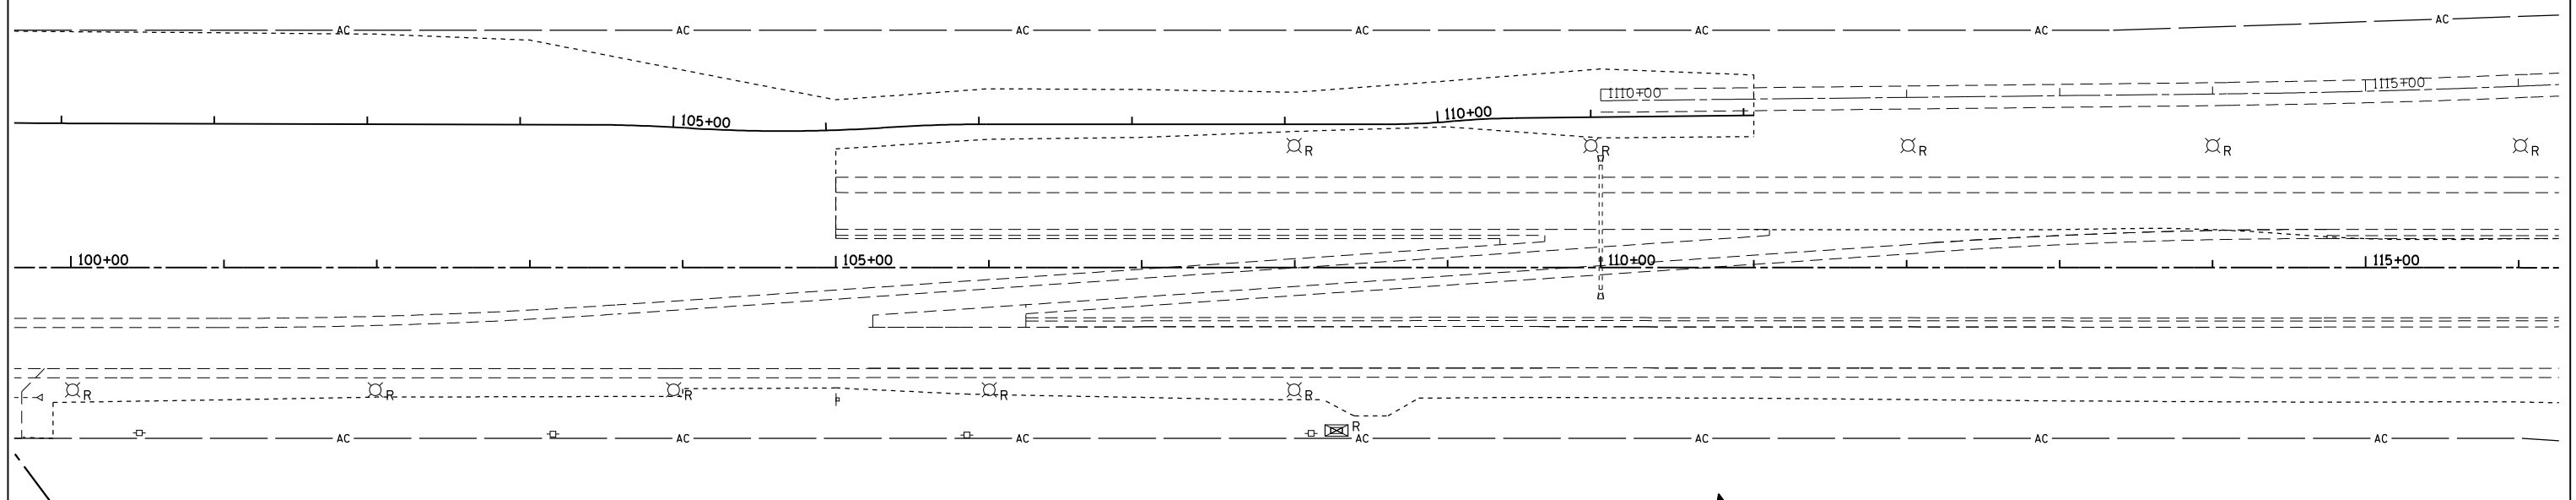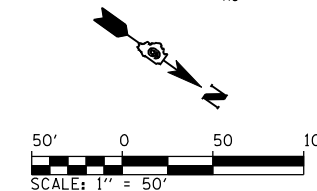


**NOTES**

- THE LOCATIONS OF EXISTING LIGHT POLES AND CONTROLLER AS SHOWN ON THE PLANS ARE APPROXIMATE. THE CONTRACTOR SHALL VERIFY THE EXACT LOCATIONS IN THE FIELD PRIOR TO CONSTRUCTION.

**LEGEND**

- EXISTING LIGHTING UNIT TO BE REMOVED
- EXISTING LIGHTING CONTROLLER TO BE REMOVED

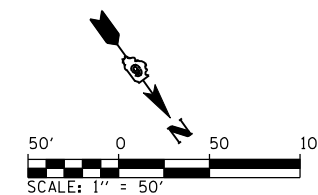

REVISIONS	
NAME	DATE

ILLINOIS DEPARTMENT OF TRANSPORTATION  
**EXISTING LIGHTING REMOVAL PLAN**  
 SOUTH CROSSOVER  
 NORTH CROSSOVER  
 SCALE: 1" = 50'  
 DATE: 03/06/2012  
 DRAWN BY: IDOT  
 CHECKED BY: J.M.M.

Default  
 Li:\DOT\030601\Draw\Sheets\030601\Draw\030601\Lighting\Removal\X-Over.sgn  
 5/9/2012