

F.A. RTE.	SECTION	COUNTY	TOTAL SHEETS	SHEET NO.
VAR	DISTRICT 8 2013-1	*	9	1
		ILLINOIS	CONTRACT NO. 76F68	

* ST. CLAIR/MADISON

STATE OF ILLINOIS
DEPARTMENT OF TRANSPORTATION
DIVISION OF HIGHWAYS




**PROPOSED
HIGHWAY PLANS**

VARIOUS ROUTES
D-8 PUMP STATIONS 2012-1
ST. CLAIR / MADISON COUNTY
PUMP STATION SUMP CLEANING
& ROOF REPLACEMENT

INDEX OF SHEETS

- 1 COVER SHEET
- 2 SCHEDULE OF QUANTITIES & HIGHWAY STANDARDS
- 3 LOCATION NO. 1 SITE PLAN MISSOURI AVE. PUMP (ROOF REPLACEMENT)
- 4 LOCATION NO. 1 DETAILS MISSOURI AVE. PUMP (SUMP CLEANING)
- 5 LOCATIONS NO. 2 SITE PLAN 25th STREET PUMP
- 6 LOCATION NO. 2 DETAILS 25th STREET PUMP (SUMP CLEANING)
- 7 LOCATION NO. 3 SITE PLAN 42nd STREET PUMP (ROOF REPLACEMENT)
- 8 LOCATION NO. 4 SITE PLAN McCAMBRIDGE PUMP (ROOF REPLACEMENT)
- 9 LOCATION NO. 5 SITE PLAN GRAYS FARM (ROOF REPLACEMENT)

D-98-055-12

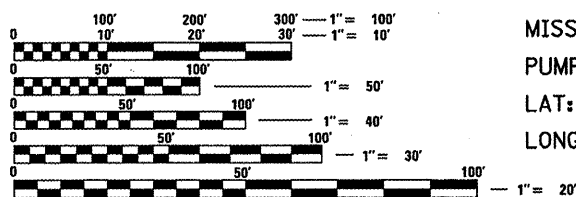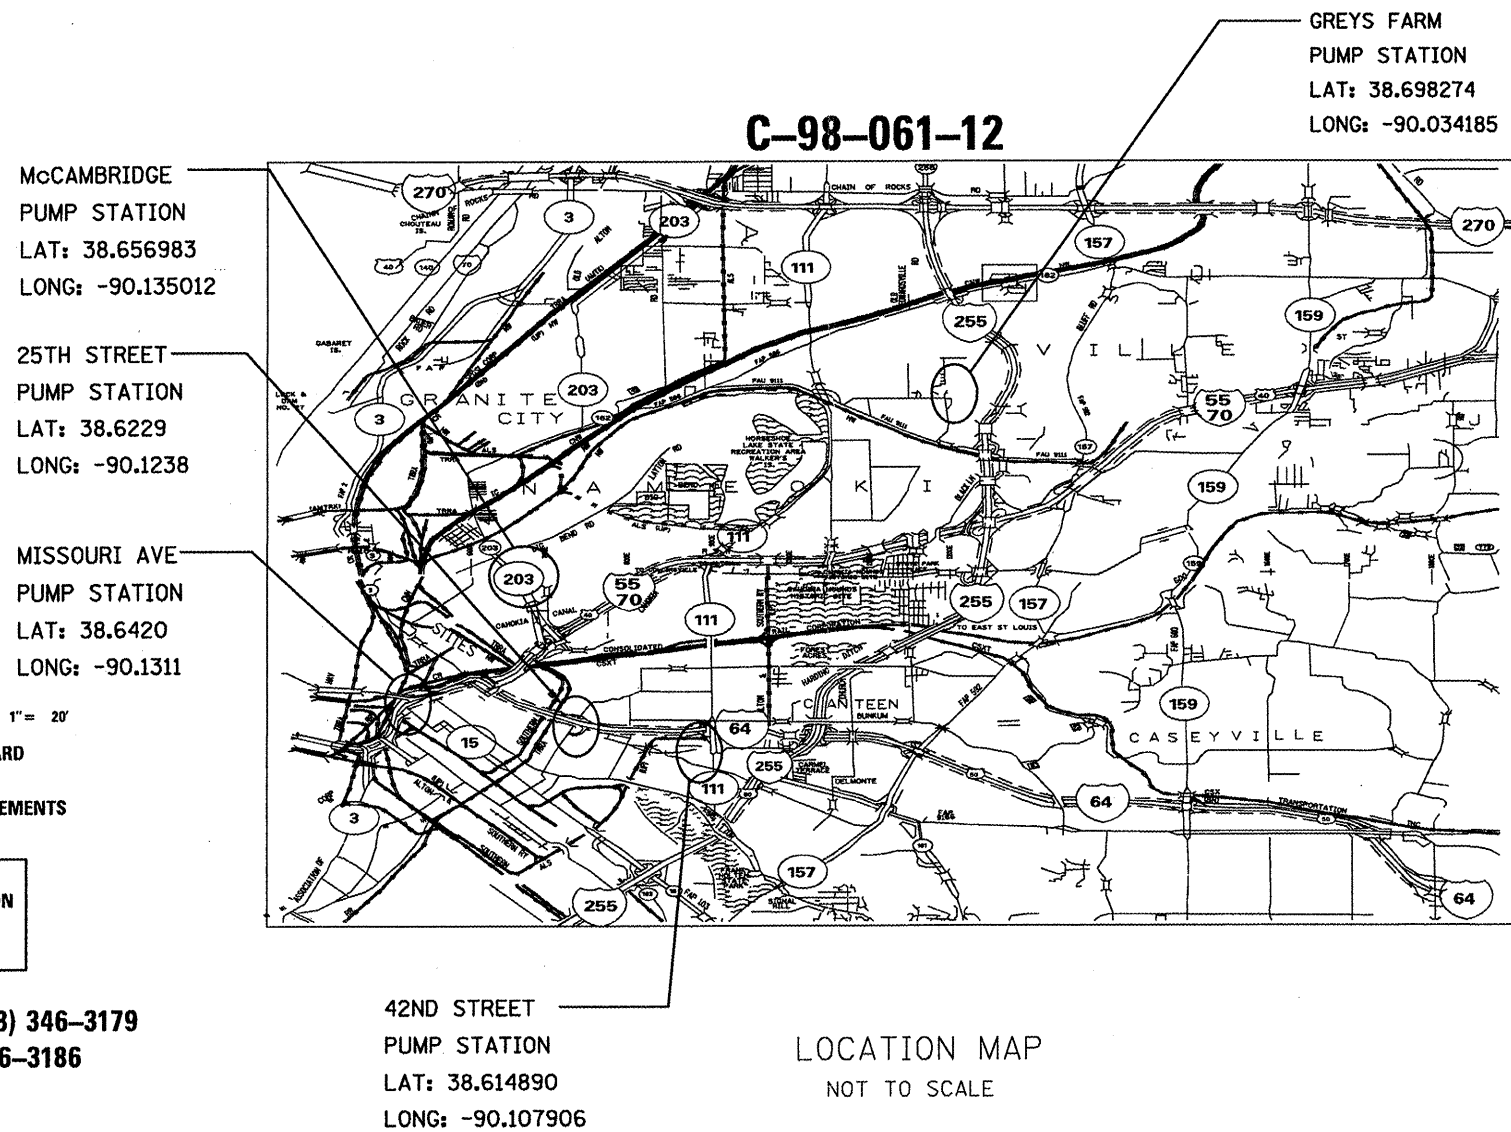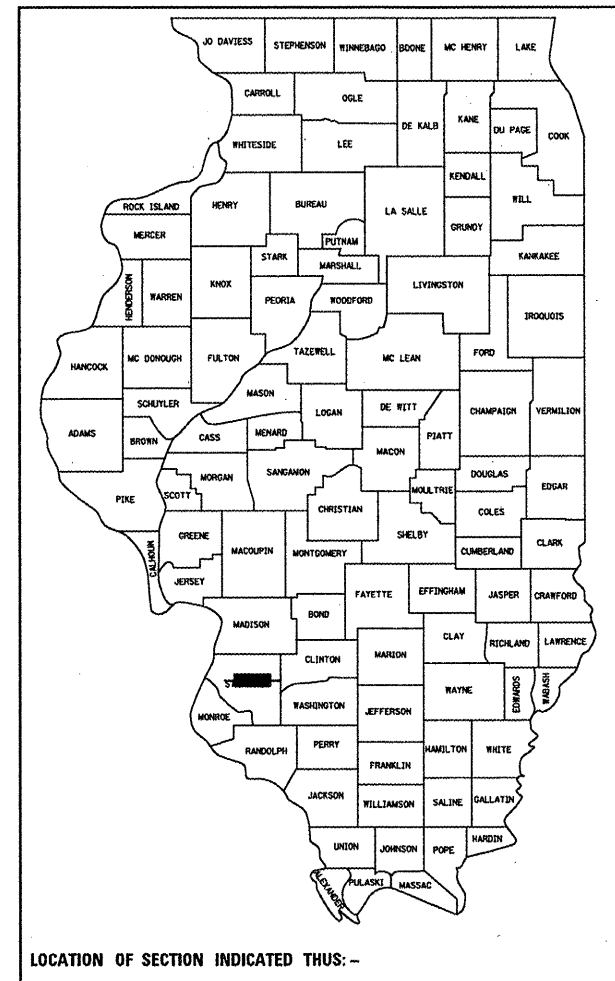

FULL SIZE PLANS HAVE BEEN PREPARED USING STANDARD ENGINEERING SCALES. REDUCED SIZED PLANS WILL NOT CONFORM TO STANDARD SCALES. IN MAKING MEASUREMENTS ON REDUCED PLANS, THE ABOVE SCALES MAY BE USED.

J.U.L.I.E.
JOINT UTILITY LOCATION INFORMATION FOR EXCAVATION
1-800-892-0123
OR 811

PROJECT ENGINEER: PATTI LeBEAU (618) 346-3179
SQUAD LEADER: BILLIE OWEN (618) 346-3186

CONTRACT NO. 76F68

STATE OF ILLINOIS
DEPARTMENT OF TRANSPORTATION
DIVISION OF HIGHWAYS

SUBMITTED *March 23 20 12*

John D. Baranelli
DEPUTY DIRECTOR OF HIGHWAYS, REGION 5 ENGINEER

John D. Baranelli
acting ENGINEER OF DESIGN AND ENVIRONMENT

May 11 20 12

William R. Peja
acting DIRECTOR OF HIGHWAYS, CHIEF ENGINEER

**PRINTED BY THE AUTHORITY
OF THE STATE OF ILLINOIS**