



TYPICAL TUNNEL SECTION
NOT TO SCALE

SCHEDULE OF QUANTITIES

Code No.	Unit	Quantity		Description
		Security	Lighting	
80400100	EACH		1	ELECTRIC SERVICE INSTALLATION
81028350	FOOT		123	UNDERGROUND CONDUIT, PVC, 2" DIA.
81028550	FOOT		5	UNDERGROUND CONDUIT, INTERMEDIATE METAL, 2" DIAMETER
81104600	FOOT	470	248	CONDUIT ATTACHED TO STRUCTURE, 2" DIA. INTERMEDIATE METAL
81300220	EACH	10	1	JUNCTION BOX, STAINLESS STEEL, ATTACHED TO STRUCTURE, 6"X6"X4"
81500120	EACH		1	GULFBOX JUNCTION, COMPOSITE CONCRETE
81702450	FOOT		353	ELECTRIC CABLE IN CONDUIT, 600V (XLP-TYPE USE) 3-1/C NO.10
87301805	FOOT	364		ELECTRIC CABLE IN CONDUIT, SERVICE, NO. 6 2C
87301815	FOOT		32	ELECTRIC CABLE IN CONDUIT, SERVICE, NO. 6 3C
X0322283	EACH		1	VIDEO SURVEILLANCE SYSTEM, COMPLETE
	EACH		5	TUNNEL LUMINAIRE, INDUCTION, SURFACE MOUNTED, 100 WATT
	FOOT	1290		ELECTRIC CABLE IN CONDUIT, CAMERA POWER, NO. 18 2C
Z0033050	FOOT	1290		COAXIAL CABLE IN CONDUIT

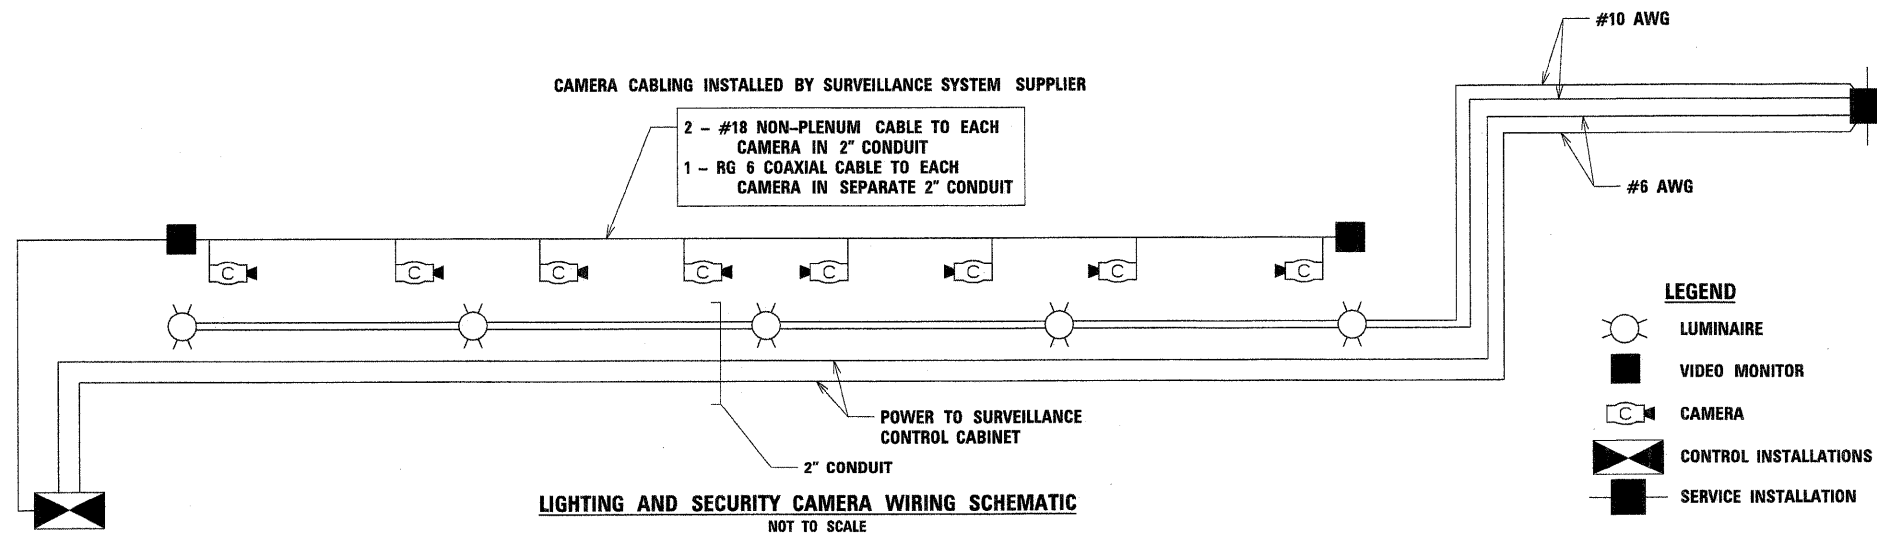

LIGHTING AND SECURITY CAMERA WIRING SCHEMATIC
NOT TO SCALE

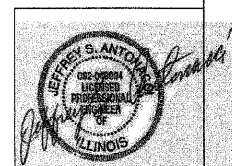

DATE: 02/03/2012
EXP: 11/30/2013

FILE NAME =	USER NAME = default	DESIGNED -	REVISOR -	STATE OF ILLINOIS DEPARTMENT OF TRANSPORTATION	DETAILS				F.A. RTE.	SECTION	COUNTY	TOTAL SHEETS	SHEET NO.	
H:\1200501 - Plummer Blvd Security and Lighting Plans\CADDData\CADD Sheets\shd.Details		DRAWN -	REVISOR -		SCALE:	SHEET	OF	SHEETS	STA.	TO STA.	10-00030-00-BT	SANGAMON	29	22
		CHECKED -	REVISOR -						PLUMMER BLVD. MULTI-USE TRAIL		CONTRACT NO. 93579		ILLINOIS FED. AID PROJECT	
		DATE -	REVISOR -											