
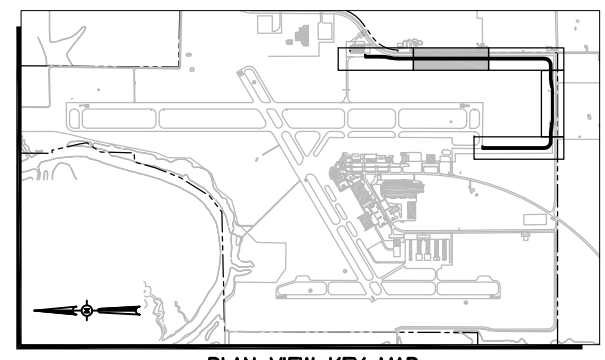




MAY 07 2012 5:29 PM HARR01115
 I:\JOBS\11A0037\11A0037D\CAD\AIRPORT\11A0037D\C-701-PNP

LEGEND

- (E)FO ——— EXISTING FIBER OPTIC LINE
- (E)G ——— EXISTING GAS LINE
- (E)W ——— EXISTING WATER LINE
- (E)E ——— EXISTING ELECTRICAL LINE
- (E)T ——— EXISTING TELEPHONE LINE
- (E)SS ——— EXISTING SANITARY LINE
- x — x ——— EXISTING CONTOURS
- - - 385 ——— EXISTING CONTOURS
- 385 ——— PROPOSED CONTOURS
- ——— PROPOSED IMPROVEMENTS
- SS —— PROPOSED STORM SEWER
- - - - - LIMITS OF PROPOSED GRADING

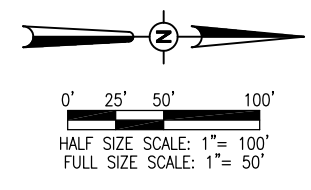

SO081

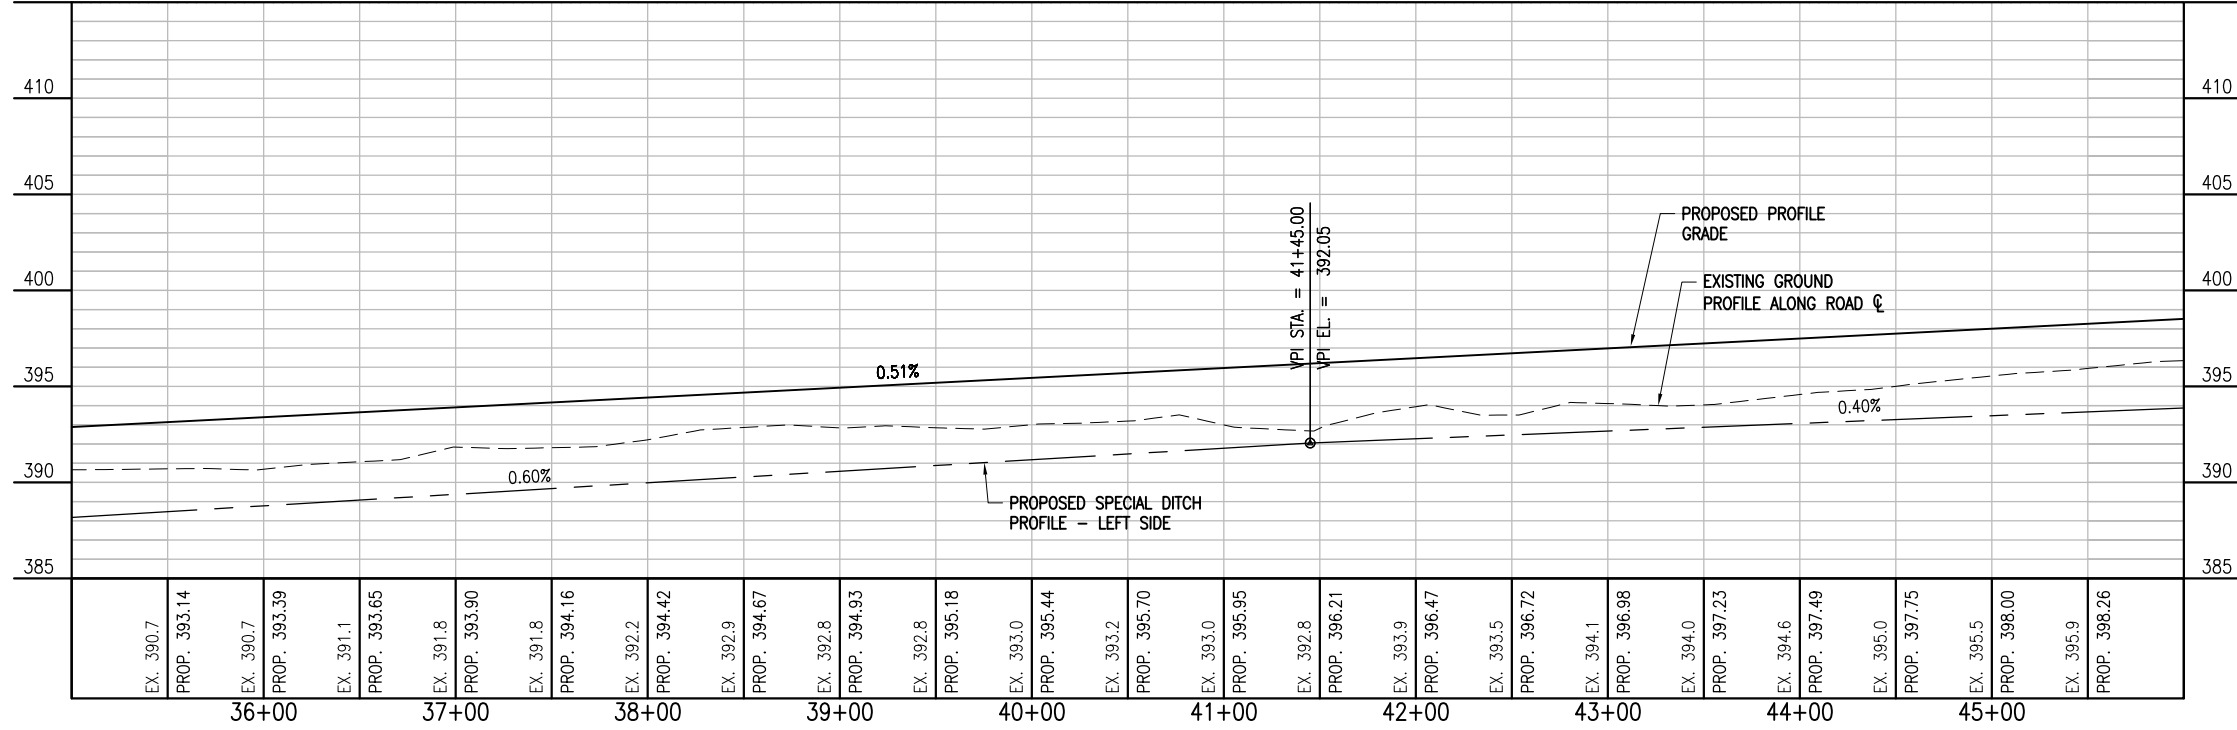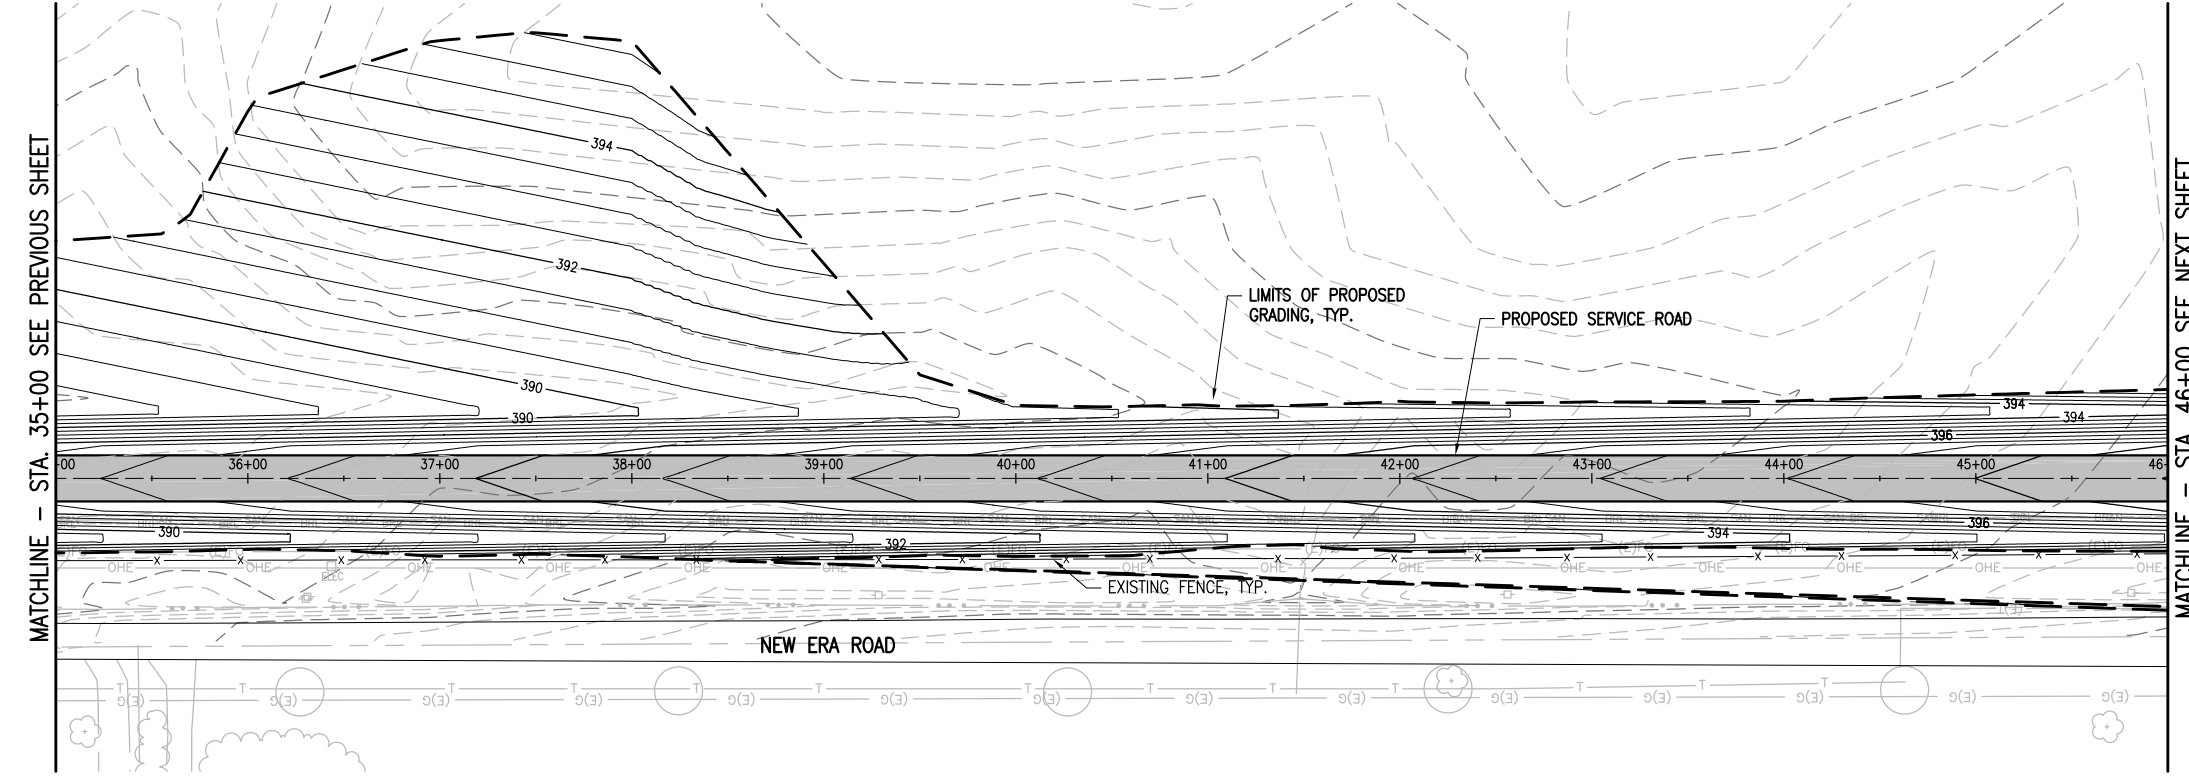

REVISION		 SOUTHERN ILLINOIS AIRPORT MURPHYSBORO / CARBONDALE, ILLINOIS
DATE		
 © Copyright Hanson Professional Services Inc. 2012 Hanson Professional Services Inc. 3125 New Era Road Murphysboro, Illinois 62866		
Hanson Project No. 11A0037 Filename C-701-PNP Scale 1"=50'H 1"=5'V Date 04/20/12		
LAYOUT	DAW	03/29/12
DRAWN	MLH	03/29/12
REVIEWED	JSL	04/20/12
CONSTRUCT PERIMETER ROAD TO SUPPORT ARFF/SRE BUILDING		
PLAN AND PROFILE - STA. 35+00.00 TO STA. 46+00.00		
10		
10 of 51 sheets		