



F.A. RTE.	SECTION	COUNTY	TOTAL SHEETS	SHEET NO.
* 2004-025-RS	LAKE	116	53	
STA.	TO STA.			
FED. ROAD DIST. NO.	ILLINOIS	FED. AID PROJECT		
* PARK ROADS		CONTRACT NO. 62745		
IDNR FILE NO. 2-03-025				

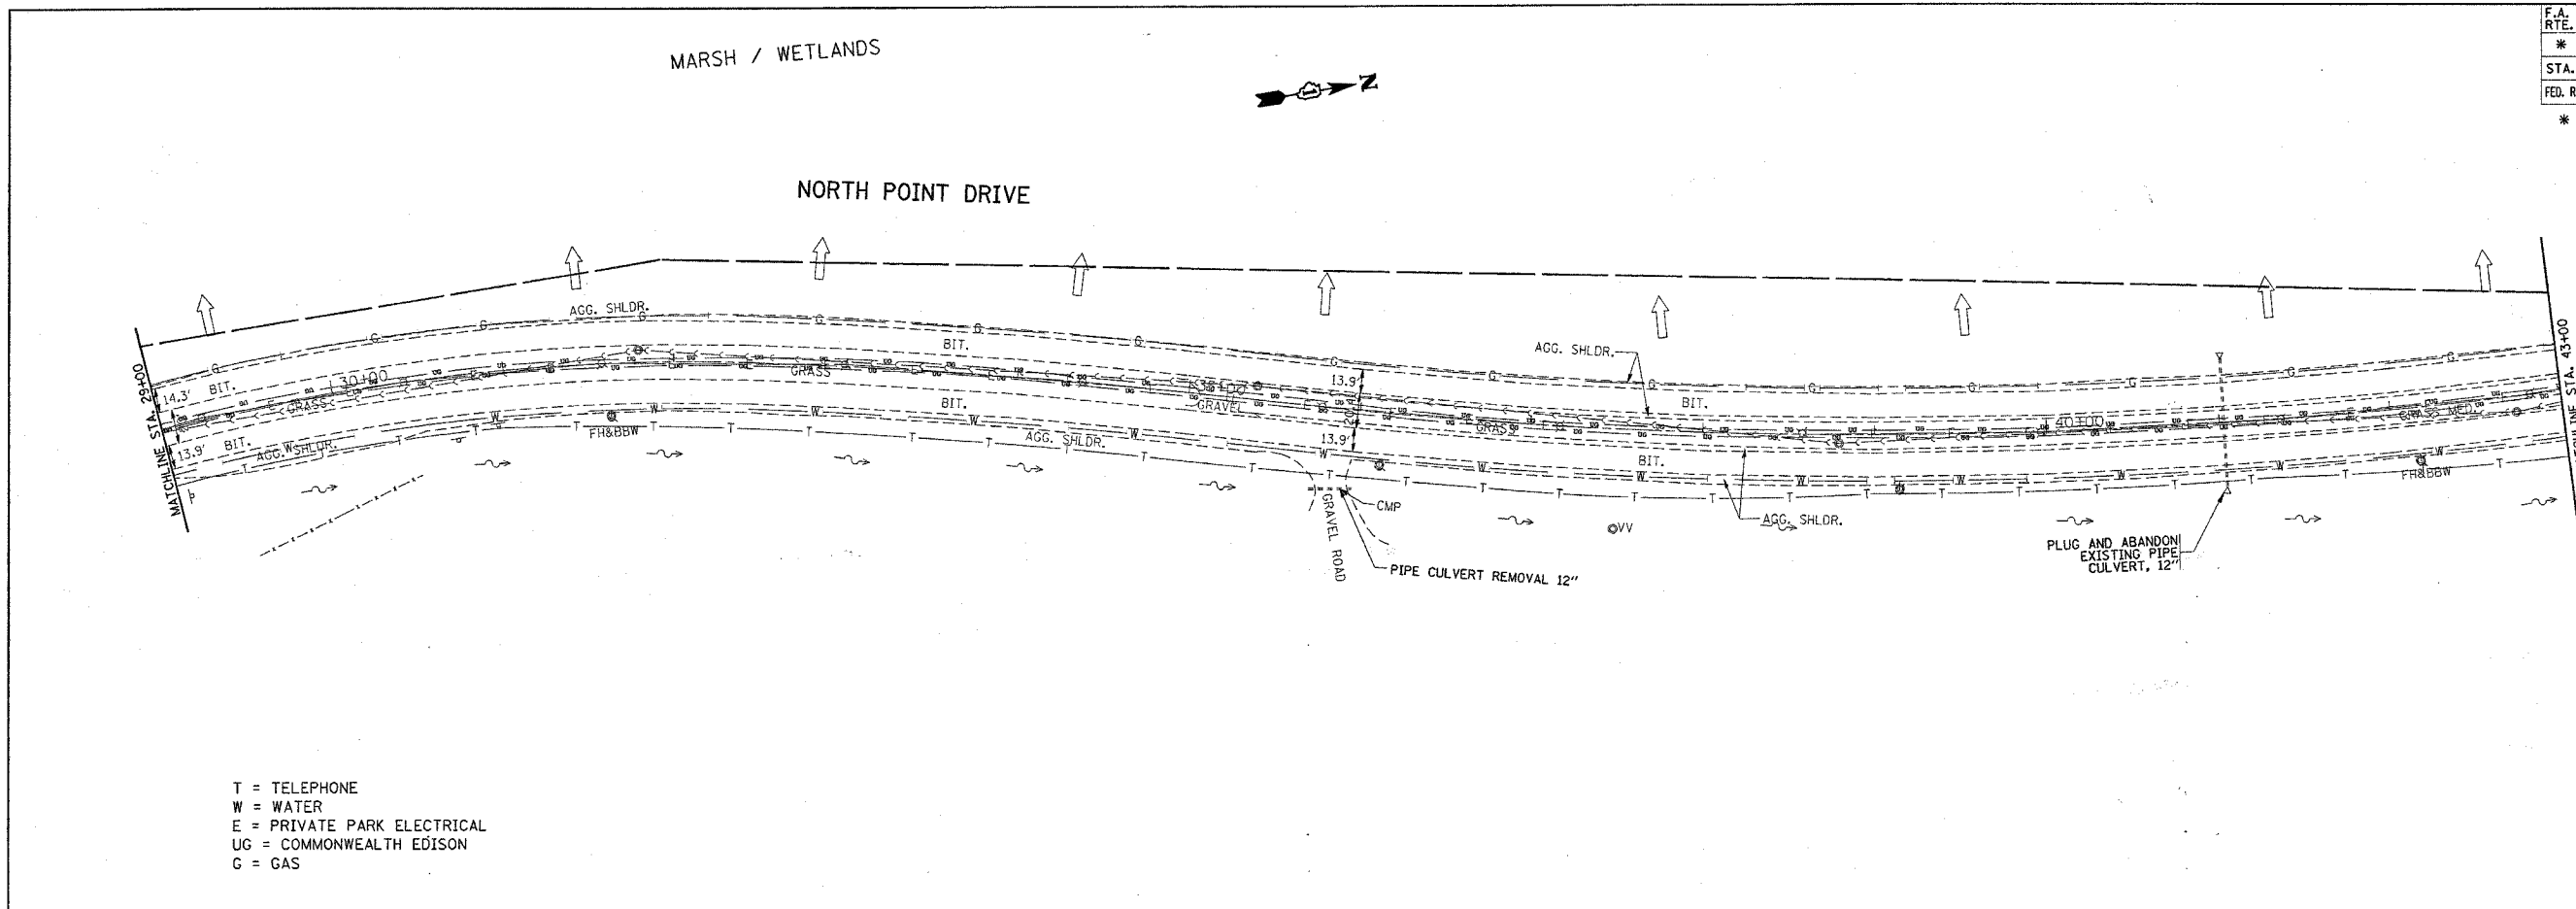

T = TELEPHONE
W = WATER
E = PRIVATE PARK ELECTRICAL
UG = COMMONWEALTH EDISON
G = GAS

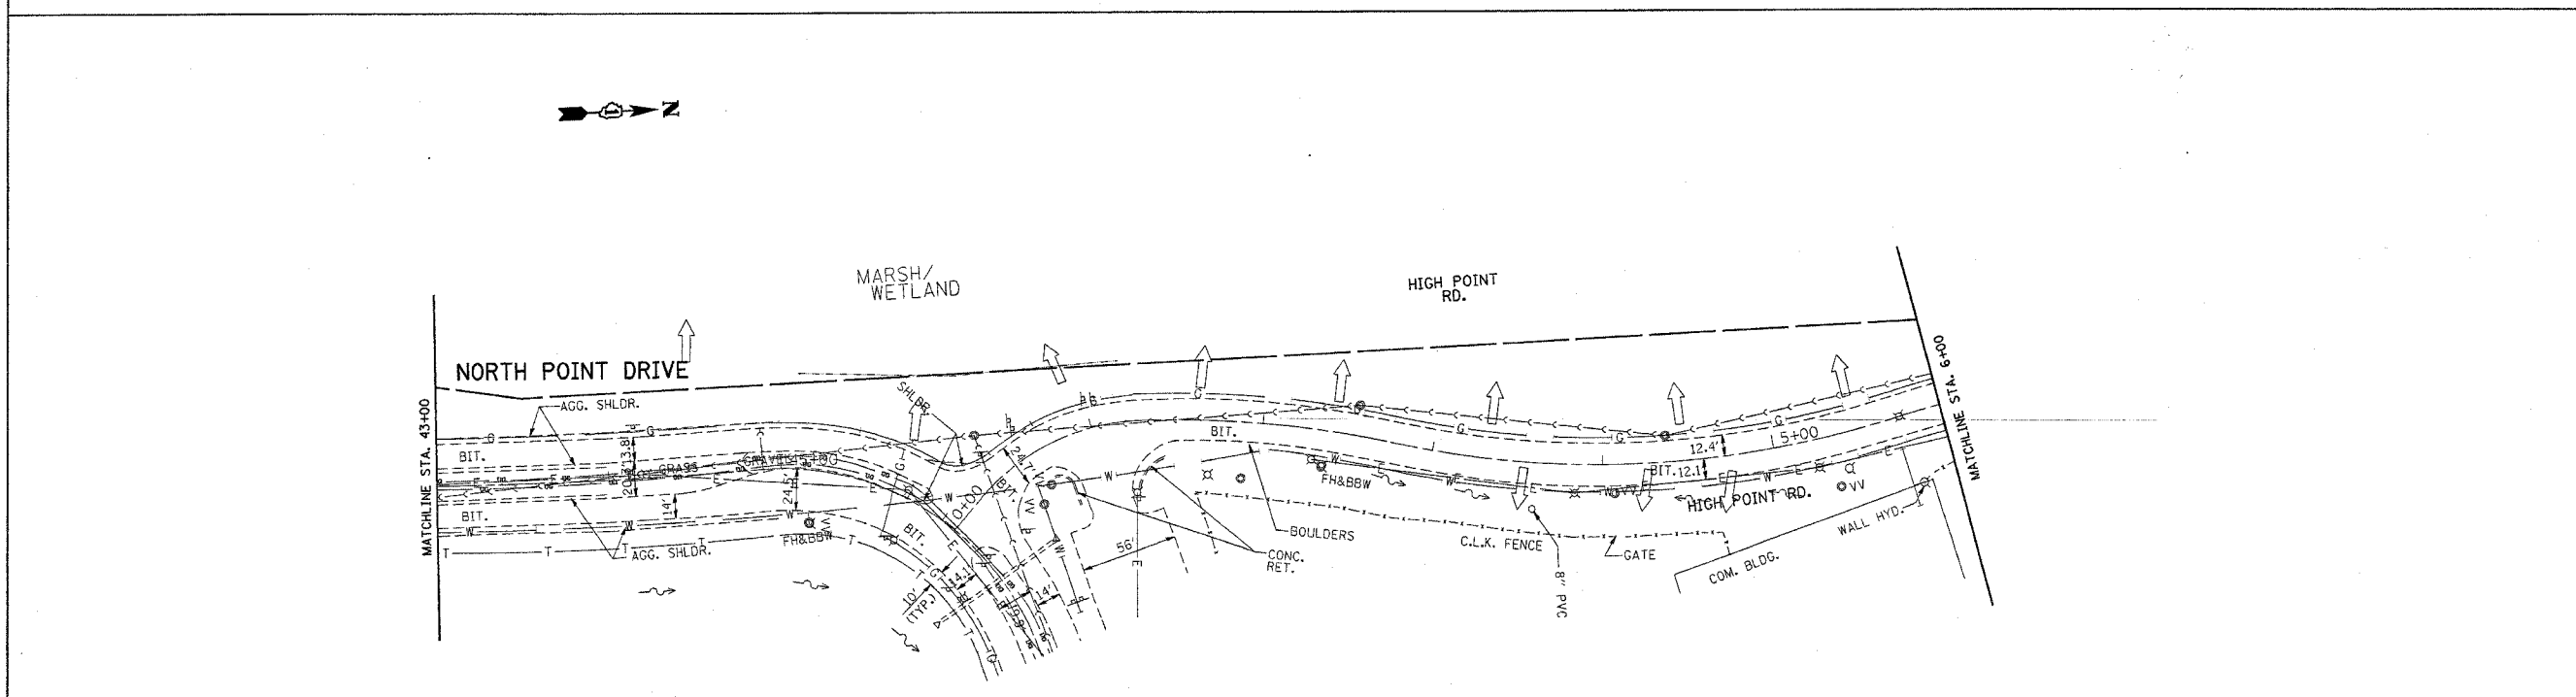

T = TELEPHONE
W = WATER
E = PRIVATE PARK ELECTRICAL
UG = COMMONWEALTH EDISON
G = GAS

REVISIONS	
NAME	DATE

ILLINOIS DEPARTMENT OF TRANSPORTATION
**NORTH POINT MARINA
NORTH POINT DRIVE
EXISTING UTILITY & DRAINAGE PLAN**
SCALE: VERT. 1"=50'
HORIZ. 1"=50'
DATE: 3/6/2006
DRAWN BY
CHECKED BY

PLOT DATE = 3/6/2006
FILE NAME = c:\p\proj\msta\1034482\sh_drain.dgn
PLOT SCALE = 50.000000 / IN.
USER NAME = jdrank