
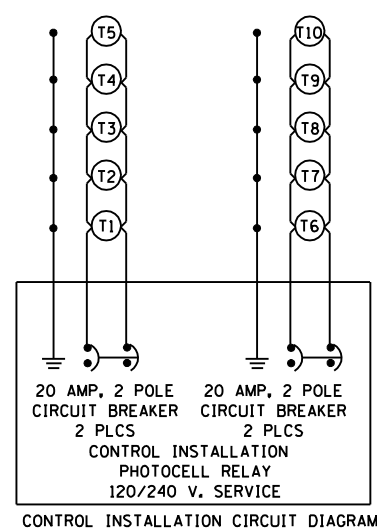
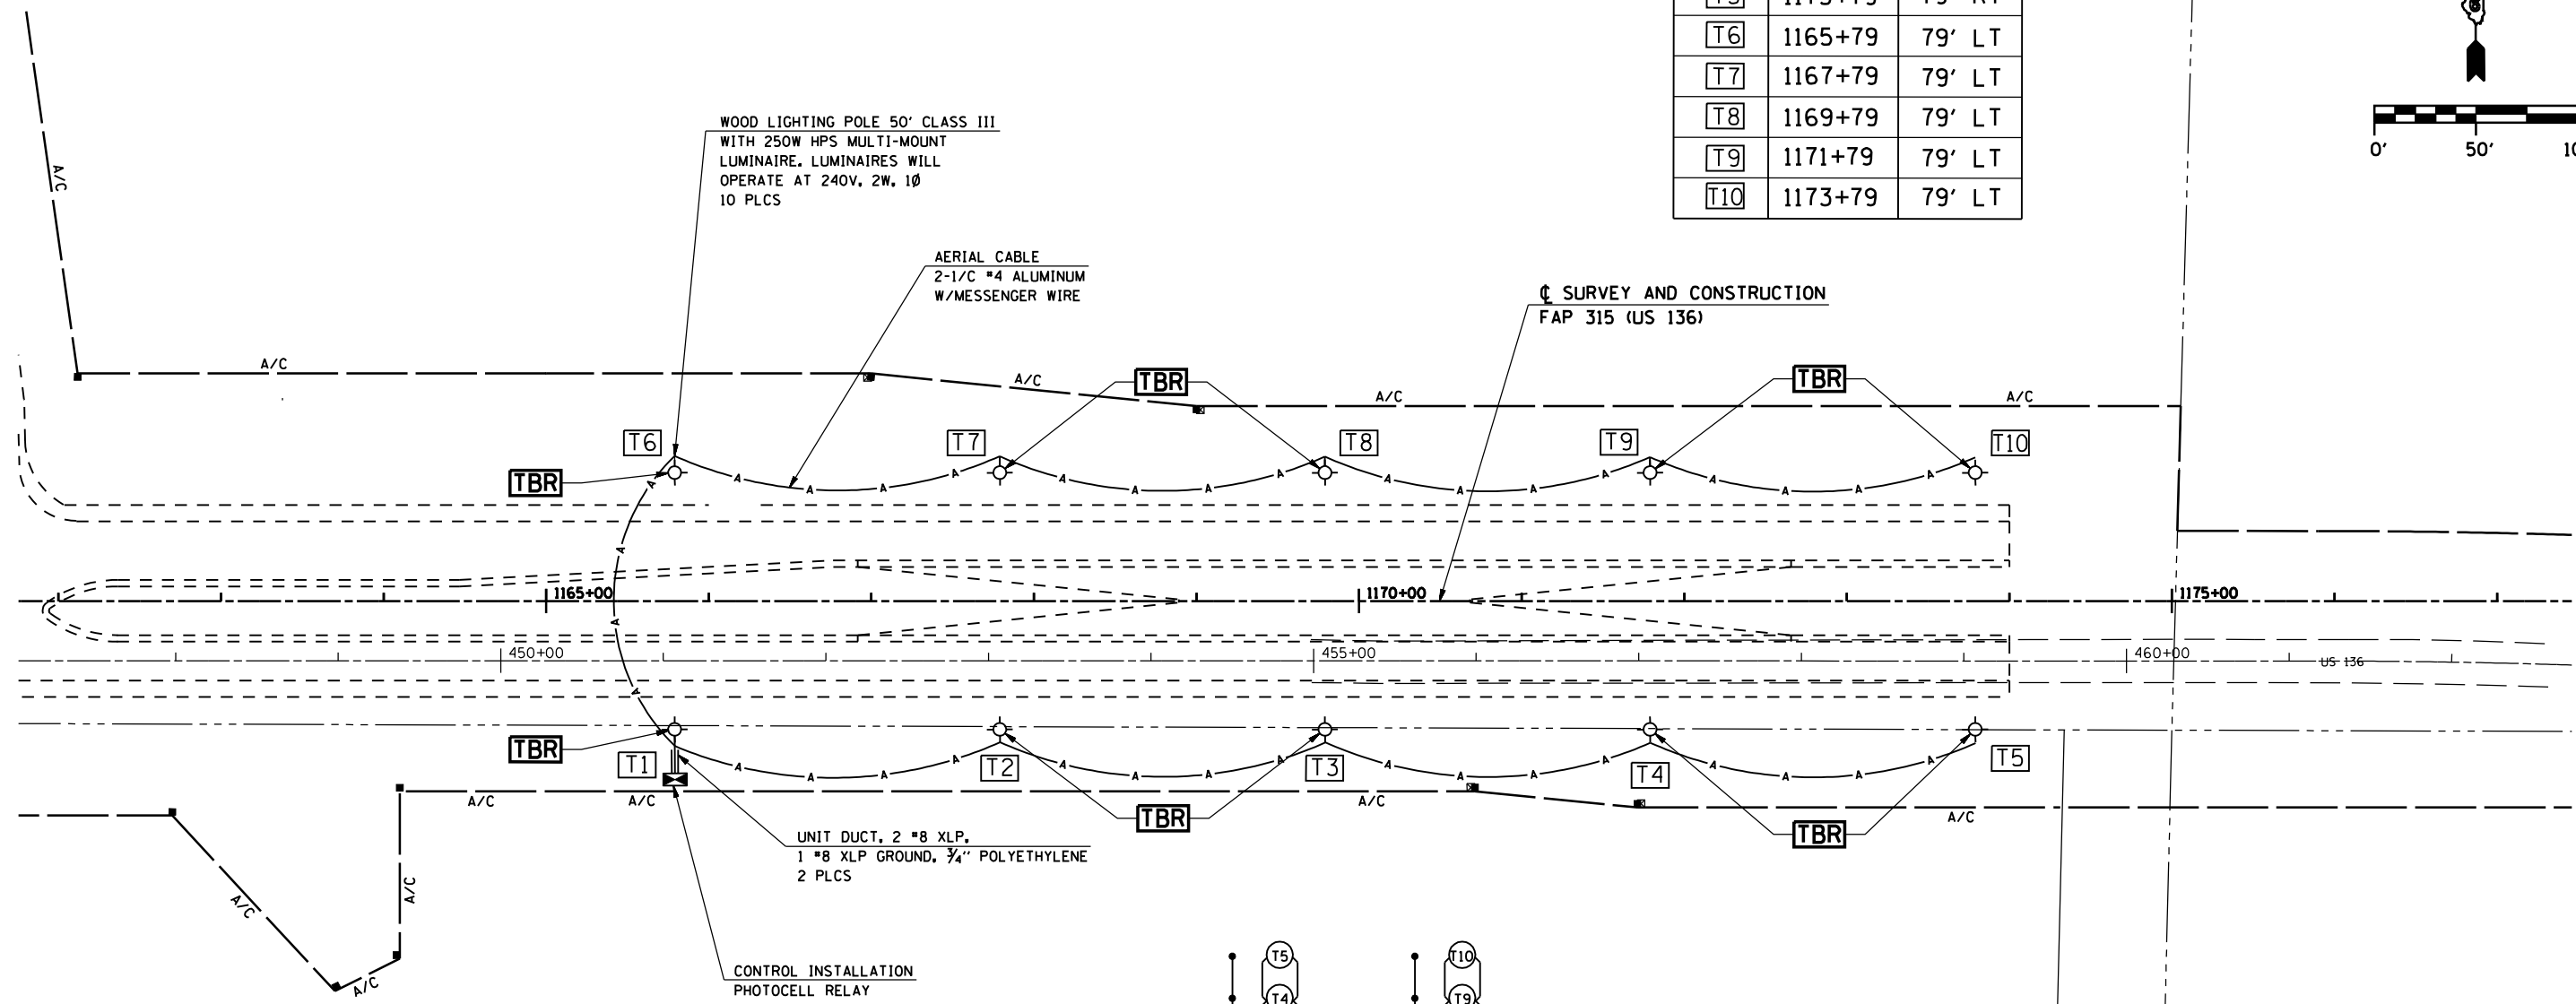


F.A.P. RTE.	SECTION	COUNTY	TOTAL SHEETS	SHEET No.
315	34-5	HANCOCK	612	243
STA. 1162+00.00		TO STA. 1177+00.00		
FED. ROAD DIST. No.	ILLINOIS	FED. AID PROJECT		

POLE	STATION	OFFSET
T1	1165+79	79' RT
T2	1167+79	79' RT
T3	1169+79	79' RT
T4	1171+79	79' RT
T5	1173+79	79' RT
T6	1165+79	79' LT
T7	1167+79	79' LT
T8	1169+79	79' LT
T9	1171+79	79' LT
T10	1173+79	79' LT

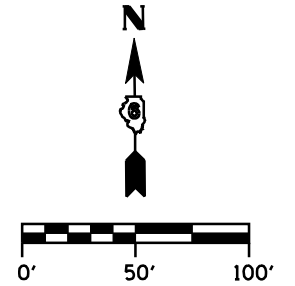

REVISIONS	
NAME	DATE

ILLINOIS DEPARTMENT OF TRANSPORTATION
FAP 315 (US 136)
LIGHTING PLAN
CROSSOVER @ STA 1170+00
 SCALE: 1" = 50'-0"
 DATE: MARCH 10, 2006
 DRAWN BY: RG
 CHECKED BY: JAC

DGN-SPEC
 DATE-TIME
 *REF01

D6 PROJECT: FILE: