 



| | | | | |
|----------------------|---------|-----------|--------------|-----------|
| FAP NO. | SECTION | COUNTY | TOTAL SHEETS | SHEET NO. |
| 805 | 147BR | ST. CLAIR | 52 | 20 |
| STA. | | TO STA. | | |
| EXISTING CONDITIONS: | | | | |
| CONTRACT NO. 76393 | | | | |

| | | | |
|------|--------------------|----|------|
| PLAN | SURVEYED | BY | DATE |
| | ADJUSTMENT CHECKED | | |
| | PT. OF NEW CHECKED | | |
| | NO. FILE NAME | | |

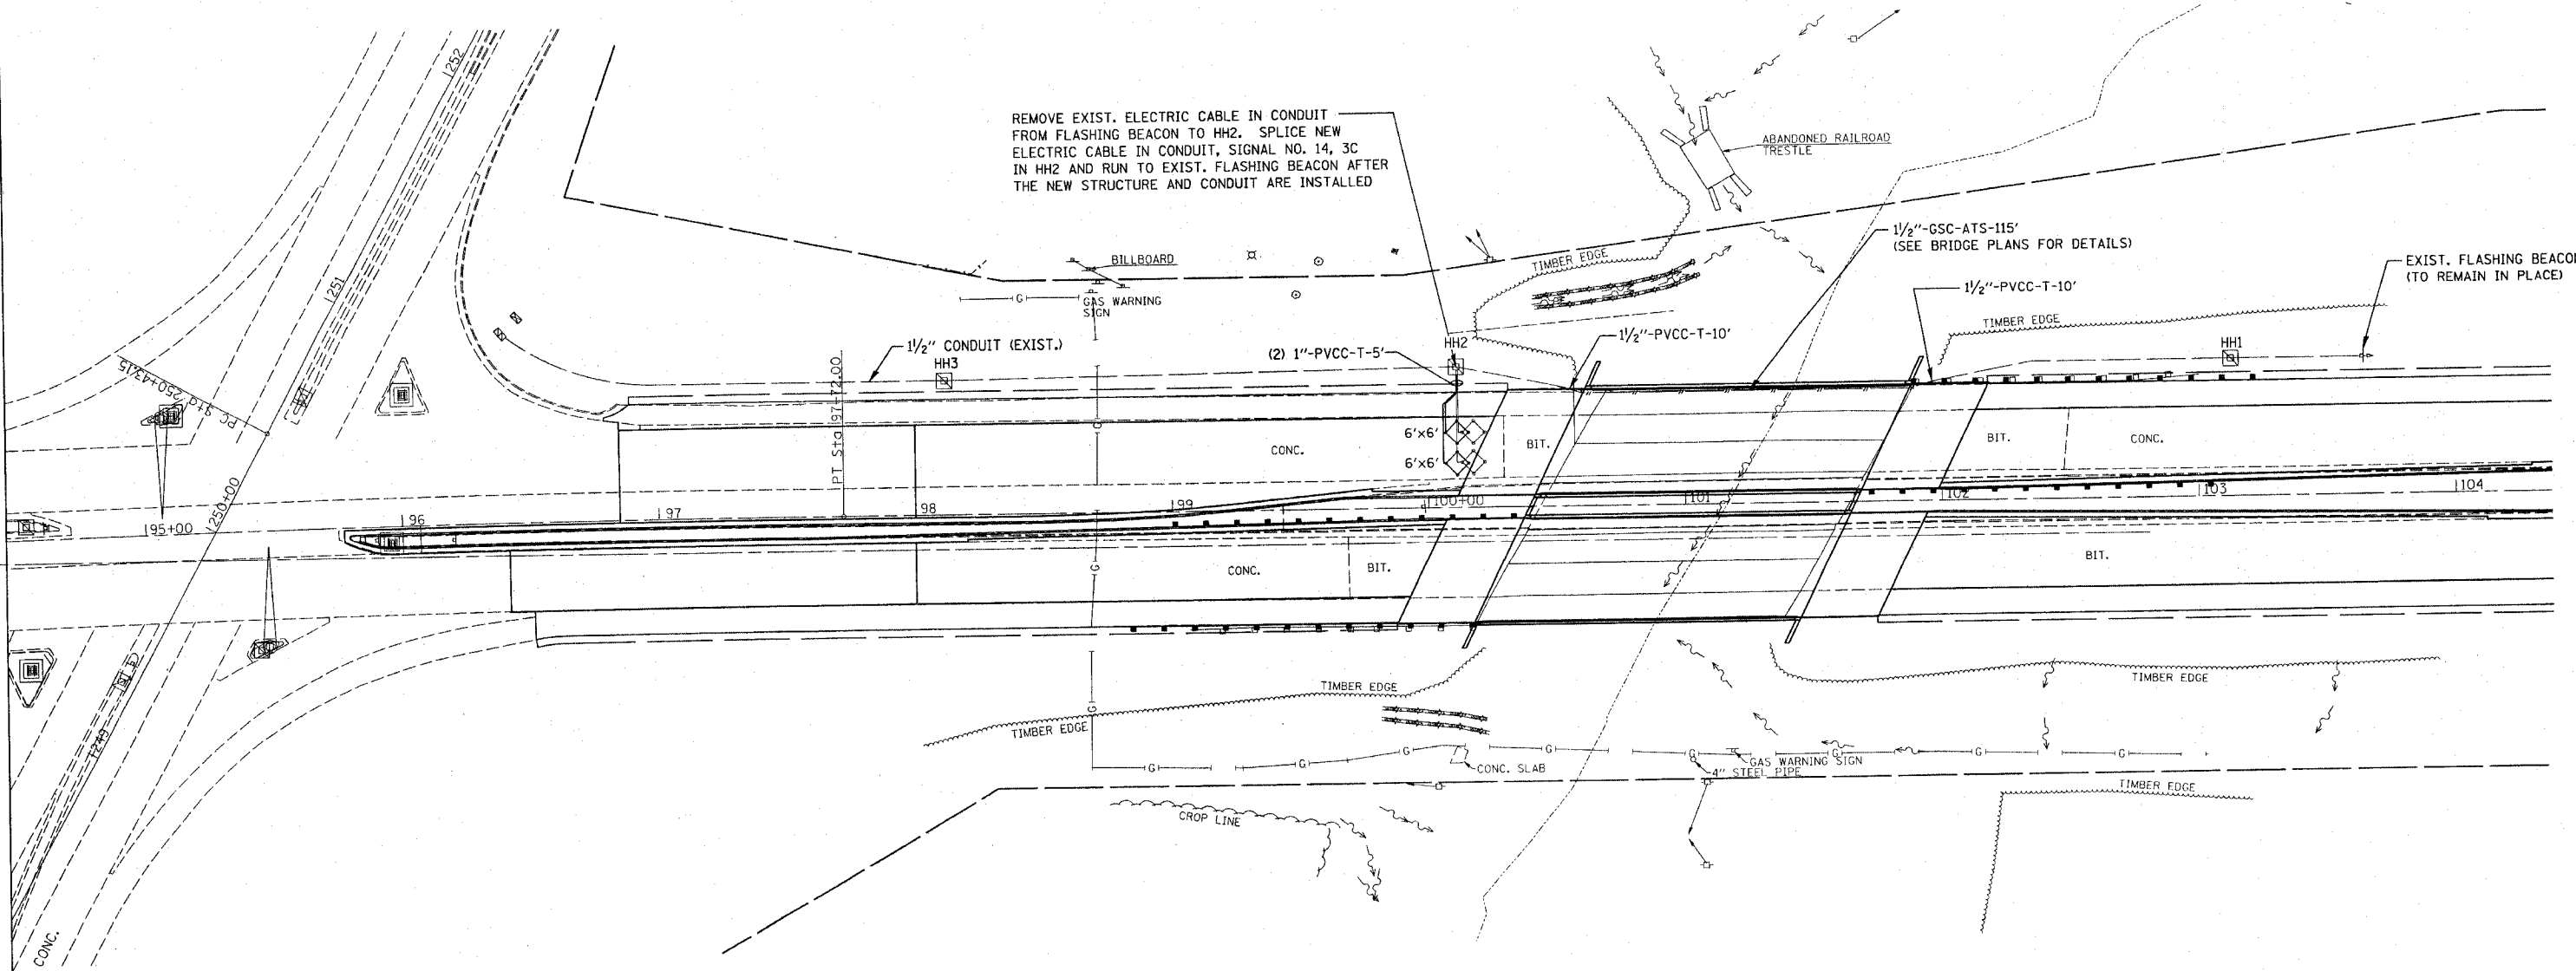

ILLINOIS DEPARTMENT OF TRANSPORTATION

ELECTRICAL PLAN SHEET

FAP ROUTE 805
SECTION 147BR
ST. CLAIR COUNTY

DRAWN BY:

PLOT DATE: *DATE-TIME*

| REVISIONS | |
|-----------|------|
| NAME | DATE |
| | |
| | |
| | |
| | |
| | |

BOOK SPEC
REF.