


| | | | | |
|-------------|-----------------|--------|--------------|-----------|
| F.A.P. RTE. | SECTION | COUNTY | TOTAL SHEETS | SHEET NO. |
| 0369 | 97-000-25-00 BR | WILL | 156 | 95 |
| STA. | TO STA. | | | |
| D-91-467-97 | 83757 | | | |

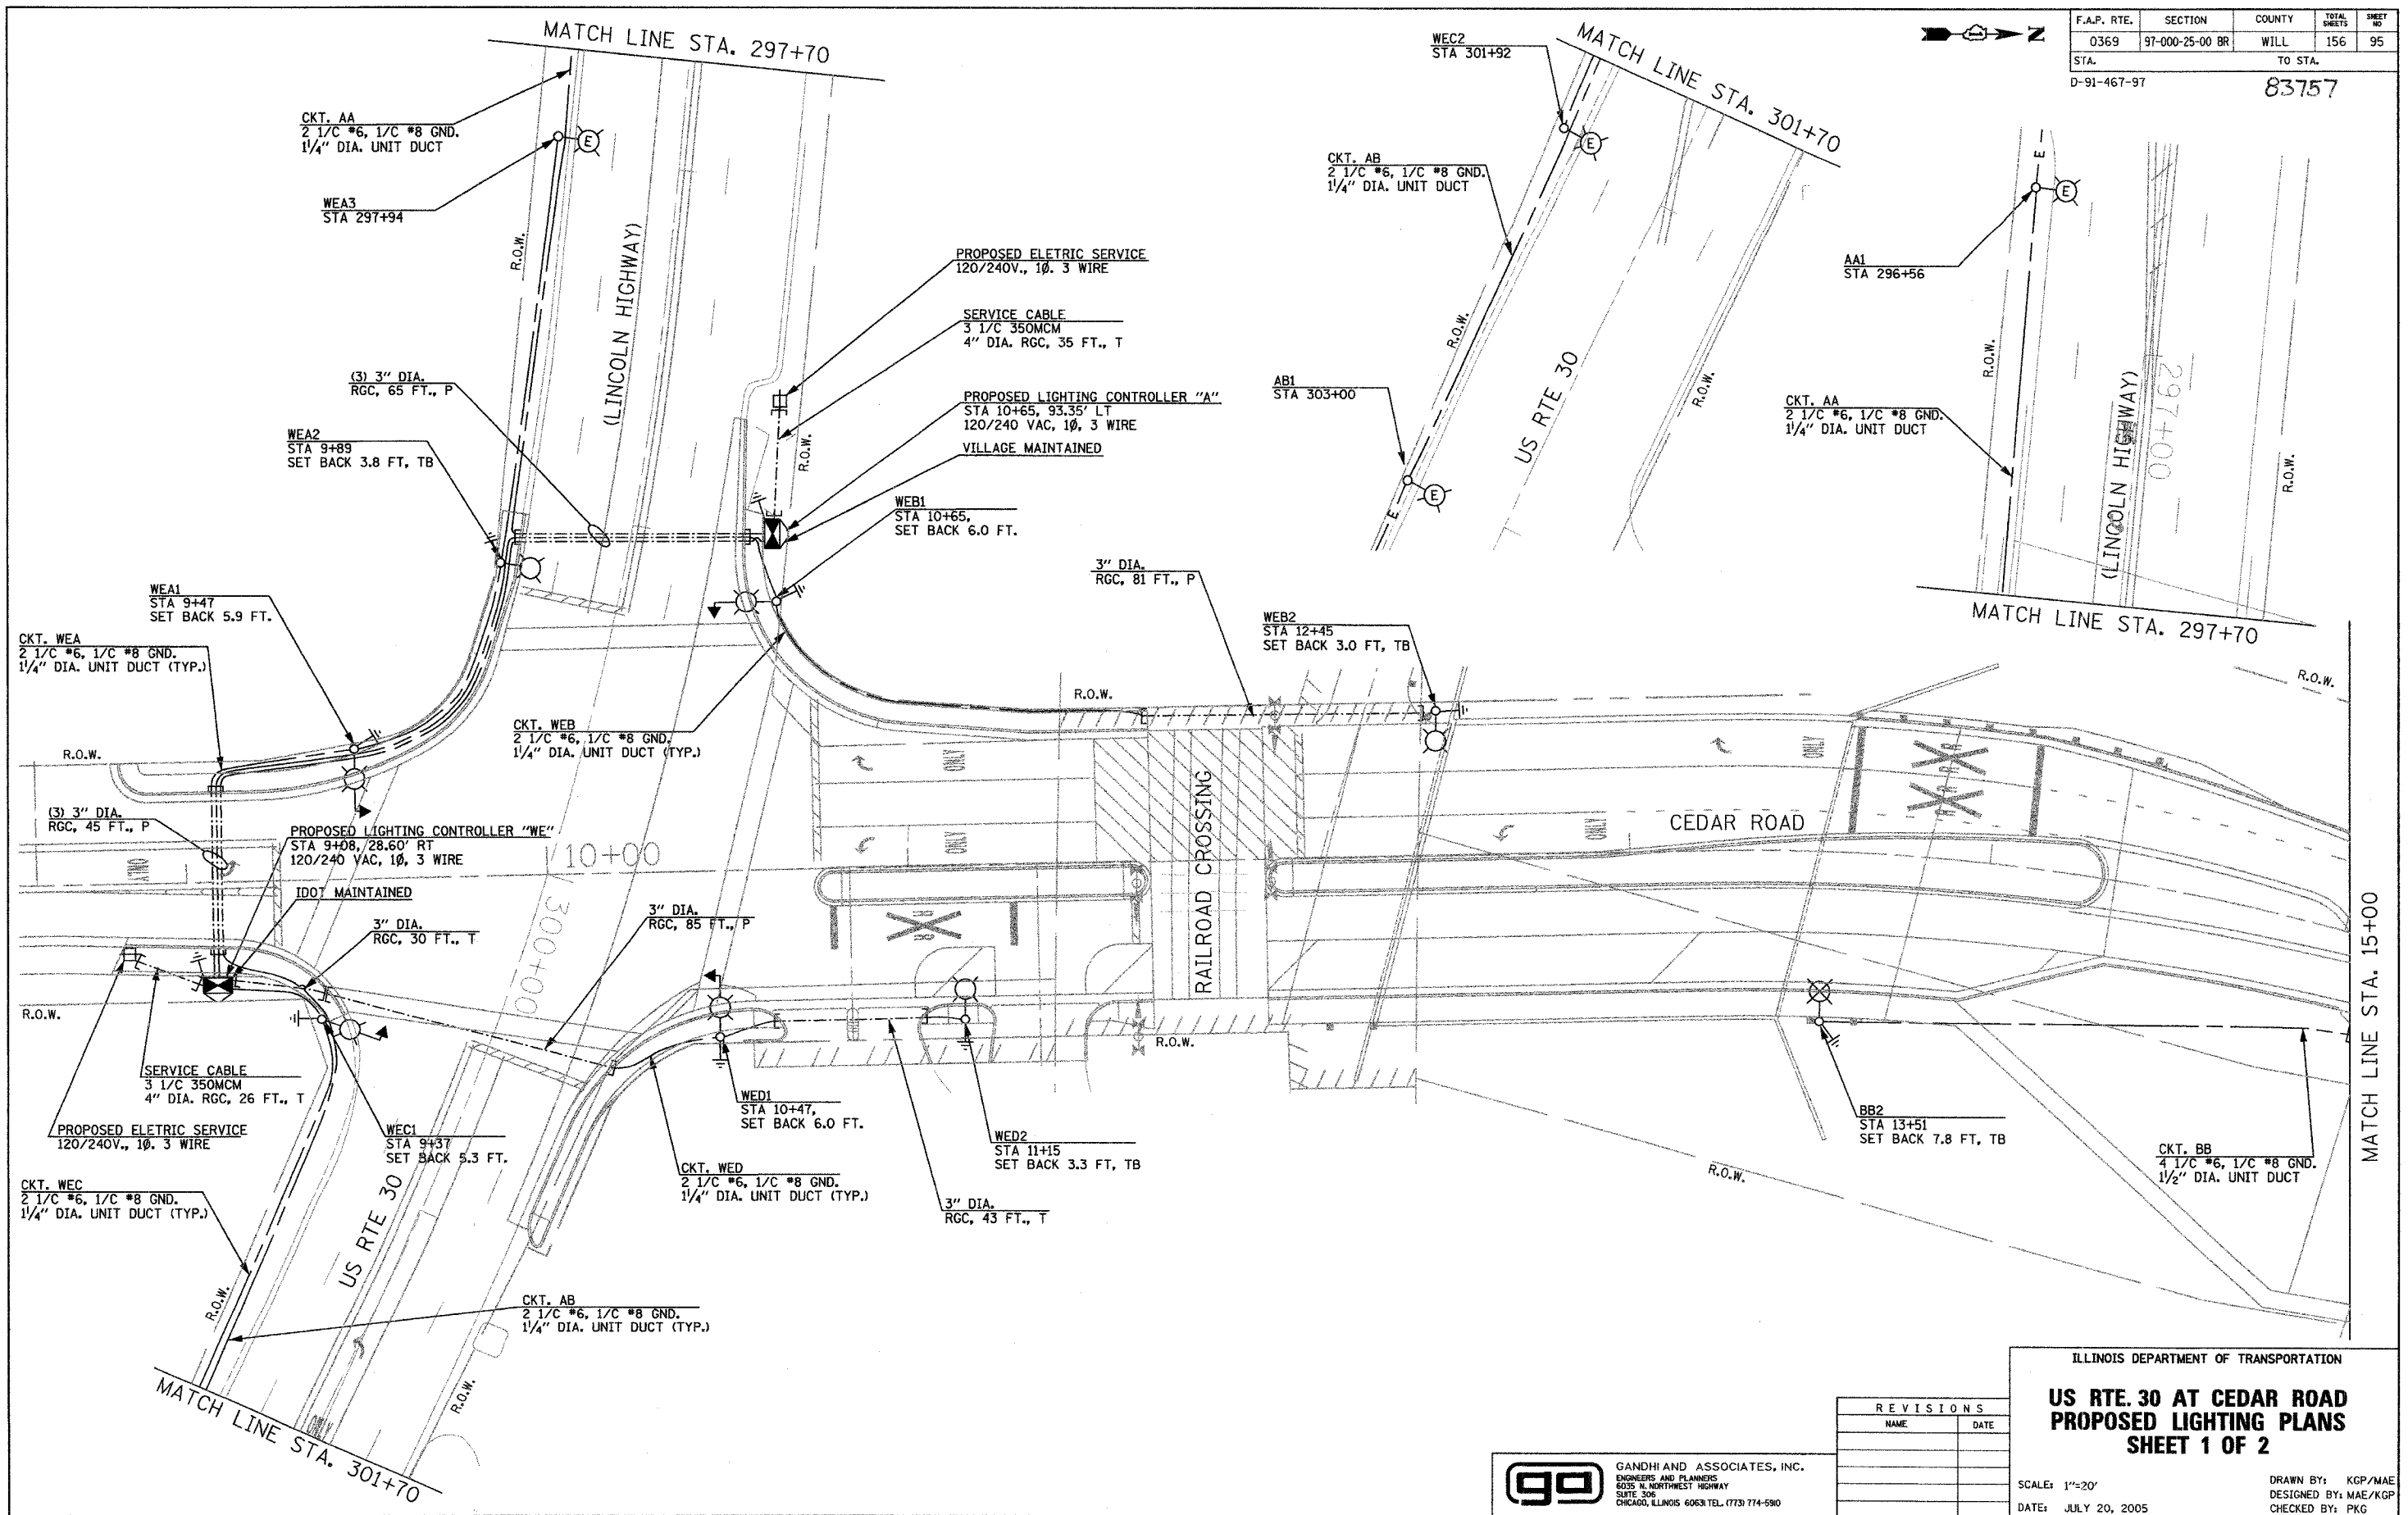

J:\PROJECTS\PROJECTS 2003\CEDARRD\LIGHTING\E-03-LT01.DGN
 20 JUL 2005
 15:22:35

GO GANDHI AND ASSOCIATES, INC.
 ENGINEERS AND PLANNERS
 6035 N. NORTHWEST HIGHWAY
 SUITE 306
 CHICAGO, ILLINOIS 60638 TEL. (773) 774-690

| REVISIONS | |
|-----------|------|
| NAME | DATE |
| | |
| | |
| | |
| | |

ILLINOIS DEPARTMENT OF TRANSPORTATION
**US RTE. 30 AT CEDAR ROAD
 PROPOSED LIGHTING PLANS
 SHEET 1 OF 2**
 SCALE: 1"=20'
 DATE: JULY 20, 2005
 DRAWN BY: KGP/MAE
 DESIGNED BY: MAE/KGP
 CHECKED BY: PKG