
 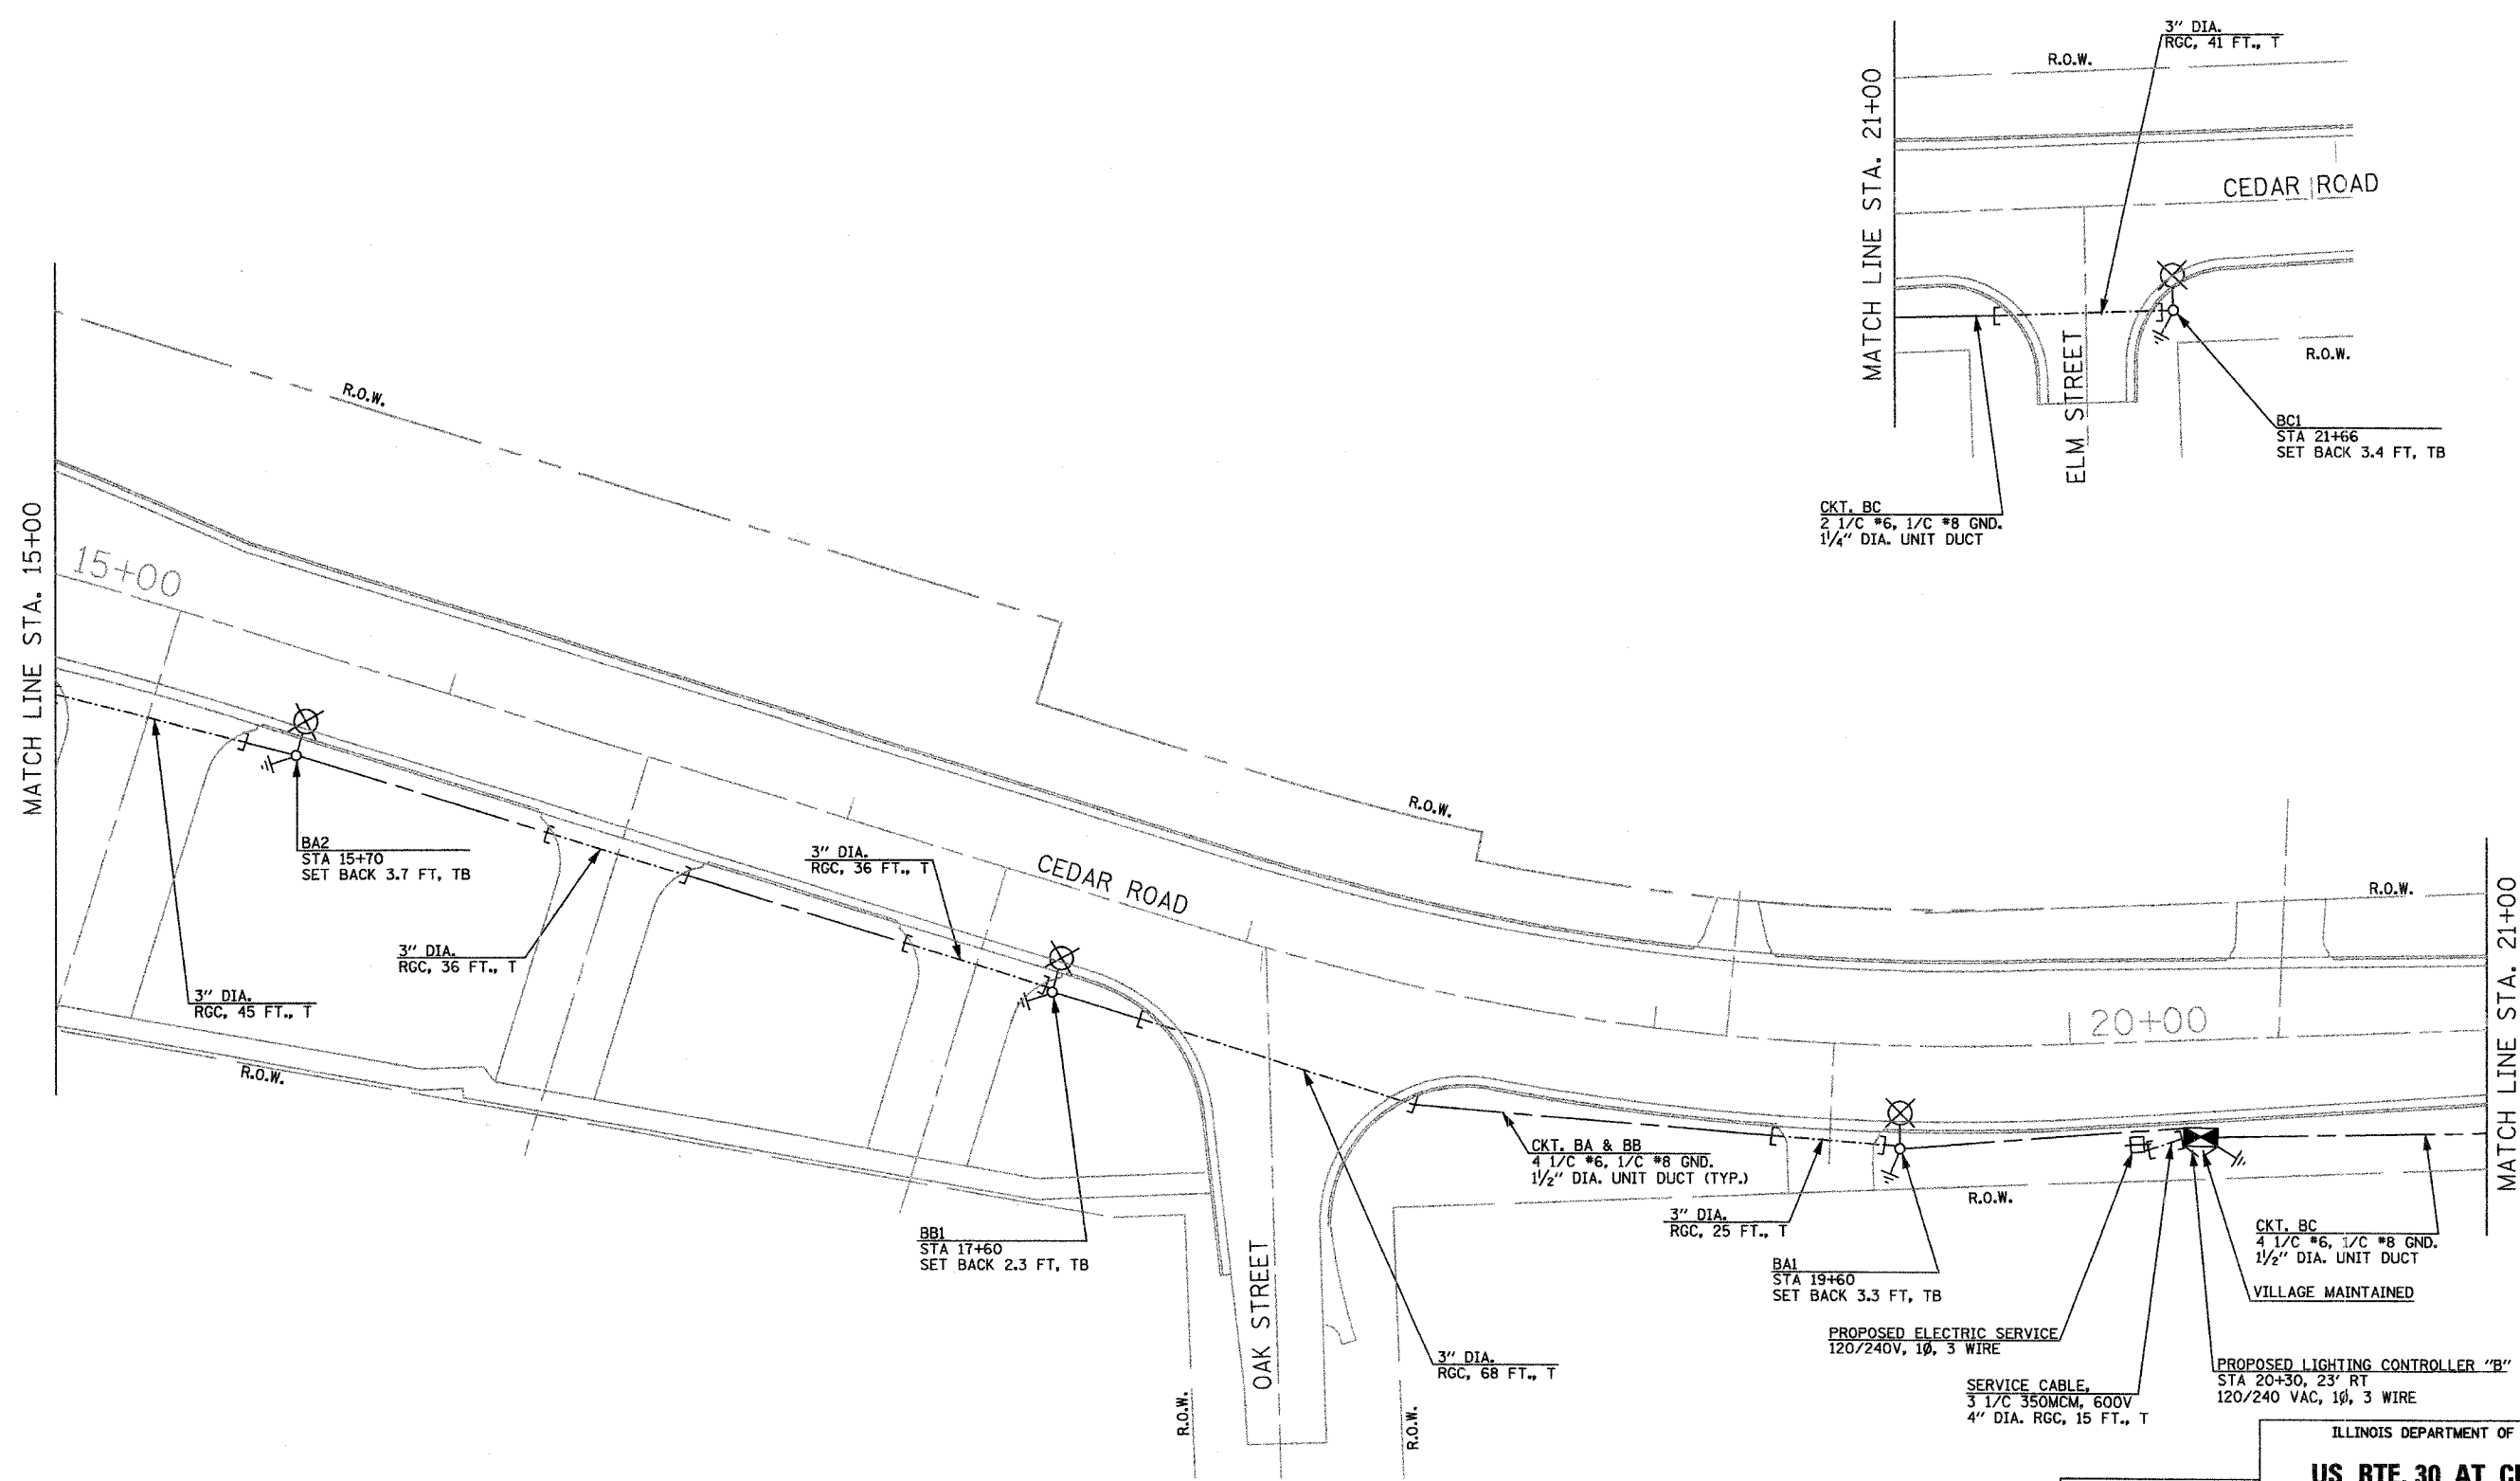


F.A.P. RTE.	SECTION	COUNTY	TOTAL SHEETS	SHEET NO.
0369	97-000-25-00 BR	WILL	156	96
STA.	TO STA.			
D-91-467-97	83757			



REVISIONS	
NAME	DATE

ILLINOIS DEPARTMENT OF TRANSPORTATION
US RTE. 30 AT CEDAR ROAD
PROPOSED LIGHTING PLANS
SHEET 2 OF 2

SCALE: 1"=20'
DATE: JULY 20, 2005

DRAWN BY: KGP/MAE
DESIGNED BY: MAE/KGP
CHECKED BY: PKG

go GANDHI AND ASSOCIATES, INC.
ENGINEERS AND PLANNERS
6035 N. NORTHWEST HIGHWAY
SUITE 306
CHICAGO, ILLINOIS 60631 TEL. (773) 774-590