
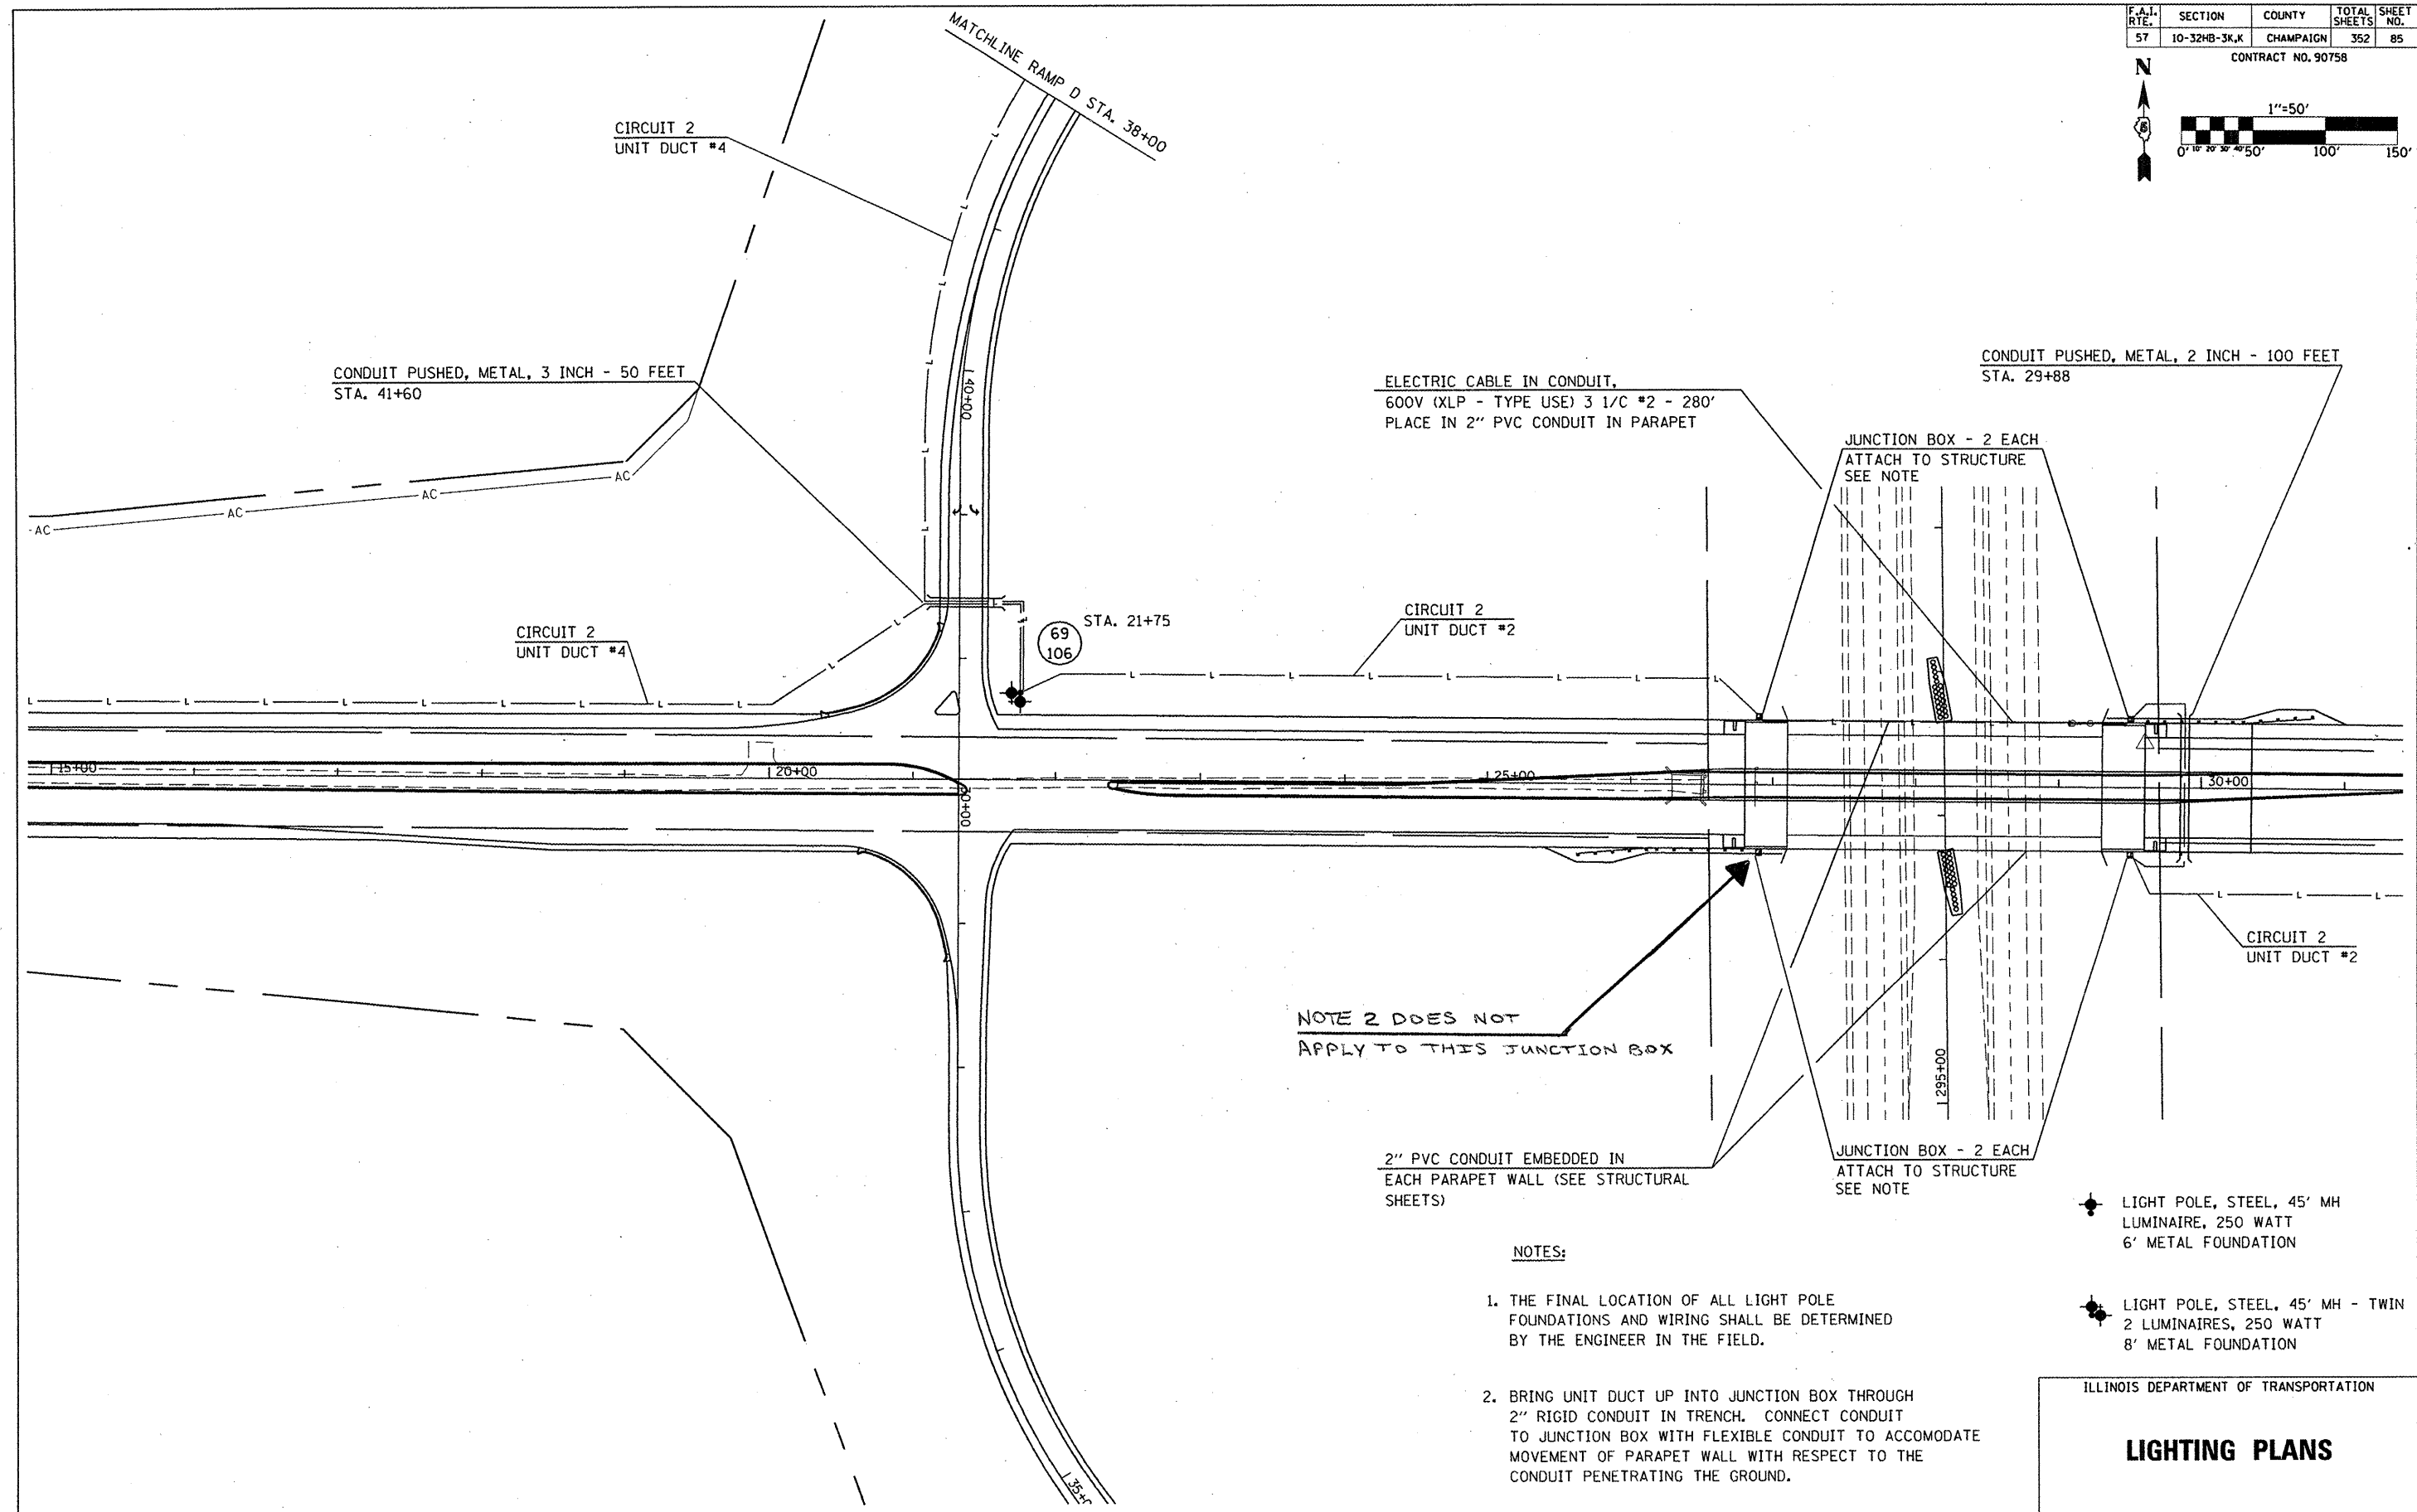


F.A.I. RTE.	SECTION	COUNTY	TOTAL SHEETS	SHEET NO.
57	10-32HB-3K,K	CHAMPAIGN	352	85

CONTRACT NO. 90758

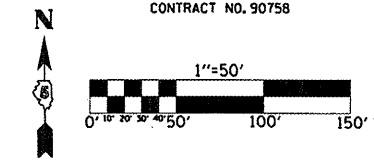

- NOTES:**
1. THE FINAL LOCATION OF ALL LIGHT POLE FOUNDATIONS AND WIRING SHALL BE DETERMINED BY THE ENGINEER IN THE FIELD.
 2. BRING UNIT DUCT UP INTO JUNCTION BOX THROUGH 2" RIGID CONDUIT IN TRENCH. CONNECT CONDUIT TO JUNCTION BOX WITH FLEXIBLE CONDUIT TO ACCOMMODATE MOVEMENT OF PARAPET WALL WITH RESPECT TO THE CONDUIT PENETRATING THE GROUND.

- ◆ LIGHT POLE, STEEL, 45' MH LUMINAIRE, 250 WATT 6' METAL FOUNDATION
- ◆ LIGHT POLE, STEEL, 45' MH - TWIN 2 LUMINAIRES, 250 WATT 8' METAL FOUNDATION

ILLINOIS DEPARTMENT OF TRANSPORTATION
LIGHTING PLANS